


## **PLANNING APPLICATION DRAWING LIST**

DRAWING 3261/BB/01A	PROPOSED SITE LOCATION PLAN	1:10,000
DRAWING 3261/BB/02A	SITE OF APPLICATION	1:2,500
DRAWING 3261/BB/03	ORIENTATION PLAN OF SITE AND ACCESS	1:2,000
DRAWING 3261/BB/04A	ACCESS TRACK 1 EXISTING SITE ENTRANCE	1:500
DRAWING 3261/BB/05A	ACCESS TRACK 2 EXISTING GROUND PLAN	1:500
DRAWING 3261/BB/06A	PROPOSED SITE: EXISTING GROUND PLAN	1:500
DRAWING 3261/BB/07B	ACCESS TRACK 1 PROPOSED LAYOUT	1:500
DRAWING 3261/BB/08B	ACCESS TRACK 2 PROPOSED LAYOUT	1:500
DRAWING 3261/BB/09A	SITE LAYOUT CONSTRUCTION MODE	1:500
DRAWING 3261/BB/10A	SITE LAYOUT DRILLING MODE	1:500
DRAWING 3261/BB/11A	SITE LAYOUT TESTING MODE	1:500
DRAWING 3261/BB/12A	SITE LAYOUT LIGHTING	1:500
DRAWING 3261/BB/13	SITE SECTIONS DRILLING MODE	1:500
DRAWING 3261/BB/14	SITE DITCH CONSTRUCTION DETAILS	1:50
DRAWING 3261/BB/15A	PROPOSED SITE ENTRANCE	1:500


DRAWING 3261/BB/16	SITE SECTIONS EXISTING	1:500
DRAWING 3261/BB/17	SITE SECTIONS RETENTION	1:500
DRAWING 3261/BB/18	PROPOSED SITE RESTORATION PLAN	1:500

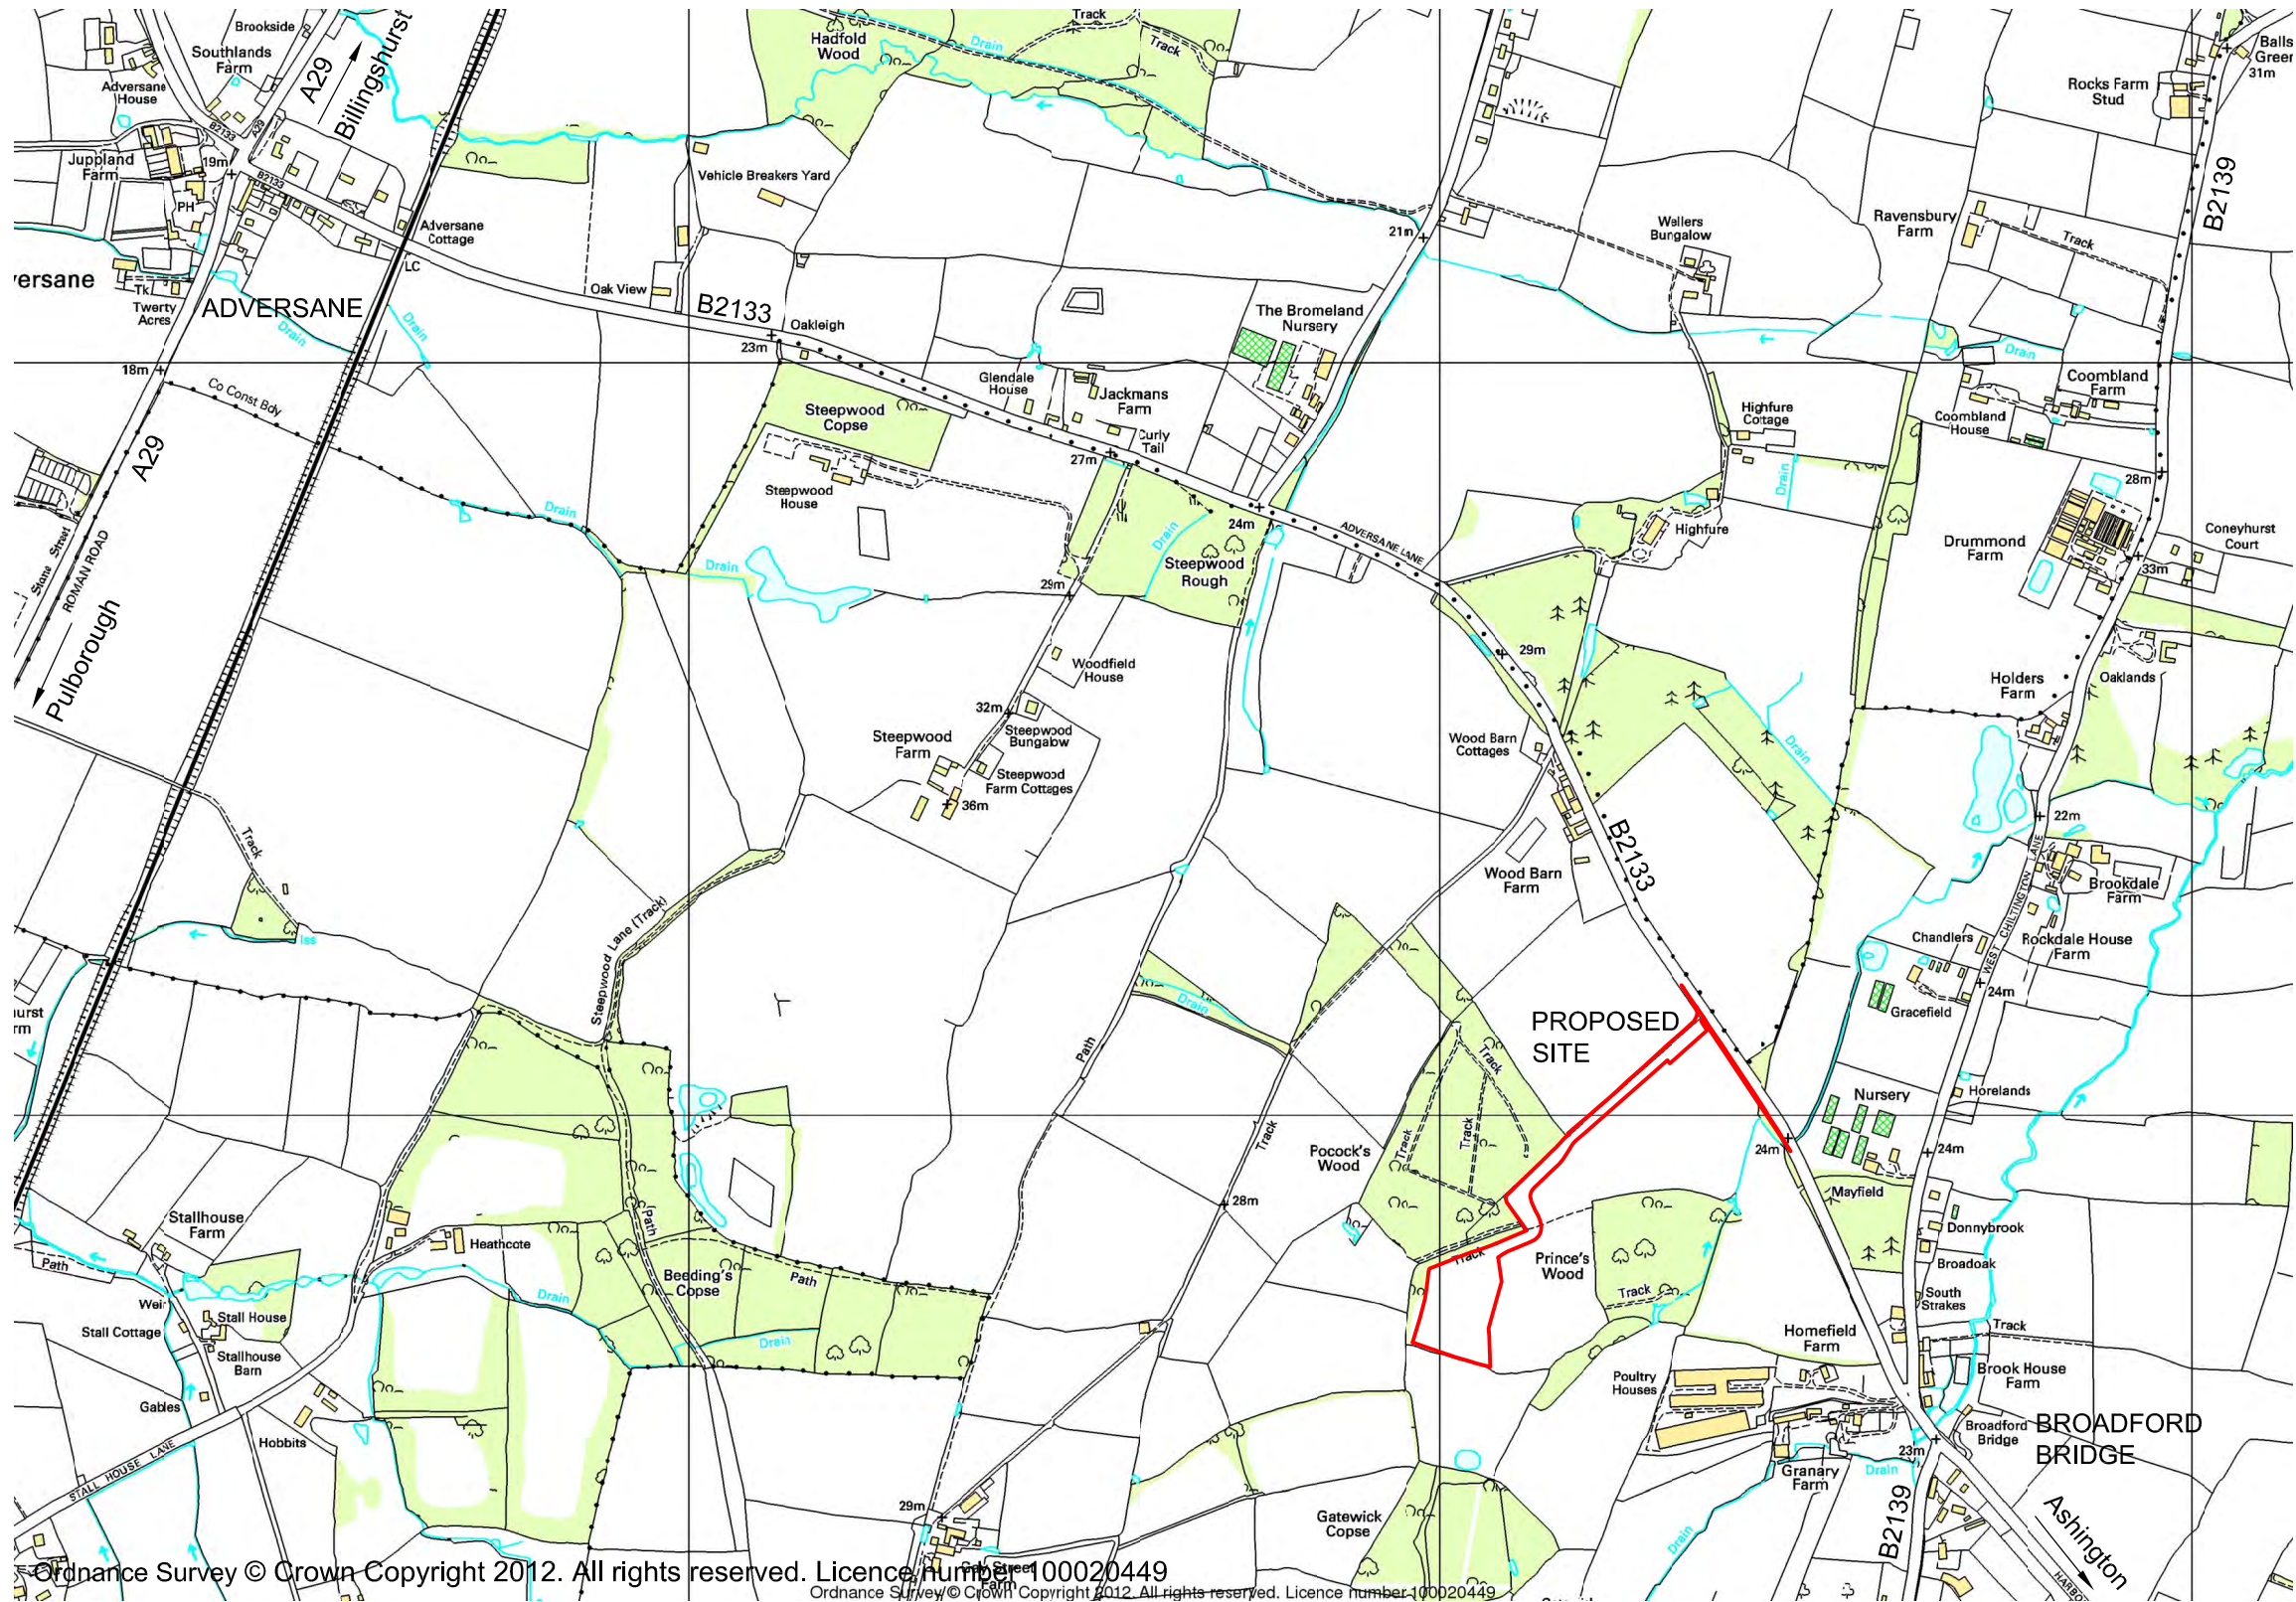

Ordnance Survey © Crown Copyright 2012. All rights reserved. Licence Number 100020449

### Proposed Site Location Plan

 Scale 1:10,000




**R ELLIOTT ASSOCIATES LTD**  
 CONSULTING STRUCTURAL & CIVIL ENGINEERS

t: (01590) 683176 f: (01590) 683533 info@rea-ltd.co.uk www.rea-ltd.co.uk



Dennett House  
 Brighton Road  
 Sway  
 Lymington  
 Hampshire  
 SO41 6EB


Client	Celtique Energie Petroleum Broadford Bridge West Sussex		Drawn By	AJNE	Date	July 2012	Sheet Size	A3
Job Title	Broadford Bridge Site		Drawing Title				Proposed Site Location Plan (1:10,000)	
			Drawing Number	3261/BB/01		Revision	A	

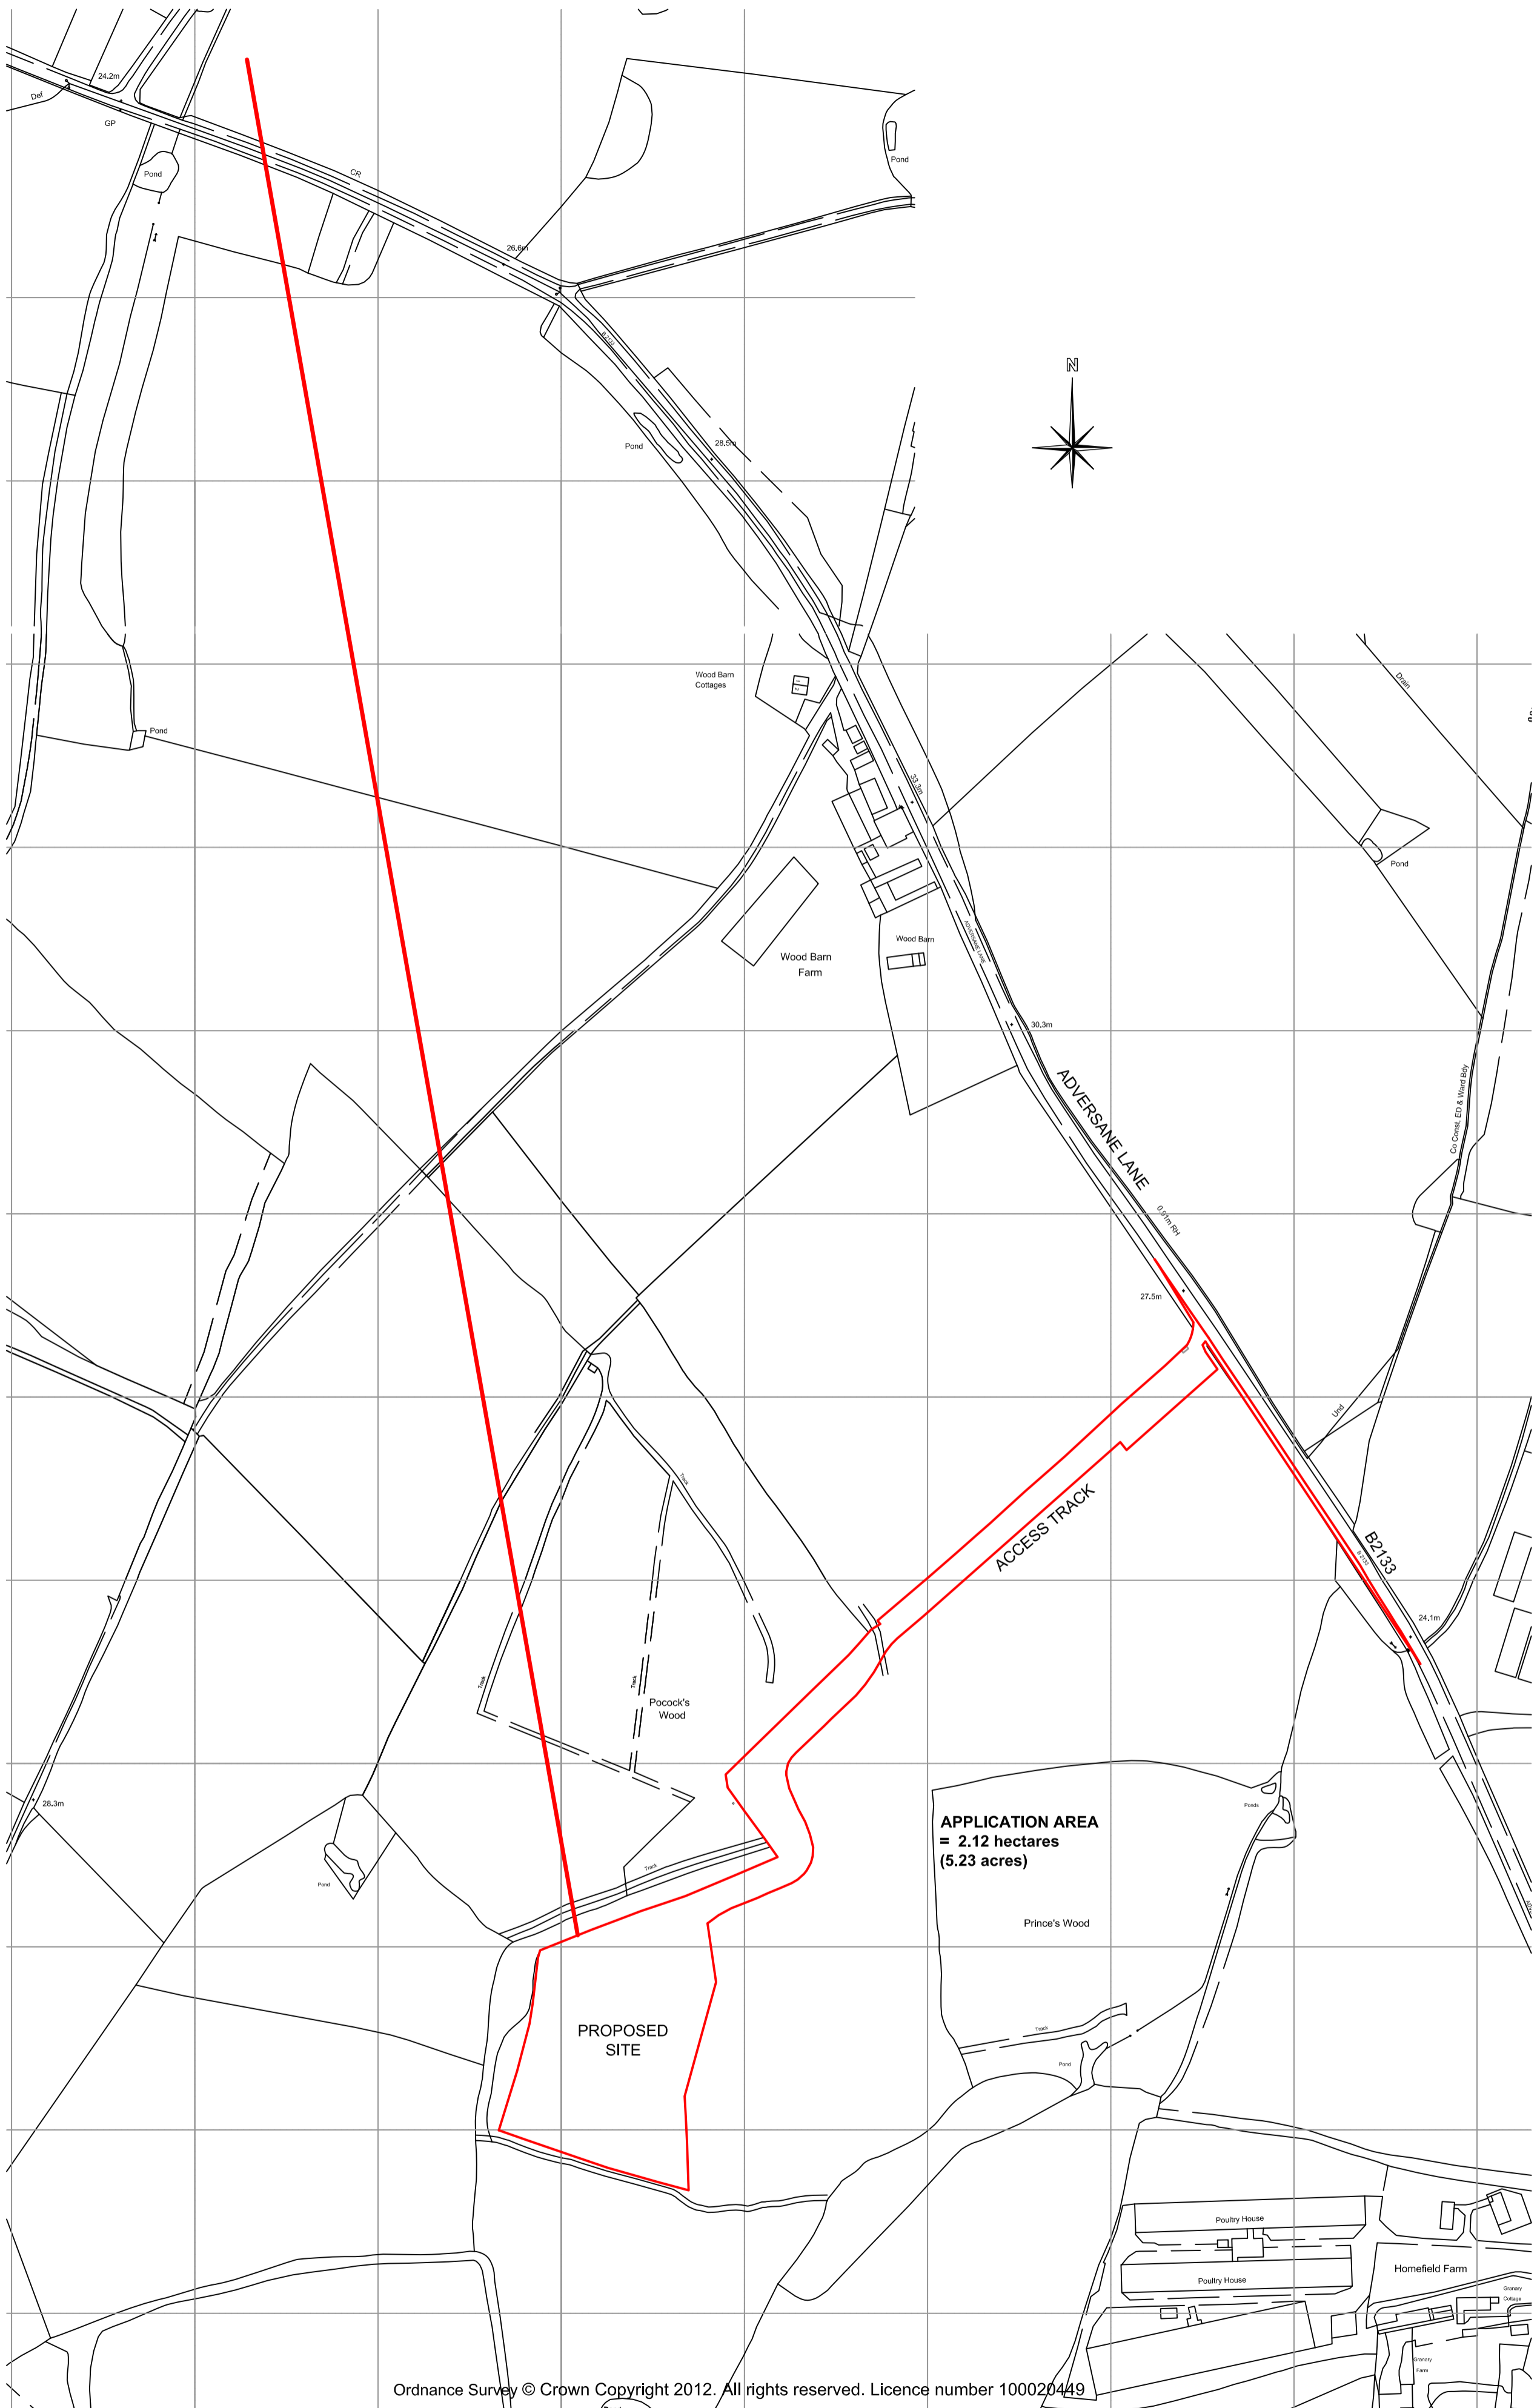

Ordnance Survey © Crown Copyright 2012. All rights reserved. Licence number 100020449

Site of Application  
Scale 1:2,500

0 25m 50m

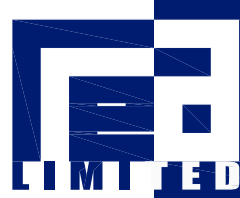

Dennett House  
Brighton Road  
Sway  
Lymington  
Hampshire  
SO41 6EB

Client  
**Celtique Energie Petroleum  
Broadford Bridge  
West Sussex**

Job Title  
**Broadford Bridge Site**

Drawn By

**AJNE**

Drawing Title

Date

**July 2012**

Drawing Number

**3261/BB/02**


Sheet Size

**A2**

Revision

**A**

**Site of Application  
(1:2,500)**

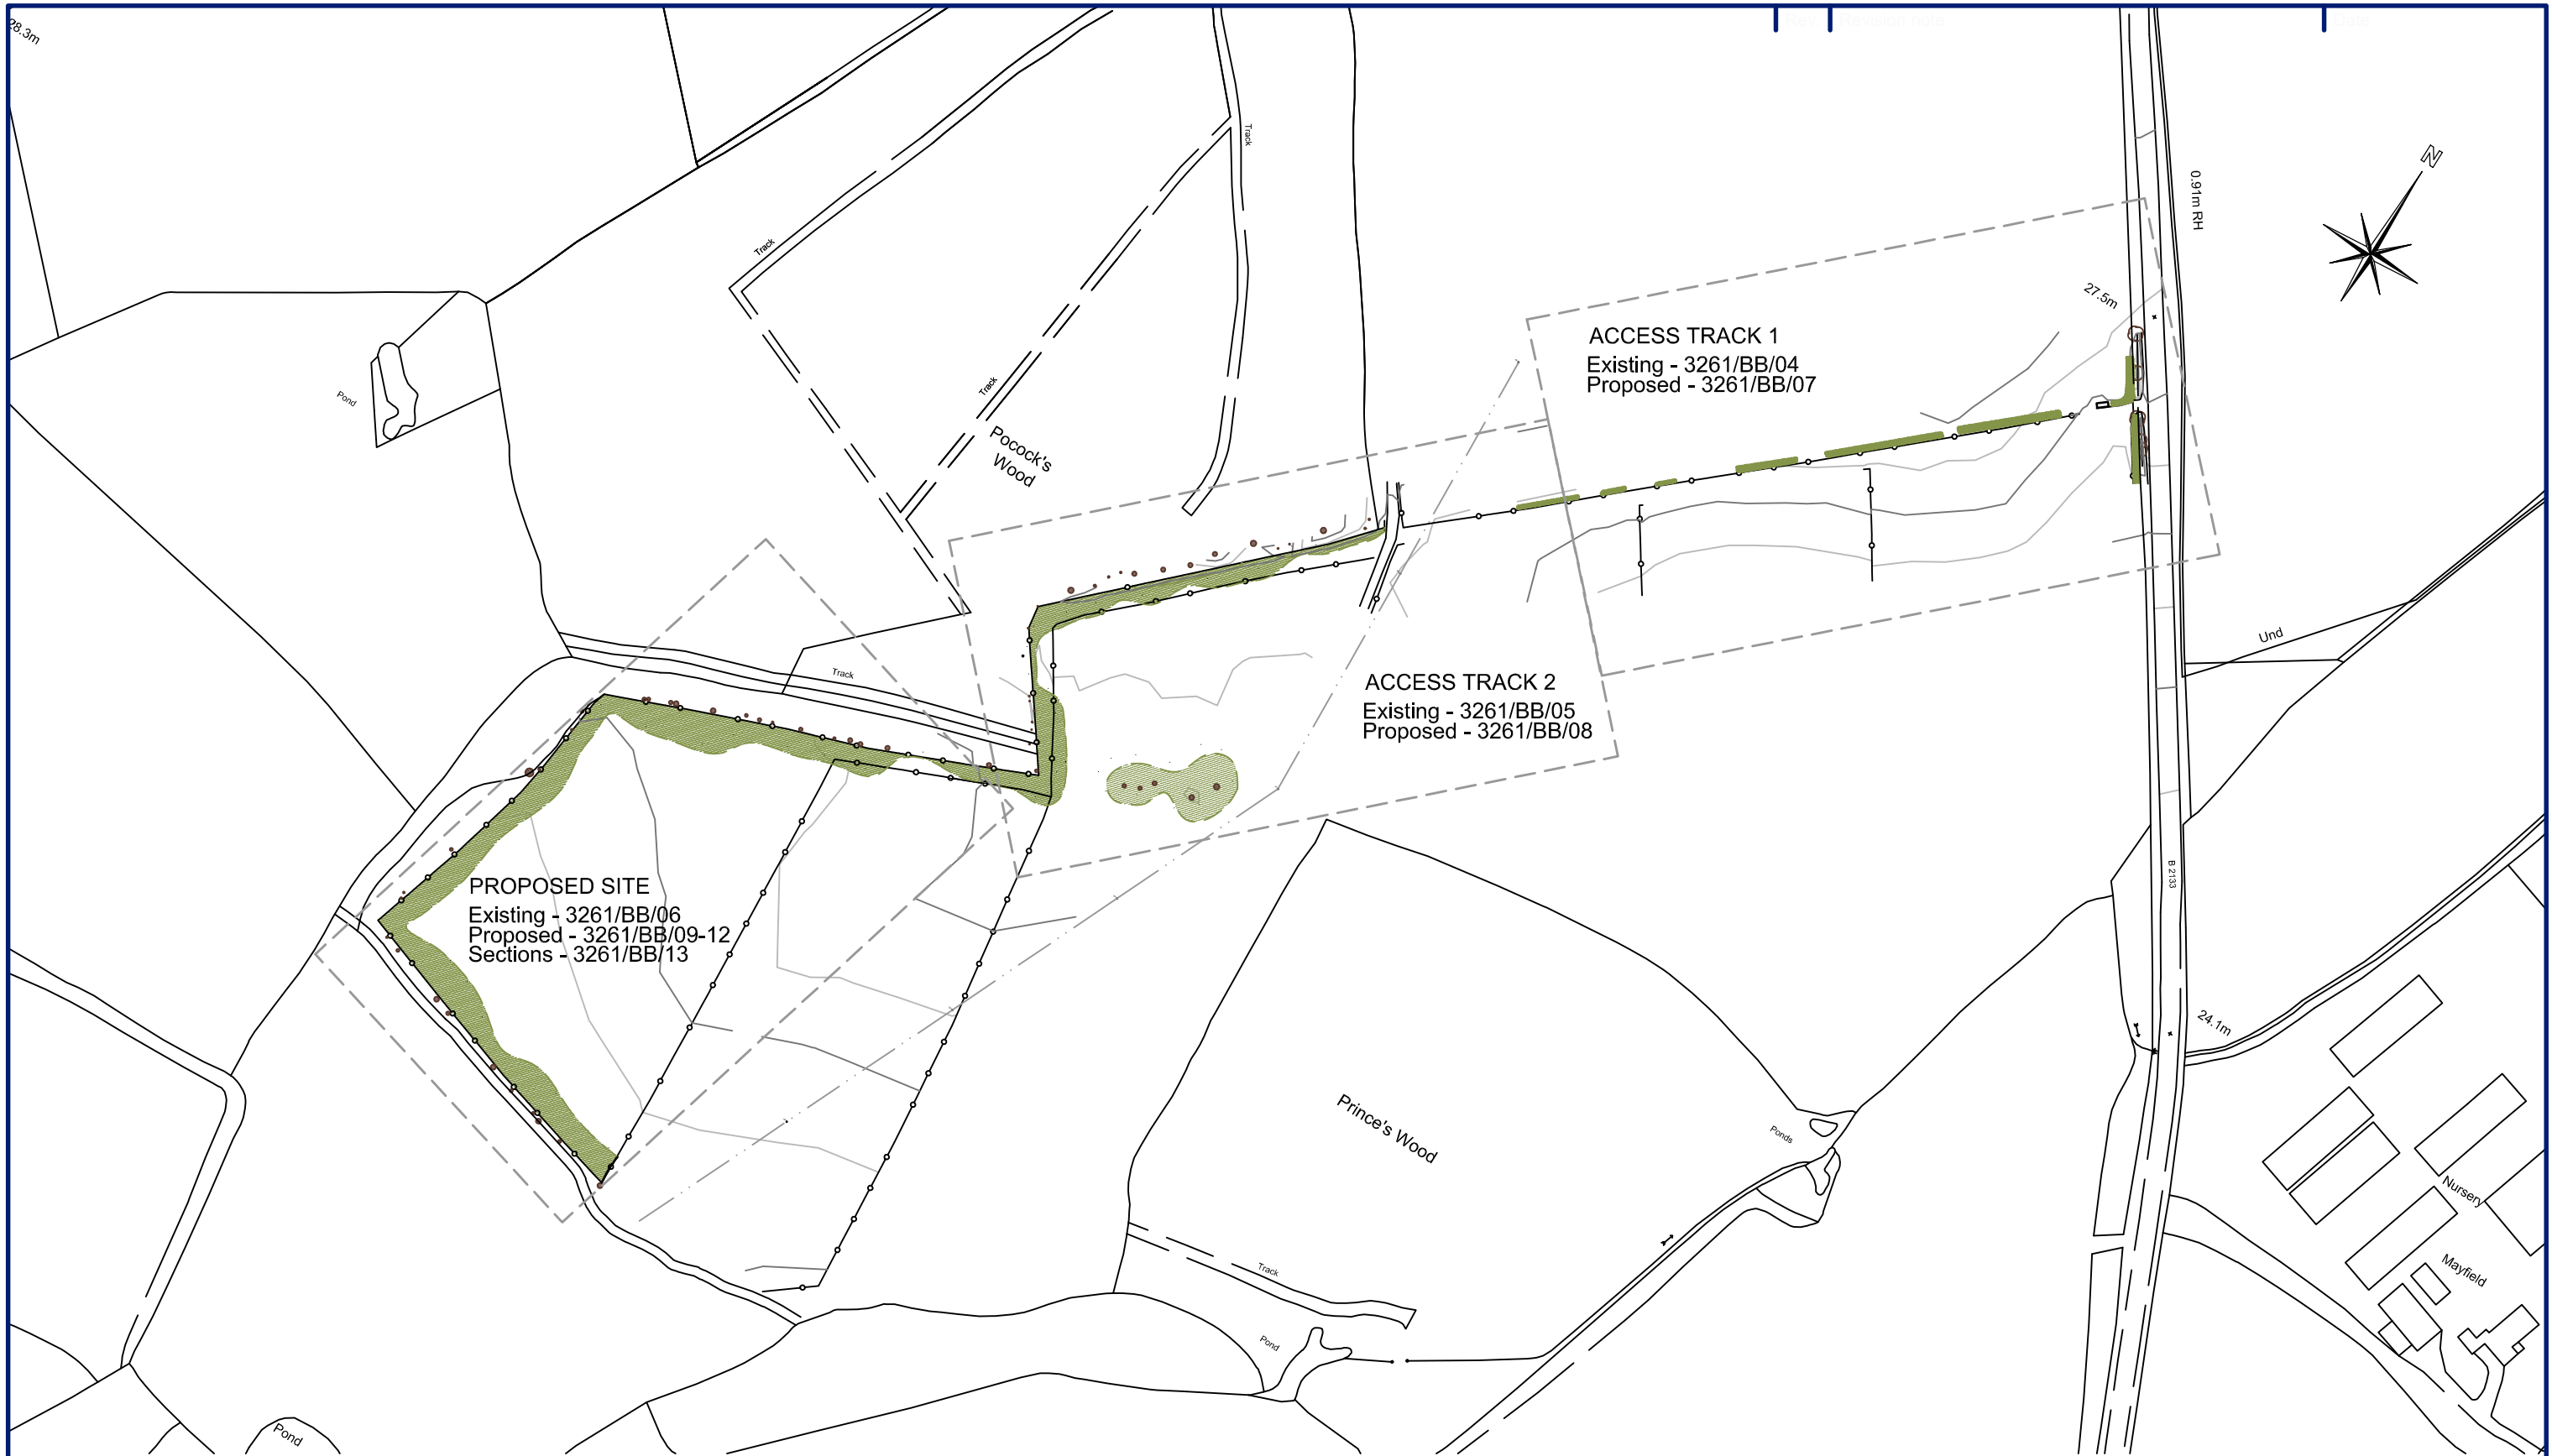

Orientation Plan of Site and Access Track

Scale 1:2000






**R ELLIOTT ASSOCIATES LTD**  
 CONSULTING STRUCTURAL & CIVIL ENGINEERS


t: (01590) 683176 f: (01590) 683533 info@rea-ltd.co.uk www.rea-ltd.co.uk



Dennett House  
 Brighton Road  
 Sway  
 Lymington  
 Hampshire  
 SO41 6EB


Client	Celtique Energie Petroleum Broadford Bridge West Sussex	Drawn By	AJNE	Date	February 2012	Sheet Size	A3
Job Title	Broadford Bridge Site	Drawing Title				Orientation Plan of Site and Access (1:2,000)	
		Drawing Number	3261/BB/03			Revision	

-  Hedge
-  Tree Canopy
-  Tree Positions
-  Contours
-  Fence

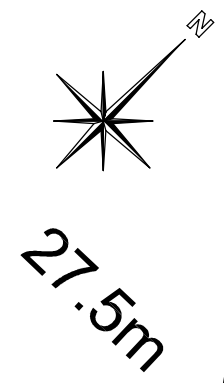

**Access Track 1 - Existing Field Entrance**

 Scale 1:500



**R ELLIOTT ASSOCIATES LTD**  
 CONSULTING STRUCTURAL & CIVIL ENGINEERS






t: (01590) 683176    f: (01590) 683533    info@rea-ltd.co.uk    www.rea-ltd.co.uk



Dennett House  
 Brighton Road  
 Sway  
 Lymington  
 Hampshire  
 SO41 6EB


Client Celtique Energie Petroleum Broadford Bridge West Sussex	Drawn By AJNE	Date August 2012	Sheet Size A3
	Drawing Title Access Track 1 - Existing Site Entrance (1:500)		
Job Title Broadford Bridge Site	Drawing Number 3261/BB/04	Revision A	

 

-  Hedge
-  Tree Canopy
-  Tree Positions
-  Contours
-  Fence

**Access Track 2 - Existing Ground Plan**

 Scale 1:500




**R ELLIOTT ASSOCIATES LTD**  
 CONSULTING STRUCTURAL & CIVIL ENGINEERS

t: (01590) 683176 f: (01590) 683533 info@rea-ltd.co.uk www.rea-ltd.co.uk




Dennett House  
 Brighton Road  
 Sway  
 Lymington  
 Hampshire  
 SO41 6EB

Client	Celtique Energie Petroleum Broadford Bridge West Sussex	Drawn By	AJNE	Date	August 2012	Sheet Size	A3	
Job Title	Broadford Bridge Site	Drawing Title	Access Track 2 - Existing Ground Plan (1:500)				Revision	A
		Drawing Number	3261/BB/05					

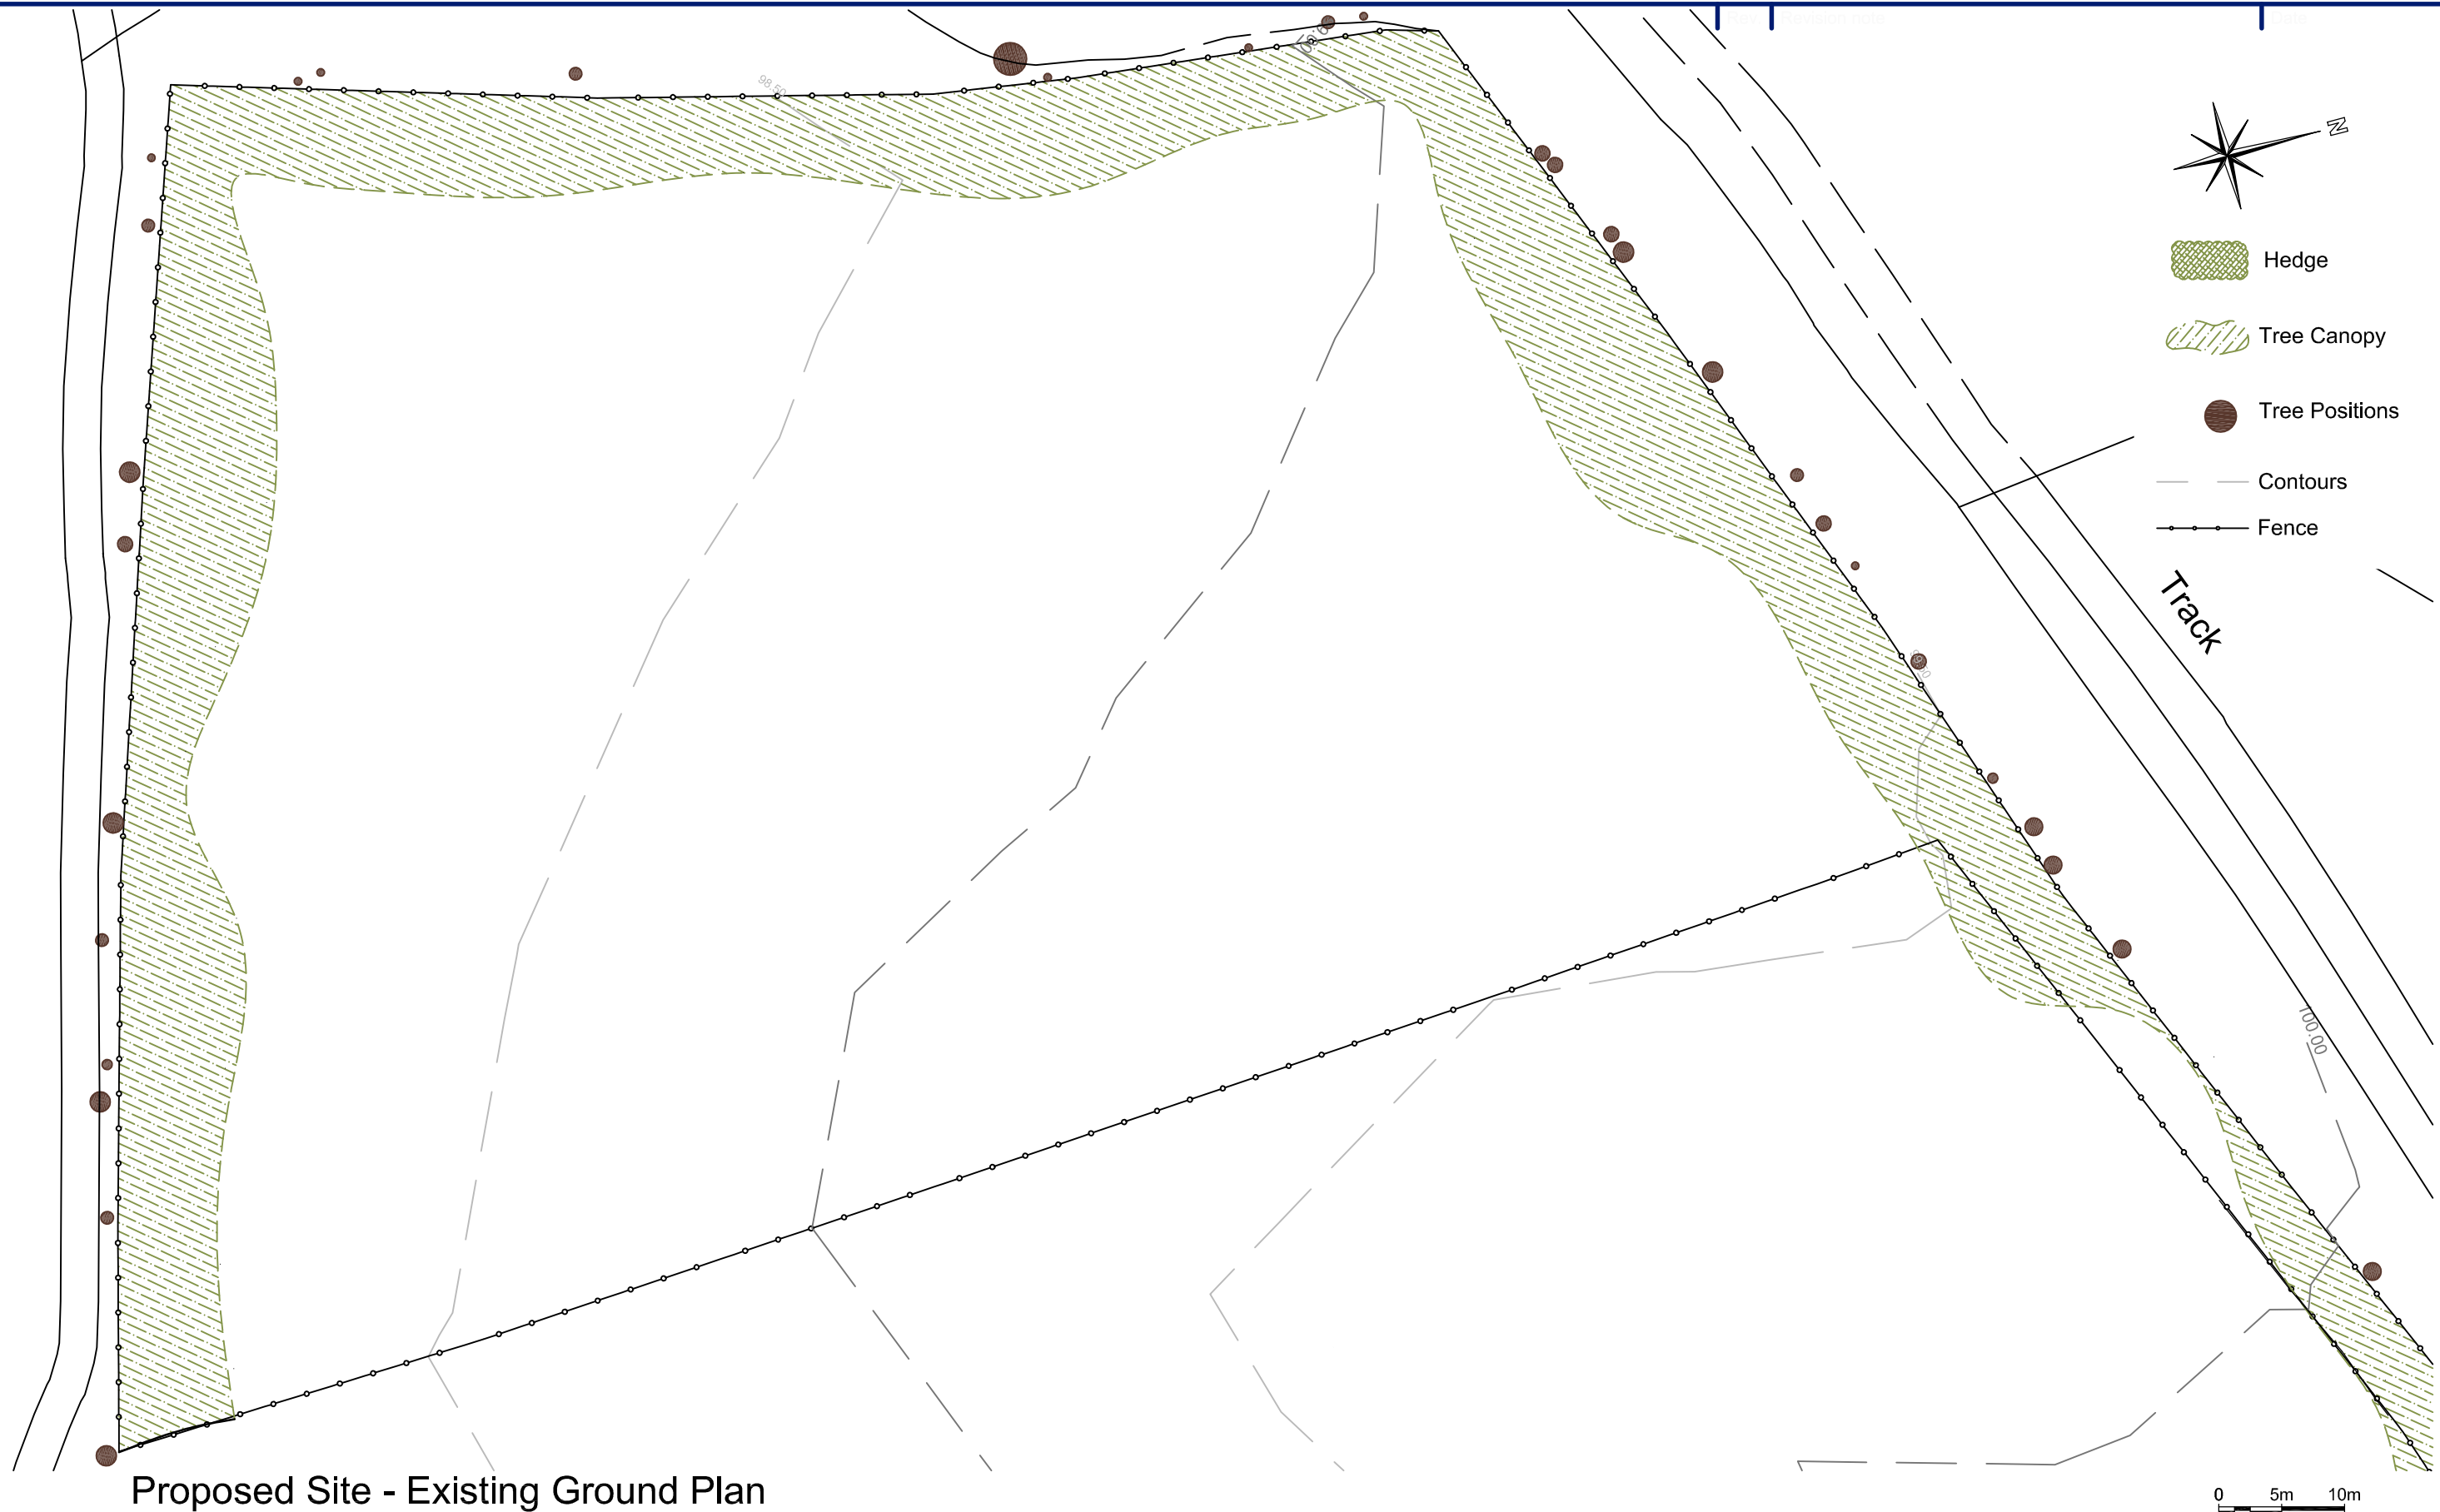


Proposed Site - Existing Ground Plan

 Scale 1:500



**R ELLIOTT ASSOCIATES LTD**  
 CONSULTING STRUCTURAL & CIVIL ENGINEERS

t: (01590) 683176 f: (01590) 683533 info@rea-ltd.co.uk www.rea-ltd.co.uk

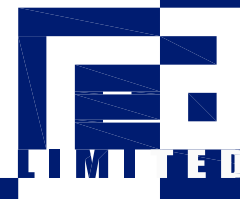



 



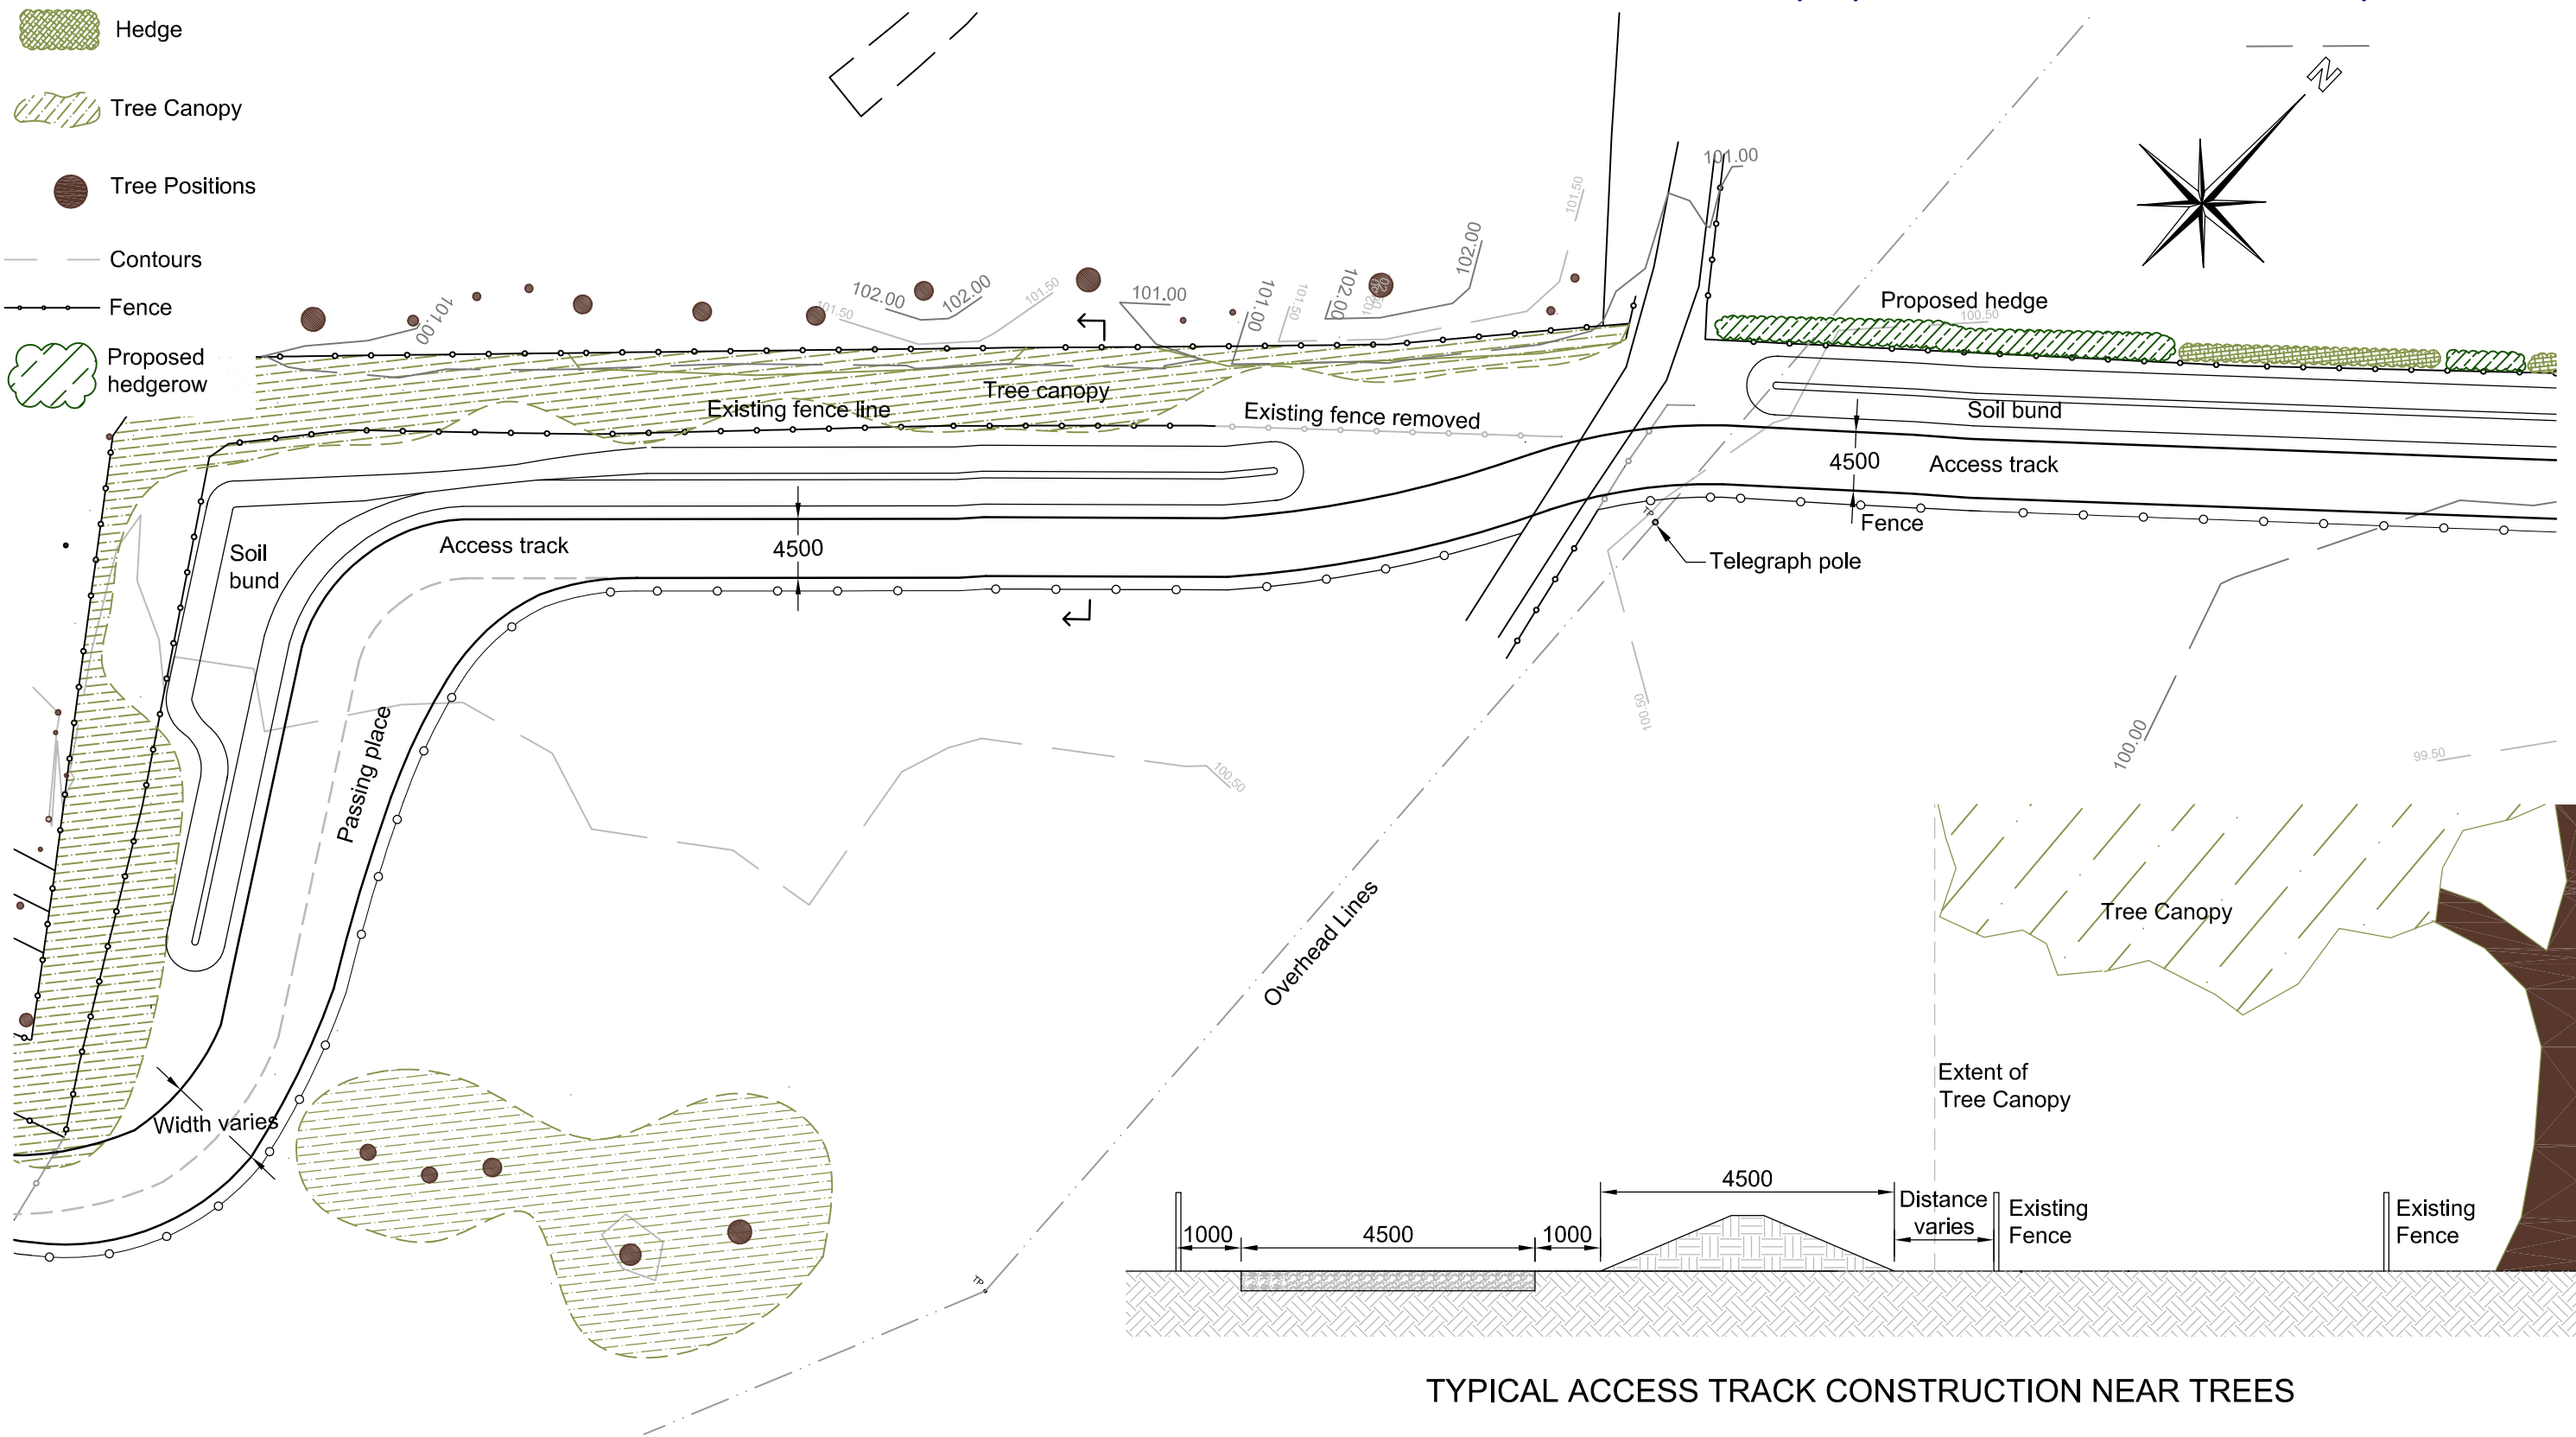
Dennett House  
 Brighton Road  
 Sway  
 Lymington  
 Hampshire  
 SO41 6EB

Client Celtique Energie Petroleum Broadford Bridge West Sussex	Drawn By AJNE	Date August 2012	Sheet Size A3
	Drawing Title Proposed Site - Existing Ground Plan (1:500)		
Job Title Broadford Bridge Site	Drawing Number 3261/BB/06	Revision A	

 




-  Hedge
-  Tree Canopy
-  Tree Positions
-  Contours
-  Fence
-  Proposed hedgerow



**Proposed Access Track**  
Scale 1:500




**R ELLIOTT ASSOCIATES LTD**  
CONSULTING STRUCTURAL & CIVIL ENGINEERS

t: (01590) 683176 f: (01590) 683533 info@rea-ltd.co.uk www.rea-ltd.co.uk



Dennett House  
Brighton Road  
Sway  
Lymington  
Hampshire  
SO41 6EB

Client	Celtique Energie Petroleum Broadford Bridge West Sussex	Drawn By	AJNE	Date	August 2012	Sheet Size	A3	
Job Title	Broadford Bridge Site	Drawing Title	Access Track 2 - Proposed Layout (1:500)				Revision	B
		Drawing Number	3261/BB/08					

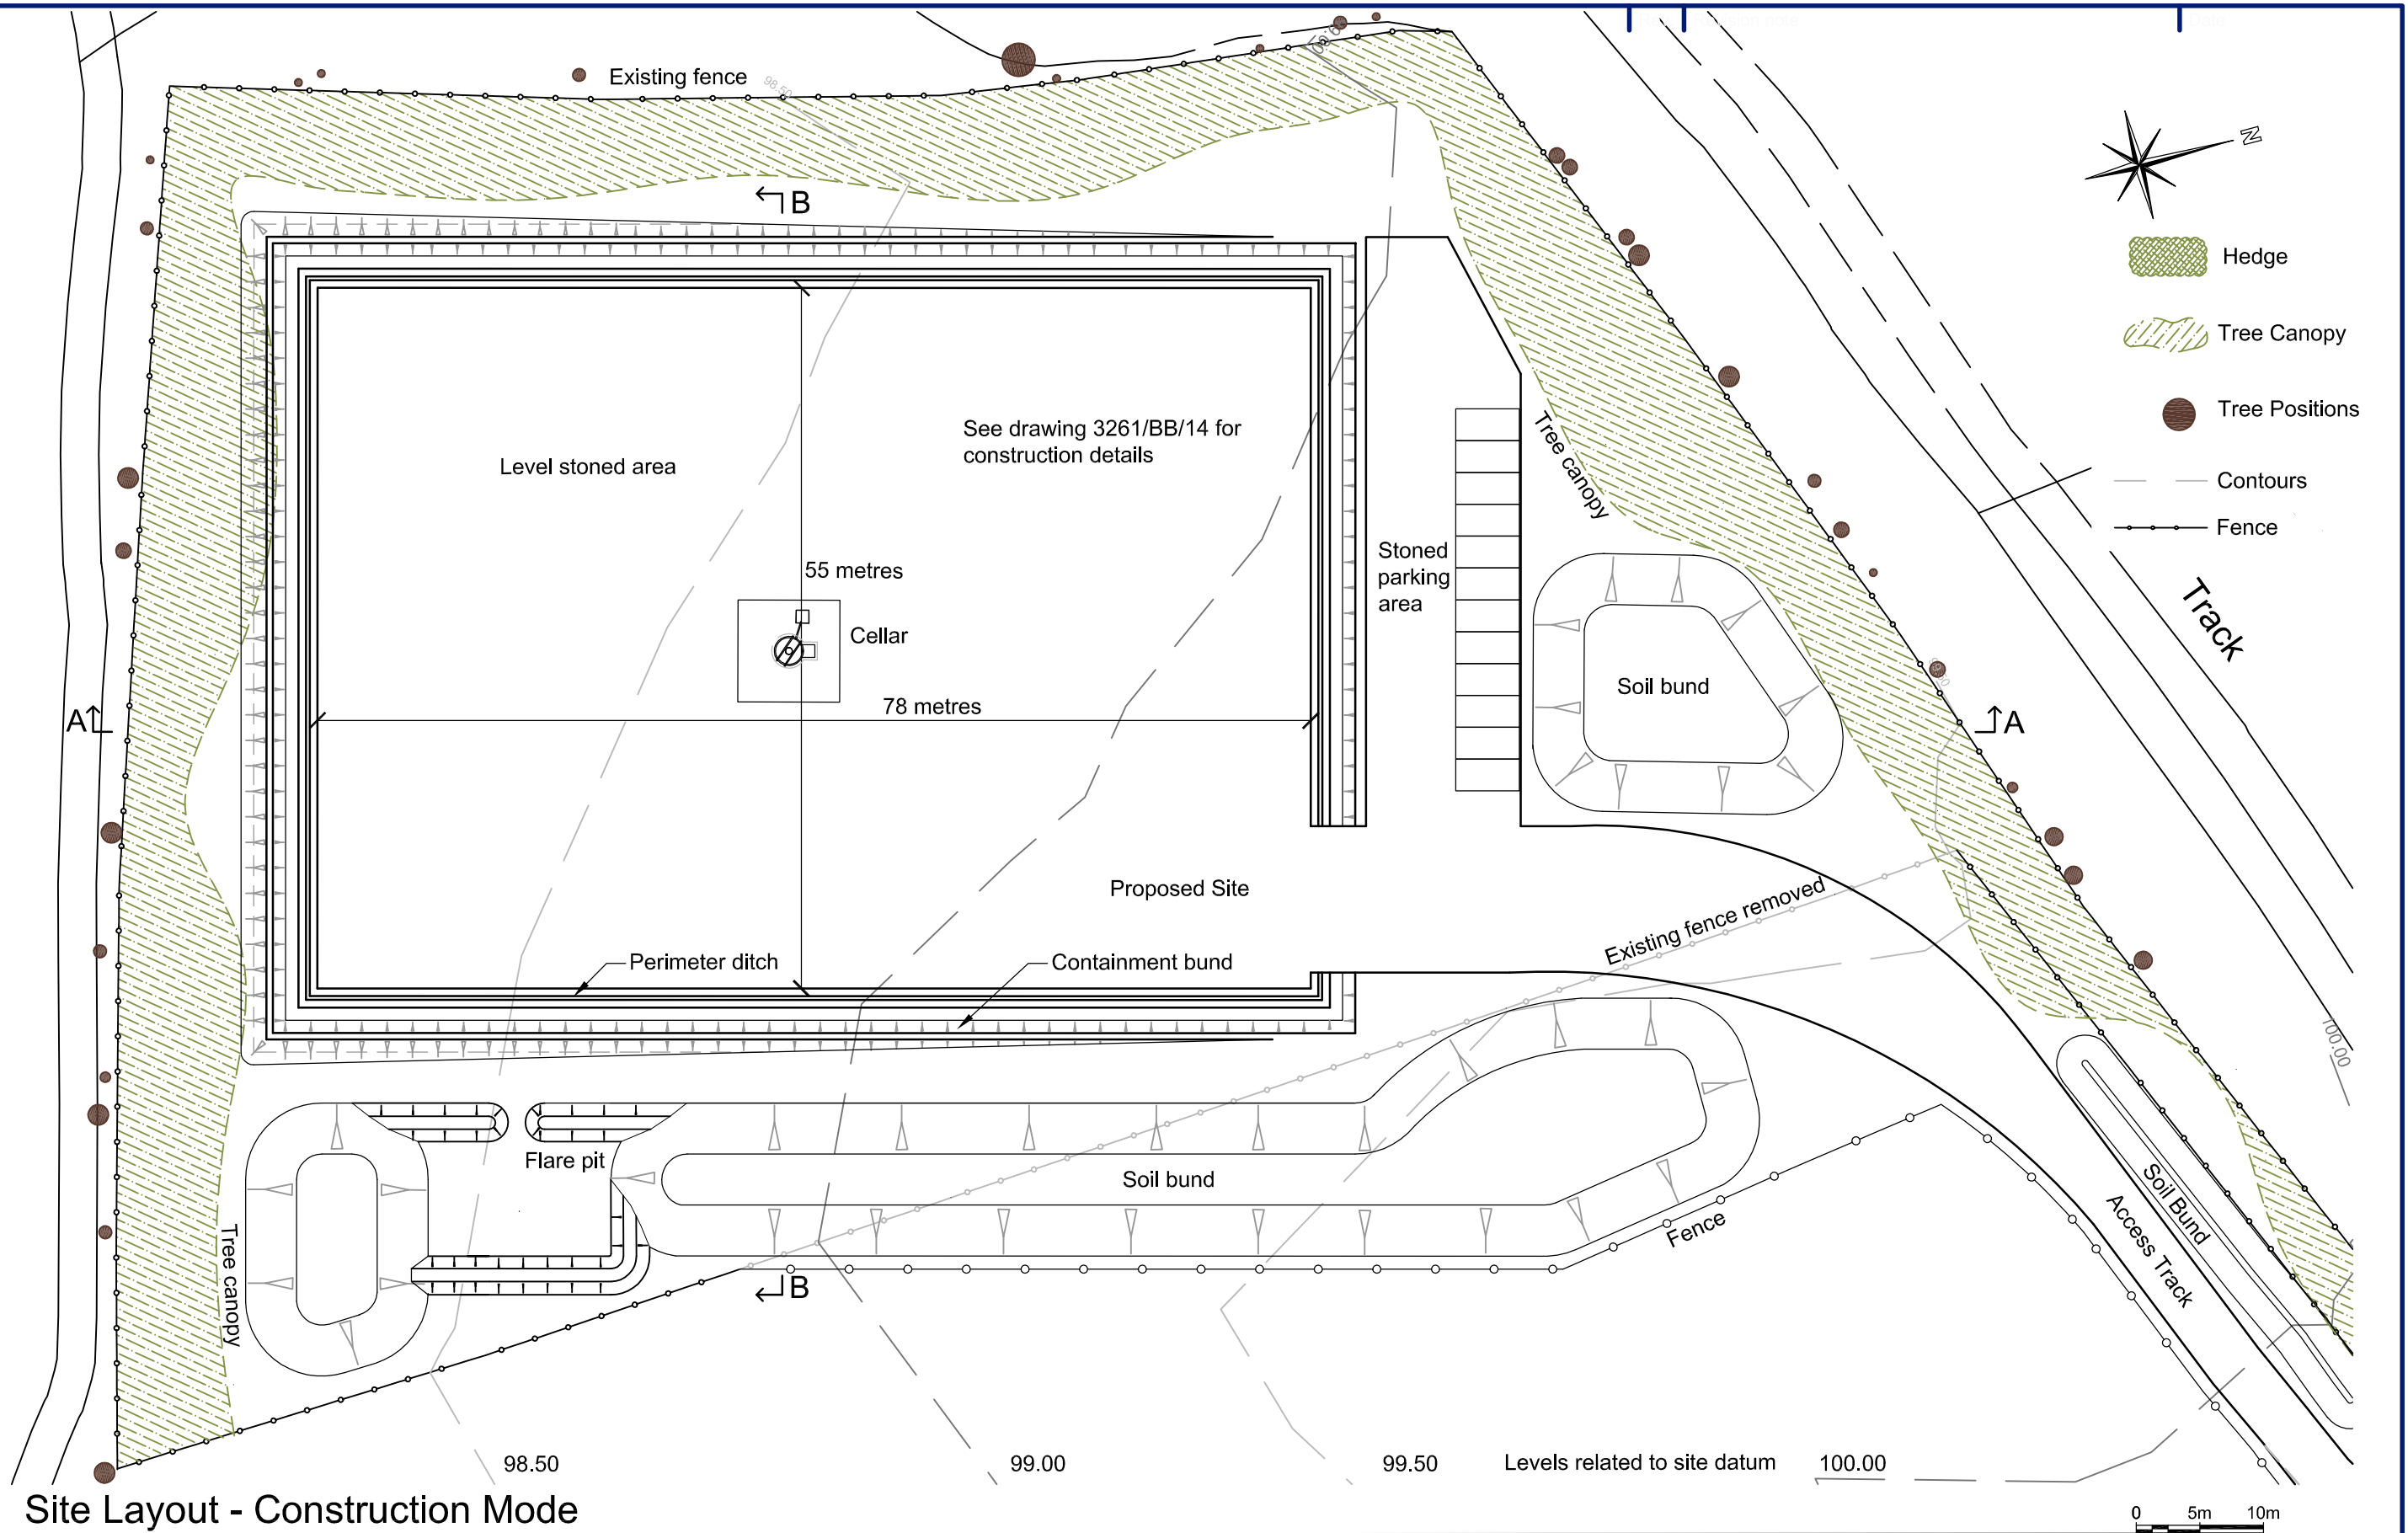

Site Layout - Construction Mode

Scale 1:500


**R ELLIOTT ASSOCIATES LTD**  
 CONSULTING STRUCTURAL & CIVIL ENGINEERS

t: (01590) 683176 f: (01590) 683533 info@rea-ltd.co.uk www.rea-ltd.co.uk



Dennett House  
 Brighton Road  
 Sway  
 Lymington  
 Hampshire  
 SO41 6EB

Client	Celtique Energie Petroleum Broadford Bridge West Sussex	Drawn By	AJNE	Date	August 2012	Sheet Size	A3
Job Title	Broadford Bridge Site	Drawing Title	Site Layout - Construction Mode (1:500)			Revision	A
		Drawing Number	3261/BB/09				

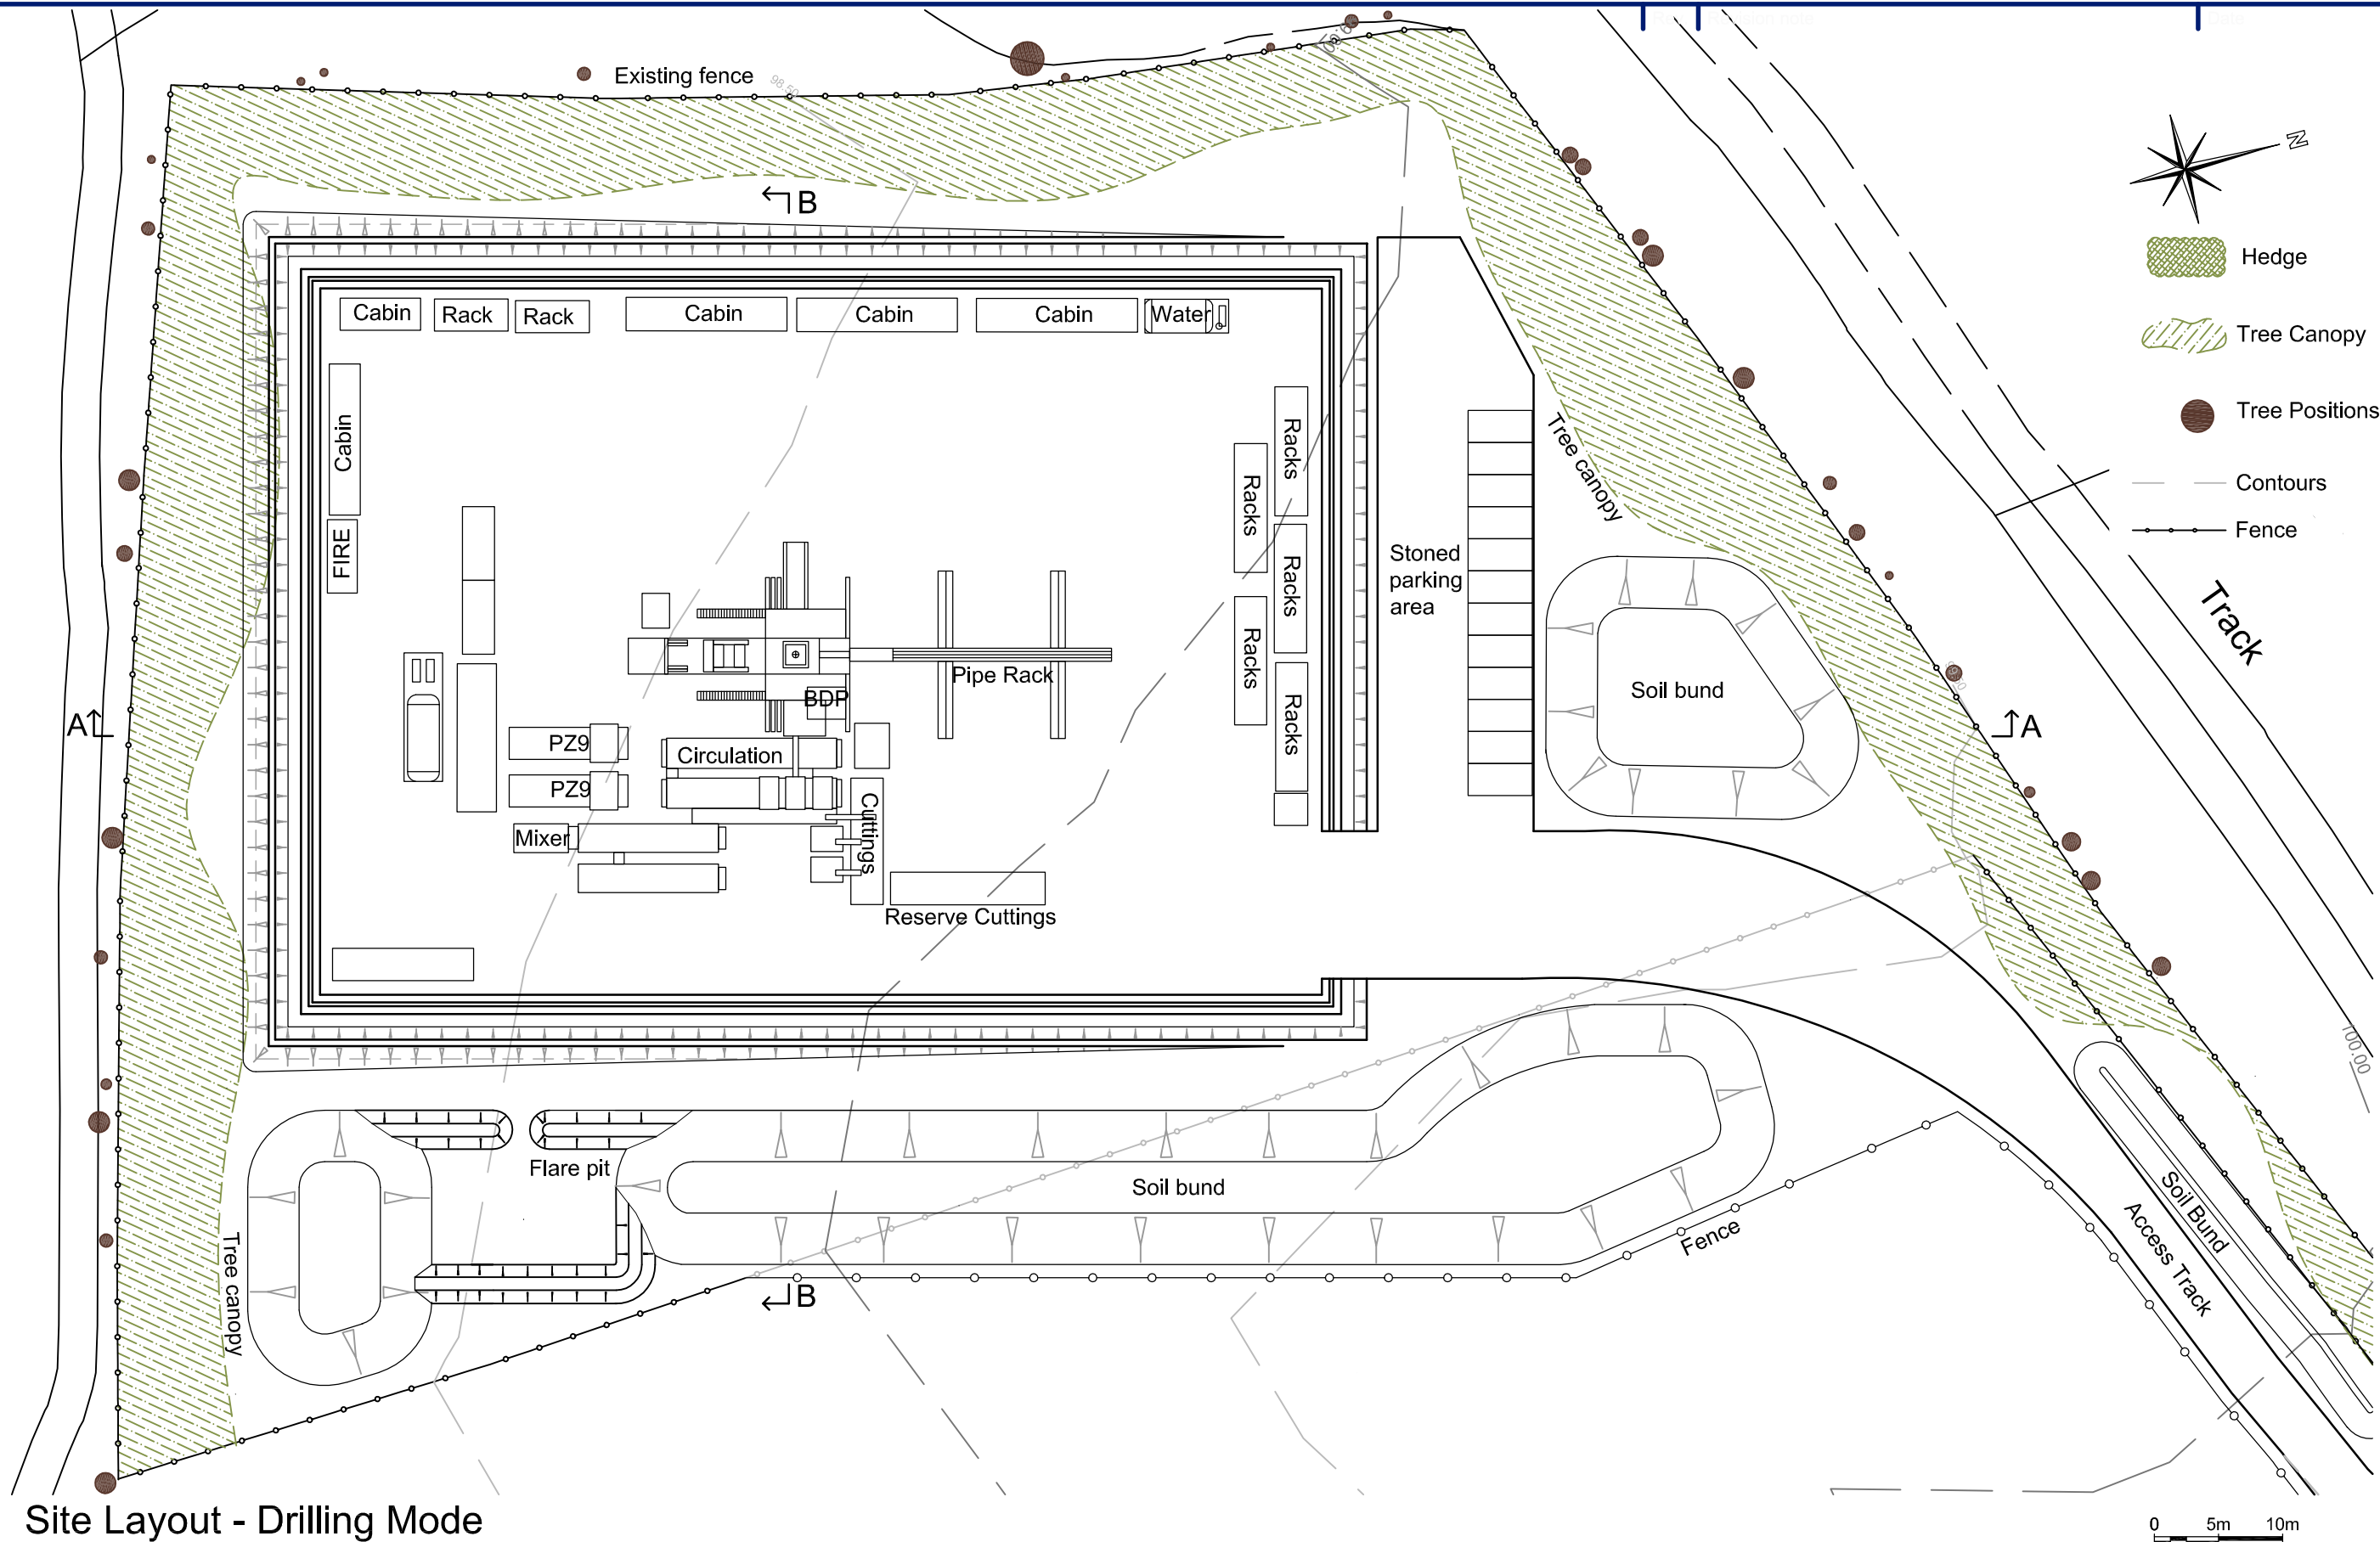

Site Layout - Drilling Mode

Scale 1:500

0 5m 10m


**R ELLIOTT ASSOCIATES LTD**  
 CONSULTING STRUCTURAL & CIVIL ENGINEERS

t: (01590) 683176 f: (01590) 683533 info@rea-ltd.co.uk www.rea-ltd.co.uk



Dennett House  
 Brighton Road  
 Sway  
 Lymington  
 Hampshire  
 SO41 6EB

Client	Celtique Energie Petroleum Broadford Bridge West Sussex	Drawn By	AJNE	Date	August 2012	Sheet Size	A3	
Job Title	Broadford Bridge Site	Drawing Title	Site Layout - Drilling Mode (1:500)				Revision	A
		Drawing Number	3261/BB/10					

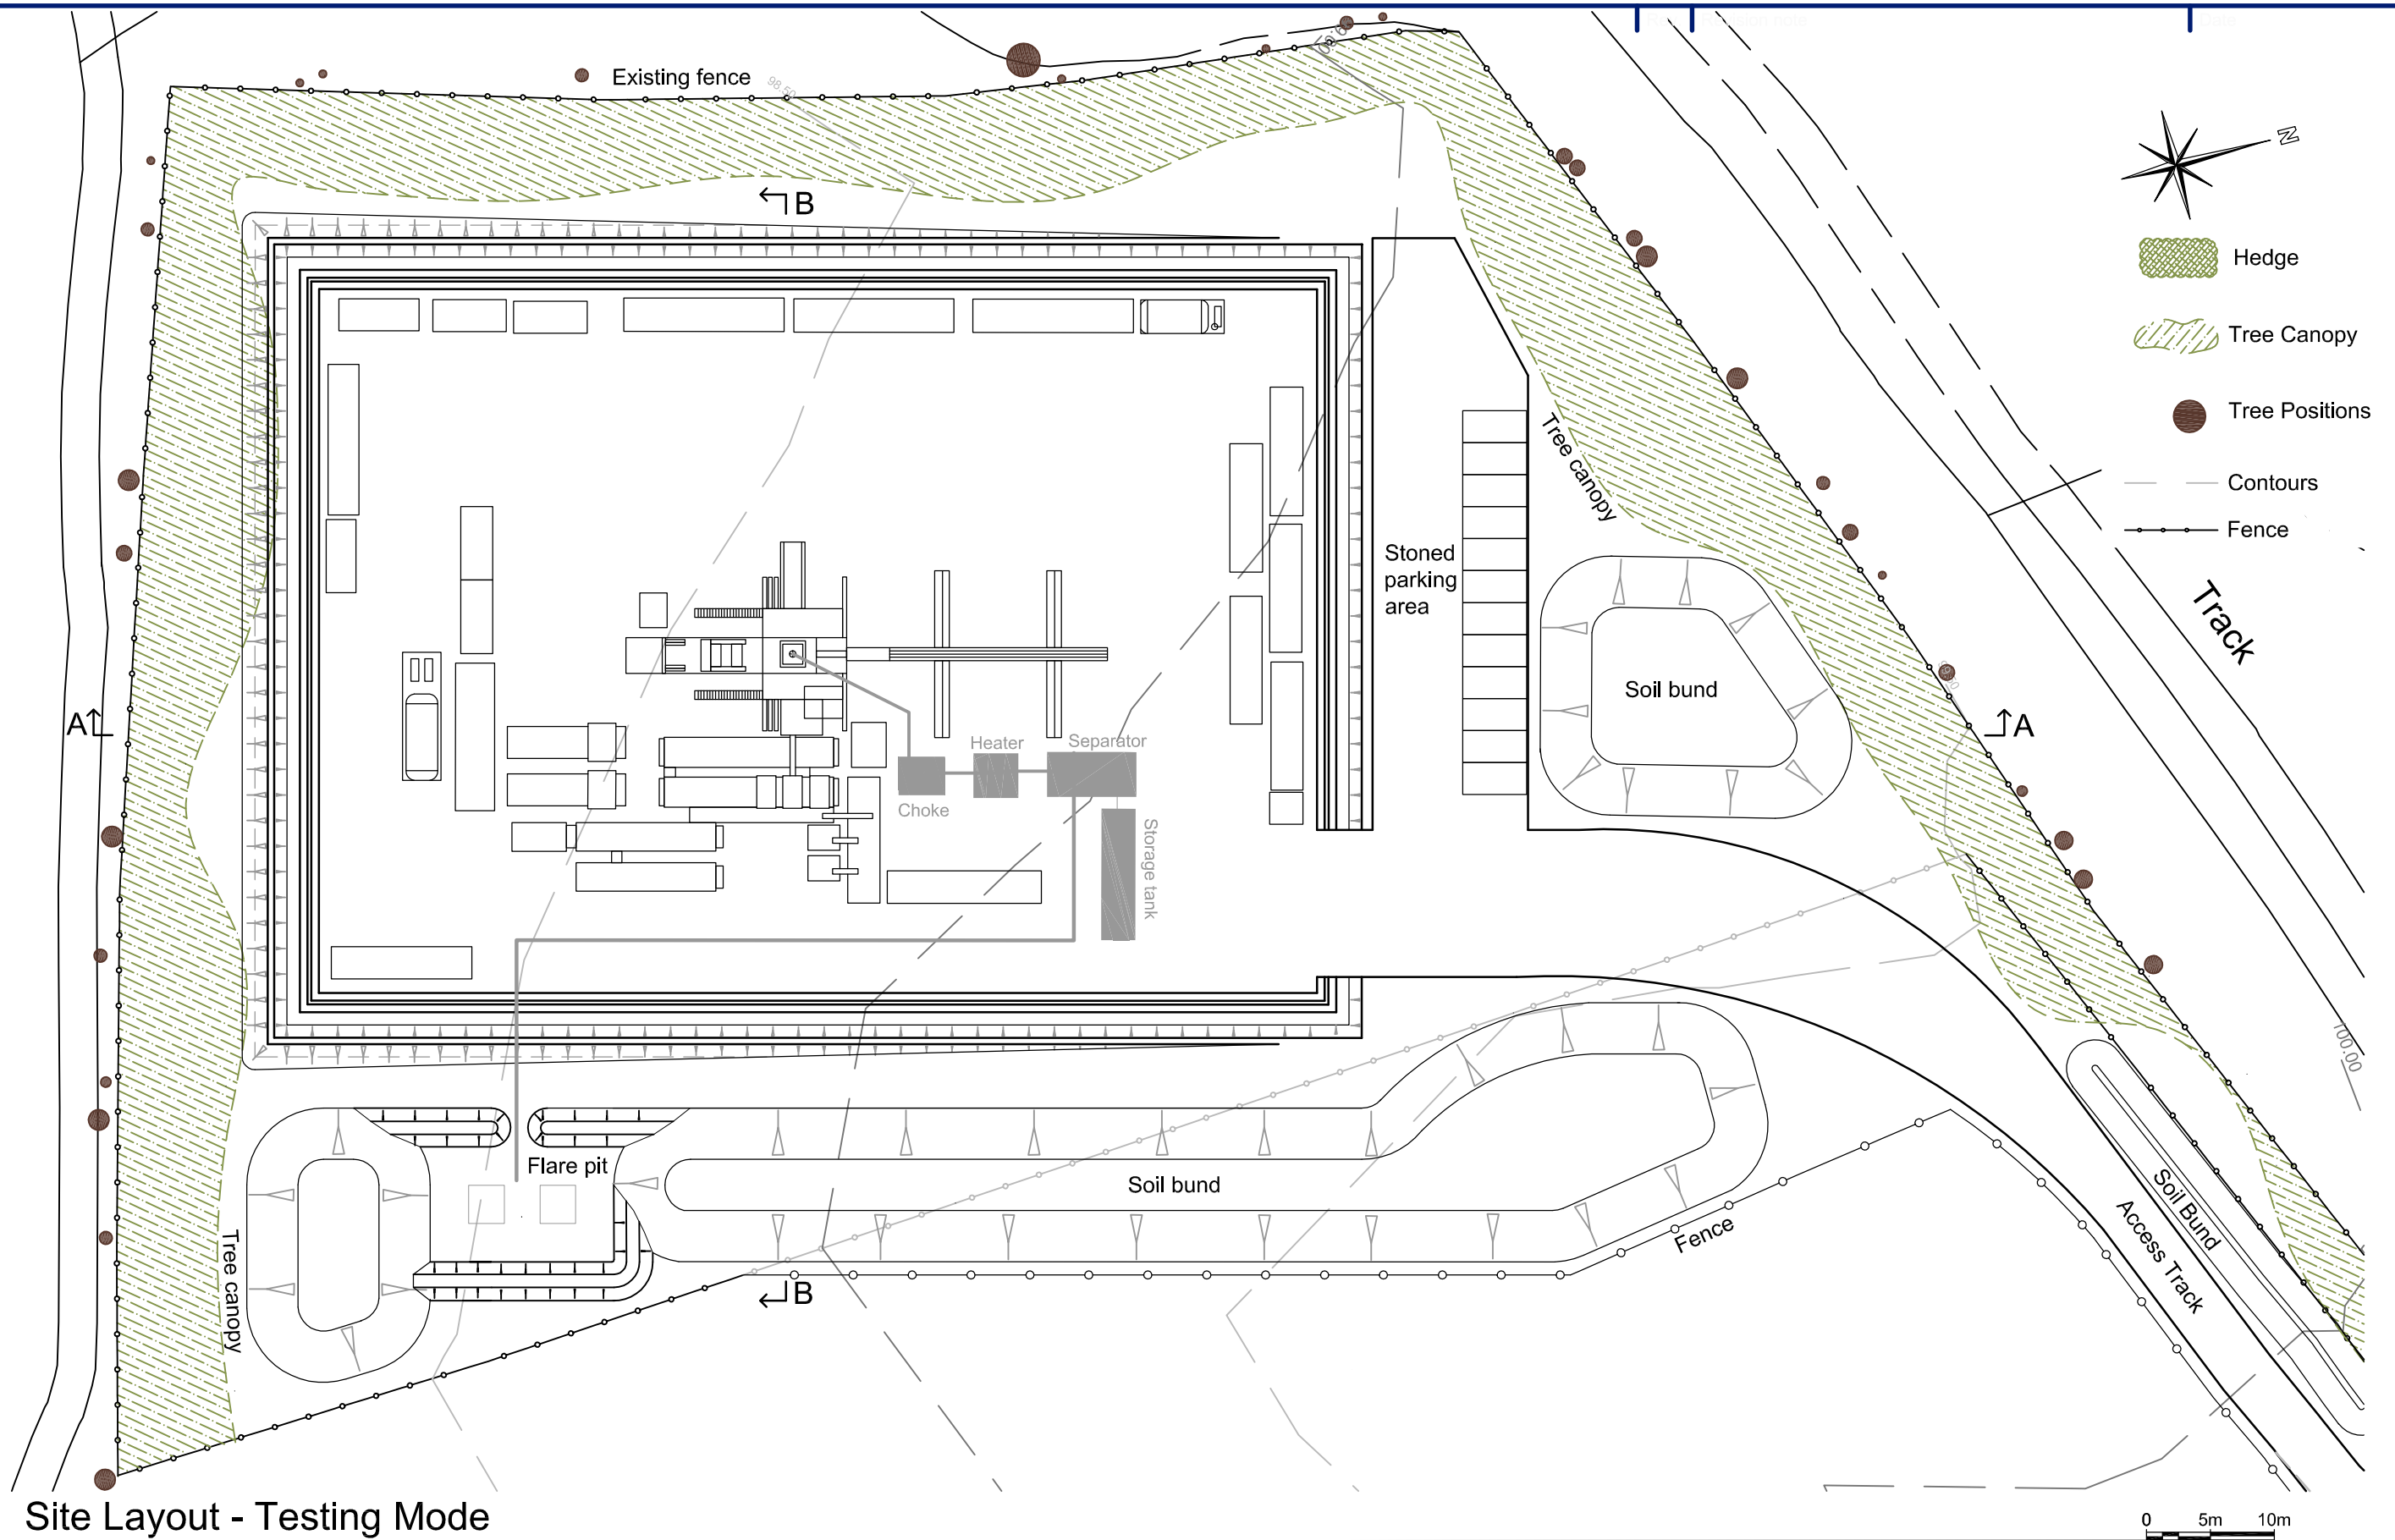

Site Layout - Testing Mode

Scale 1:500


**R ELLIOTT ASSOCIATES LTD**  
 CONSULTING STRUCTURAL & CIVIL ENGINEERS

t: (01590) 683176 f: (01590) 683533 info@rea-ltd.co.uk www.rea-ltd.co.uk



Dennett House  
 Brighton Road  
 Sway  
 Lymington  
 Hampshire  
 SO41 6EB

Client	Celtique Energie Petroleum Broadford Bridge West Sussex	Drawn By	AJNE	Date	August 2012	Sheet Size	A3
Job Title	Broadford Bridge Site	Drawing Title	Site Layout - Testing Mode (1:500)			Revision	A
		Drawing Number	3261/BB/11				

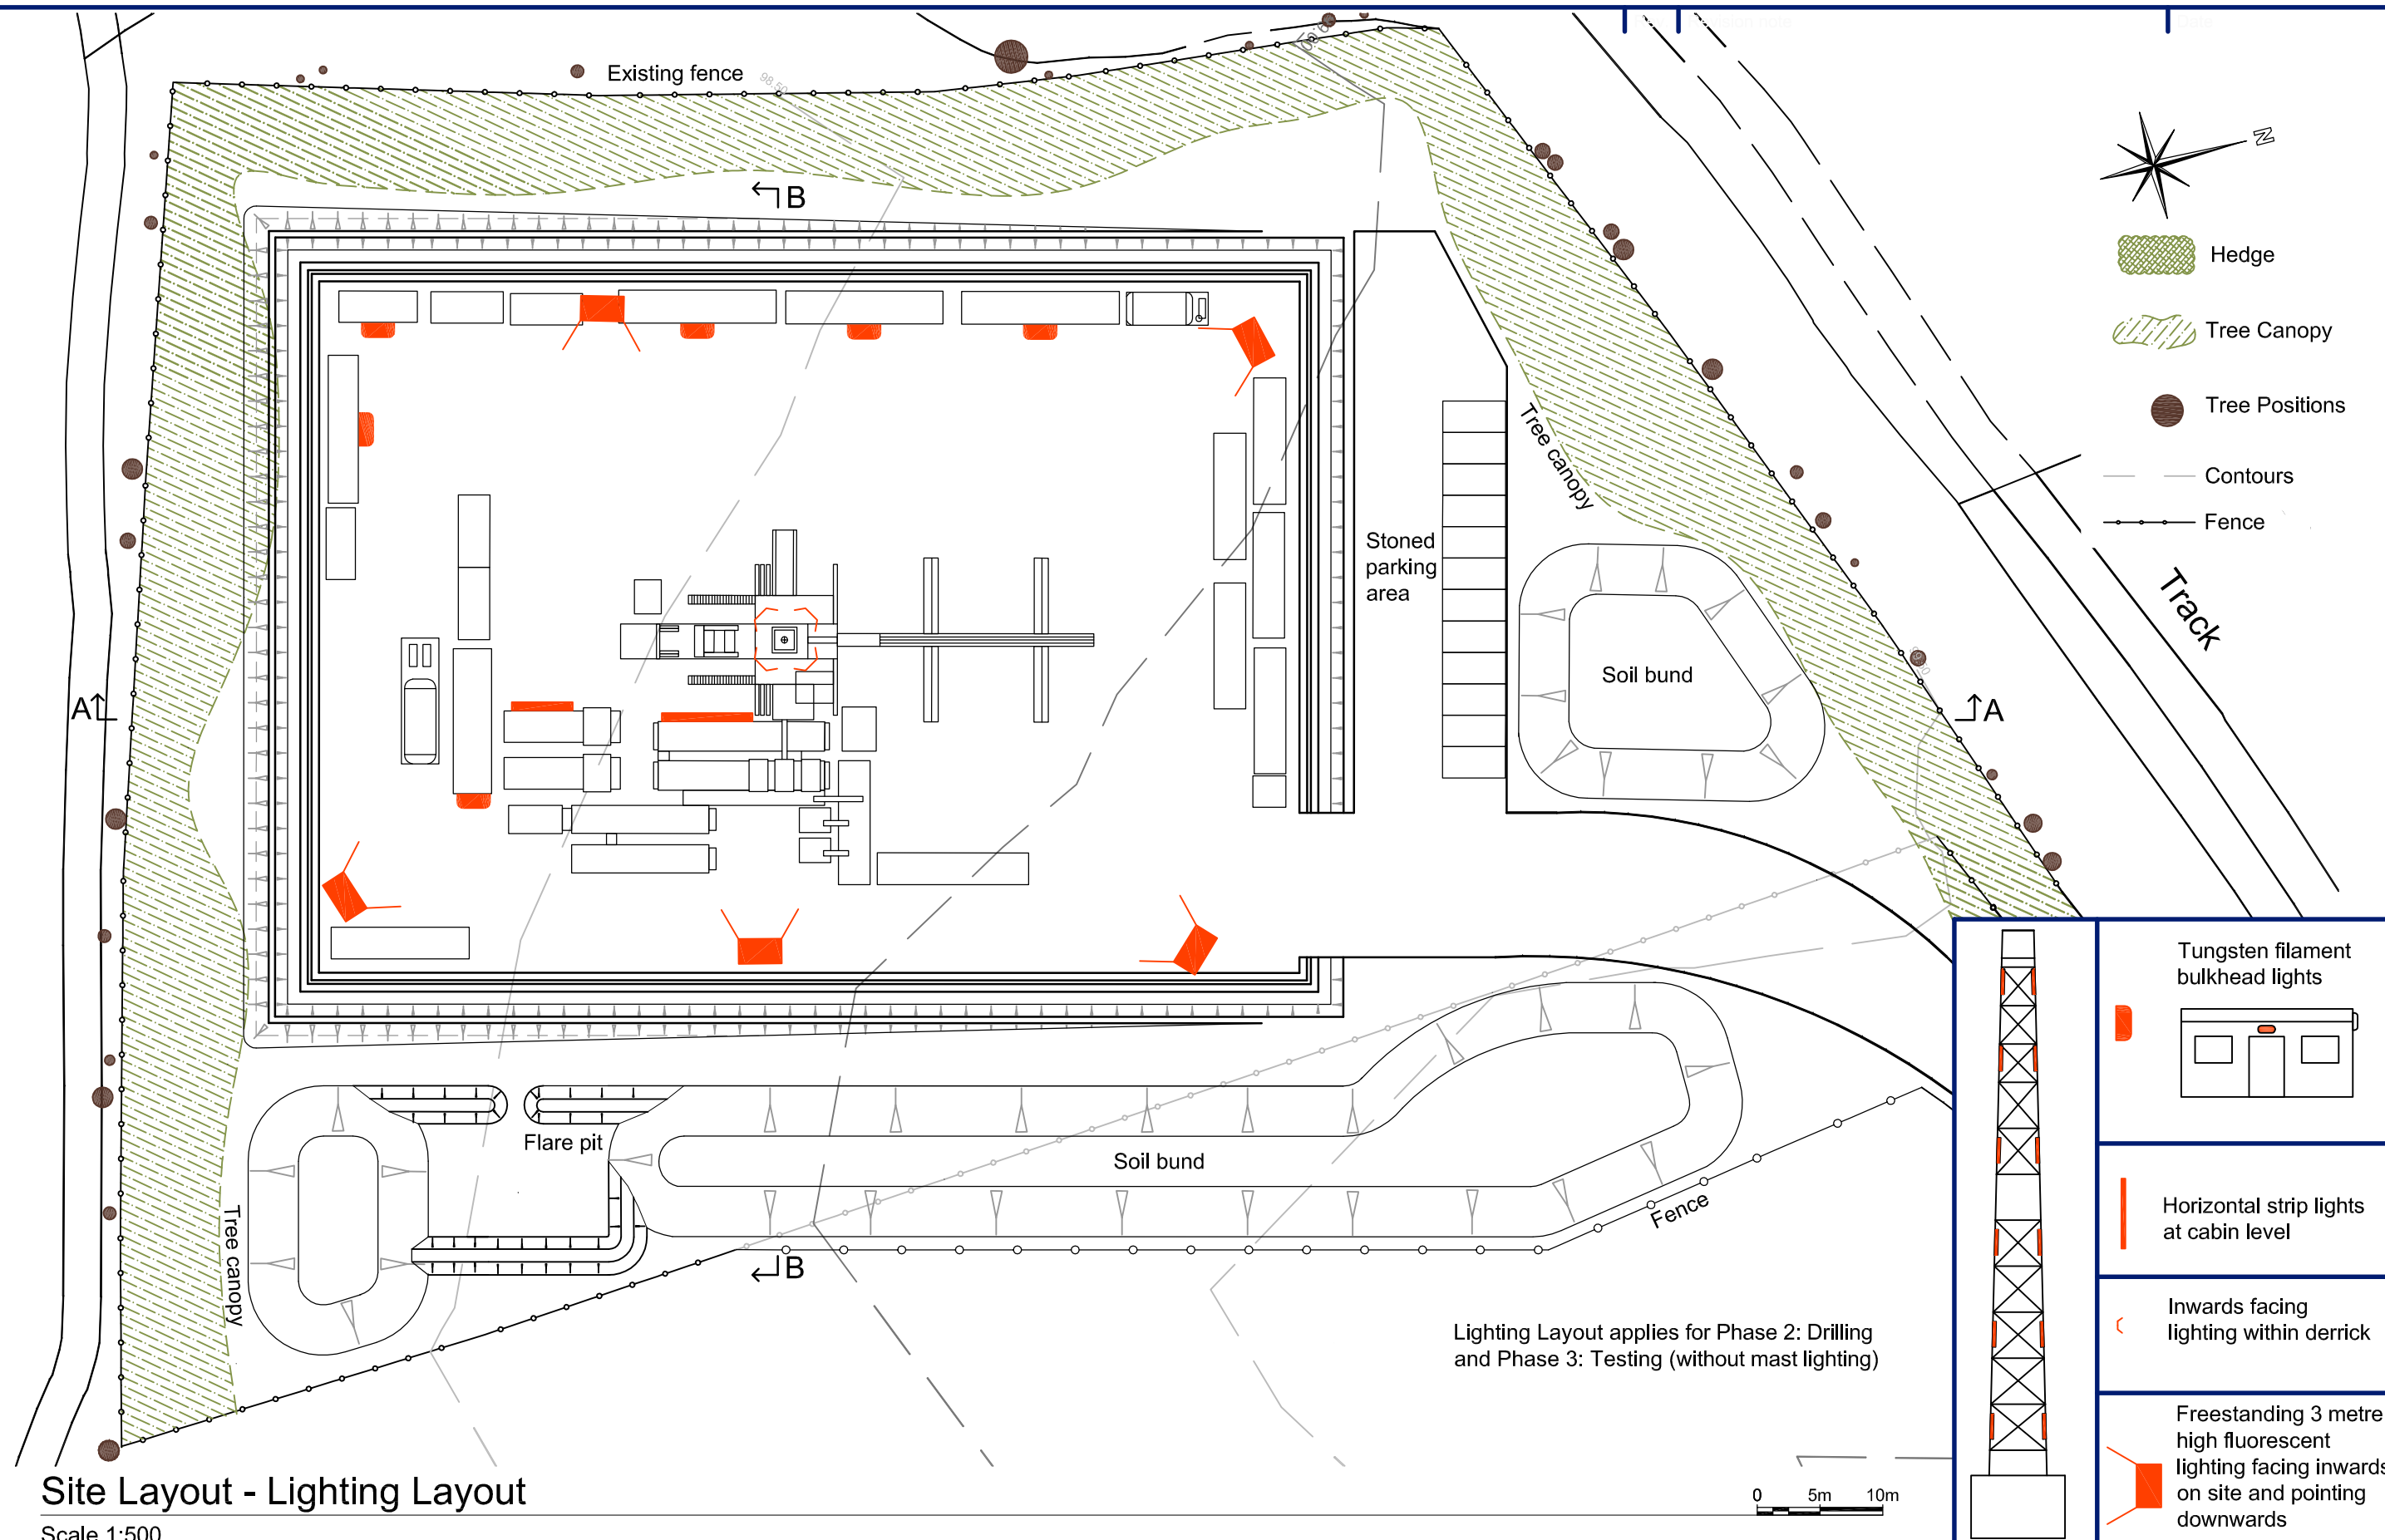

Site Layout - Lighting Layout

Scale 1:500

	<p>Tungsten filament bulkhead lights</p>
	<p>Horizontal strip lights at cabin level</p>
	<p>Inwards facing lighting within derrick</p>
	<p>Freestanding 3 metre high fluorescent lighting facing inwards on site and pointing downwards</p>

**R ELLIOTT ASSOCIATES LTD**  
 CONSULTING STRUCTURAL & CIVIL ENGINEERS

t: (01590) 683176 f: (01590) 683533 info@rea-ltd.co.uk www.rea-ltd.co.uk



Dennett House  
 Brighton Road  
 Sway  
 Lymington  
 Hampshire  
 SO41 6EB

Client: Celtique Energie Petroleum  
 Broadford Bridge  
 West Sussex

Job Title: Broadford Bridge Site

Drawn By: AJNE


Drawing Title: Site Layout - Lighting (1:500)

Drawing Number: 3261/BB/12

Date: August 2012



Sheet Size: A3

Revision: A

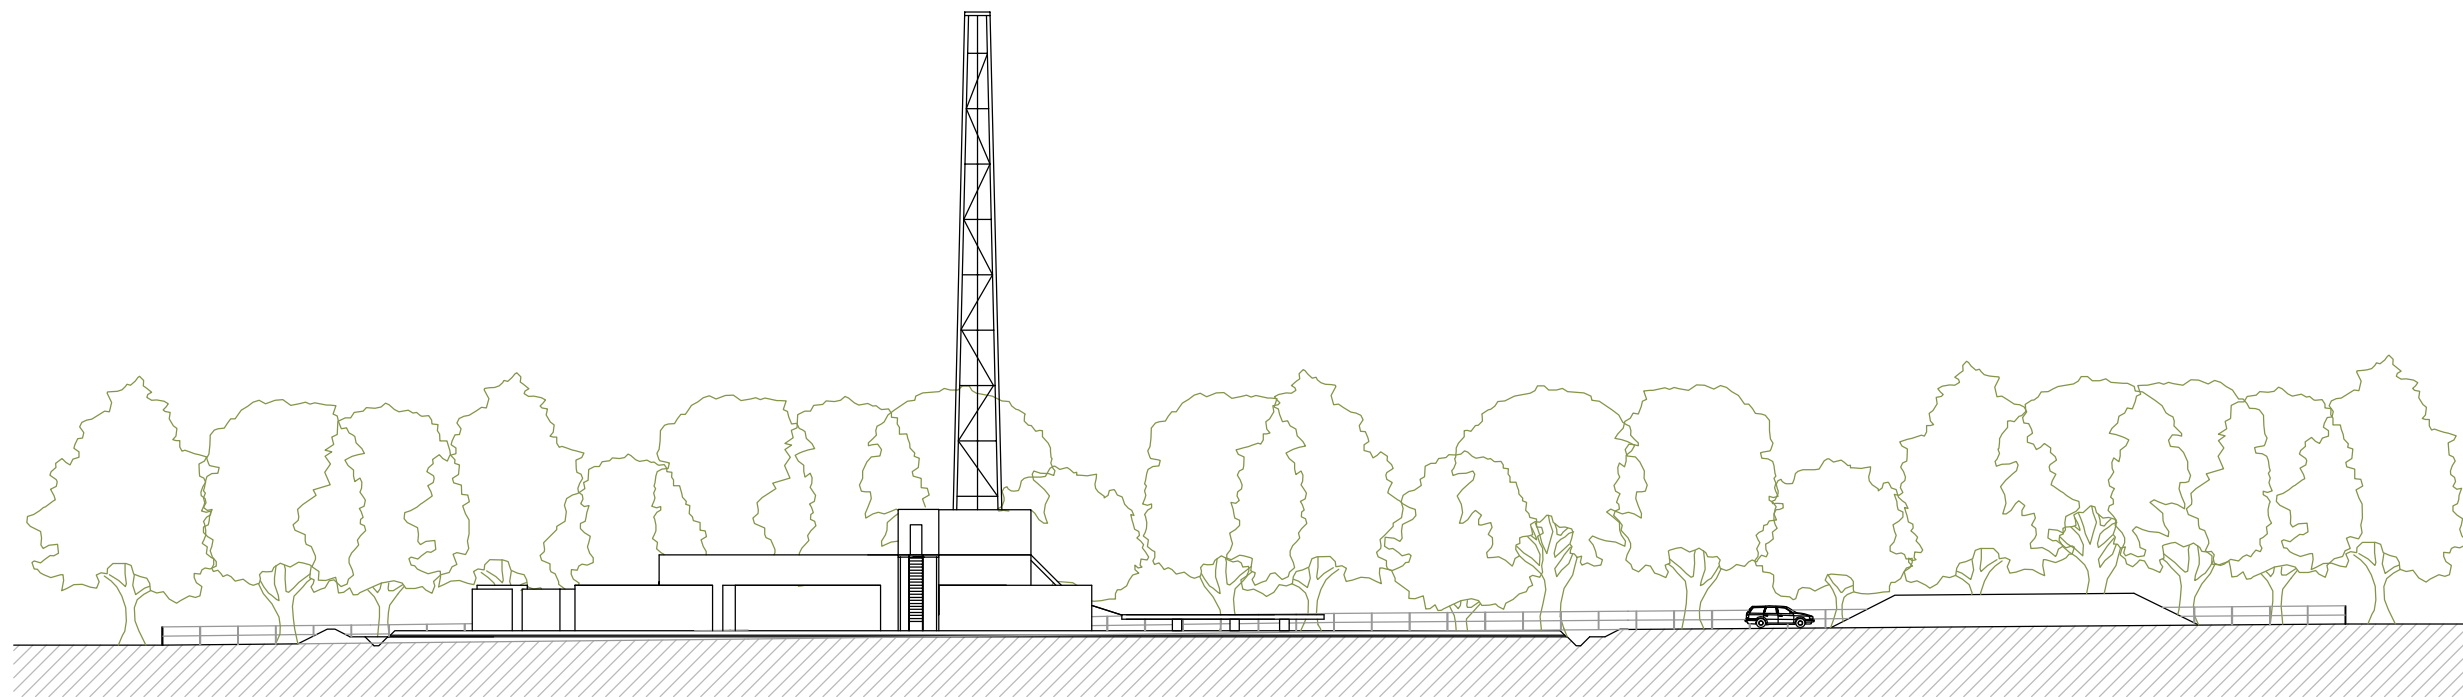



Section A-A

 Scale 1:500

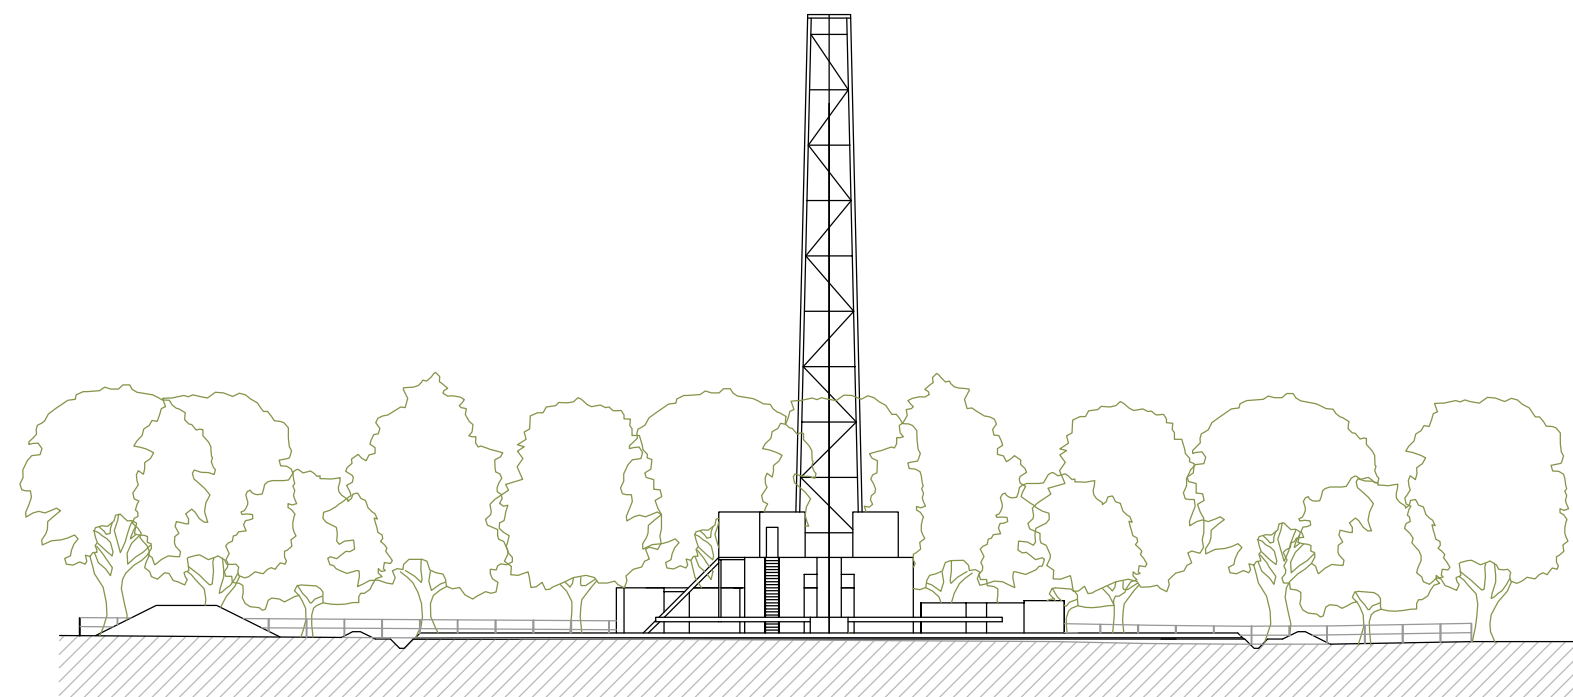

Section B-B

 
Scale 1:500

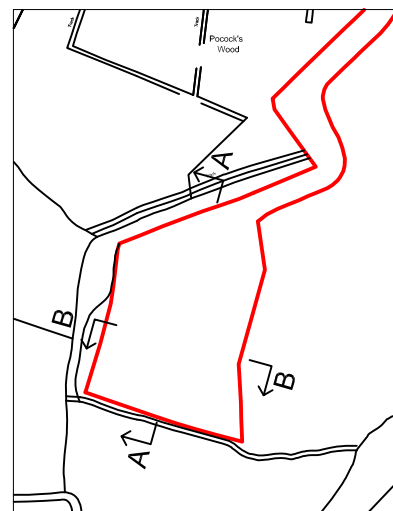

Tree positions and heights shown indicatively and do not represent specific trees


**R ELLIOTT ASSOCIATES LTD**  
 CONSULTING STRUCTURAL & CIVIL ENGINEERS

t: (01590) 683176 f: (01590) 683533 info@rea-ltd.co.uk www.rea-ltd.co.uk

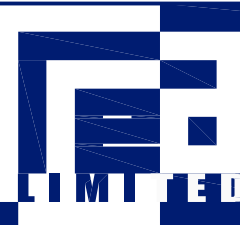


Dennett House  
 Brighton Road  
 Sway  
 Lymington  
 Hampshire  
 SO41 6EB

Client	Celtique Energie Petroleum Broadford Bridge West Sussex	Drawn By	AJNE	Date	March 2012	Sheet Size	A3	
Job Title	Broadford Bridge Site	Drawing Title	Site Sections - Drilling Mode (1:500)				Revision	
		Drawing Number	3261/BB/13					

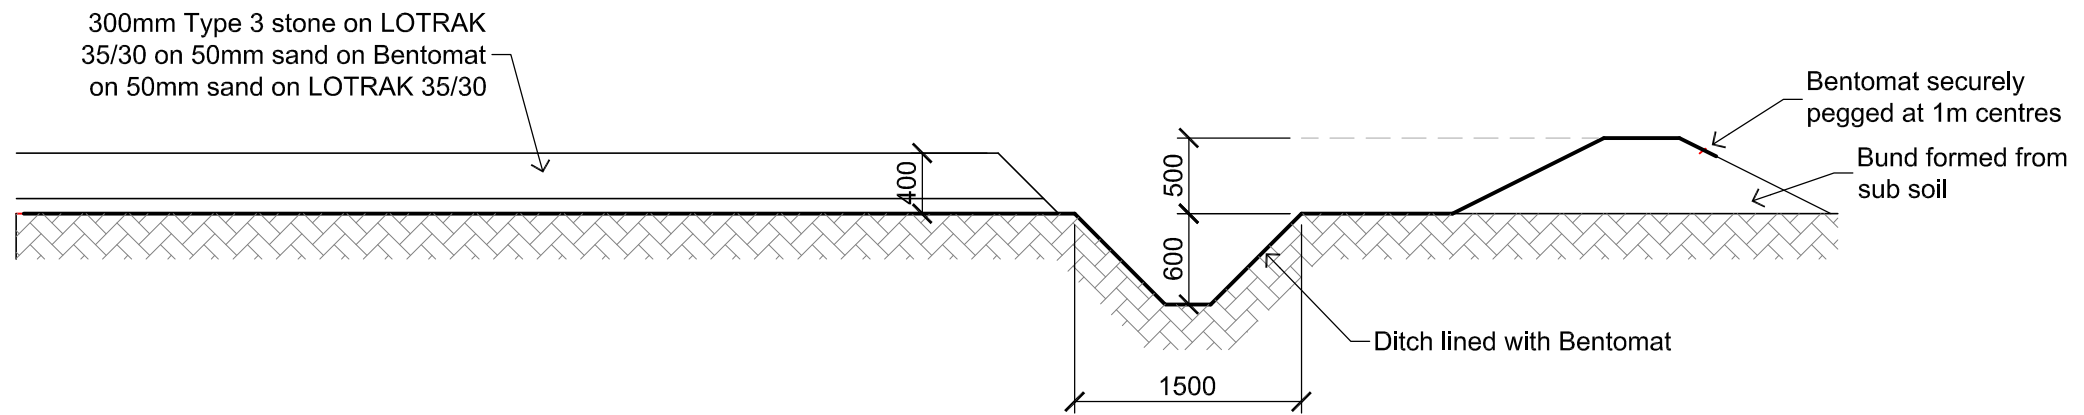


TYPICAL DITCH CONSTRUCTION IN FILL

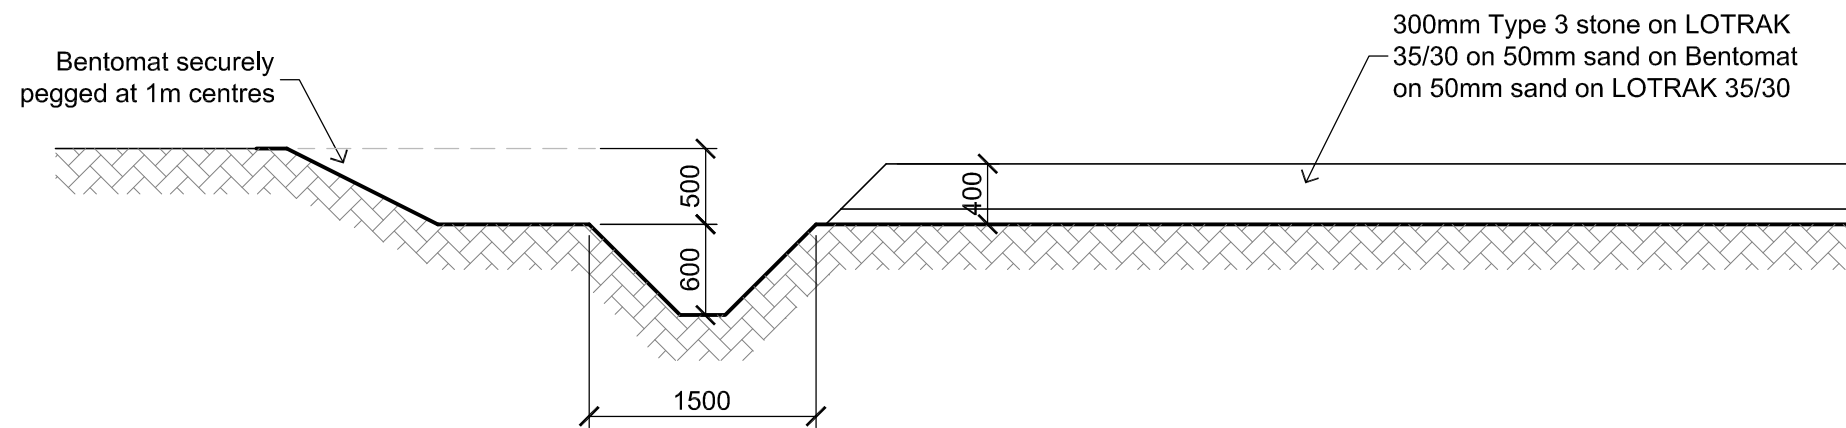

TYPICAL DITCH CONSTRUCTION IN CUT

Site Ditch Construction Details

 Scale 1:50





**R ELLIOTT ASSOCIATES LTD**  
CONSULTING STRUCTURAL & CIVIL ENGINEERS

t: (01590) 683176 f: (01590) 683533 info@rea-ltd.co.uk www.rea-ltd.co.uk




Client	Celtique Energie Petroleum Broadford Bridge West Sussex	Drawn By	AJNE	Date	February 2012	Sheet Size	A3	
Job Title	Broadford Bridge Site	Drawing Title	Site Ditch Construction Details (1:50)				Revision	
		Drawing Number	3261/BB/14					



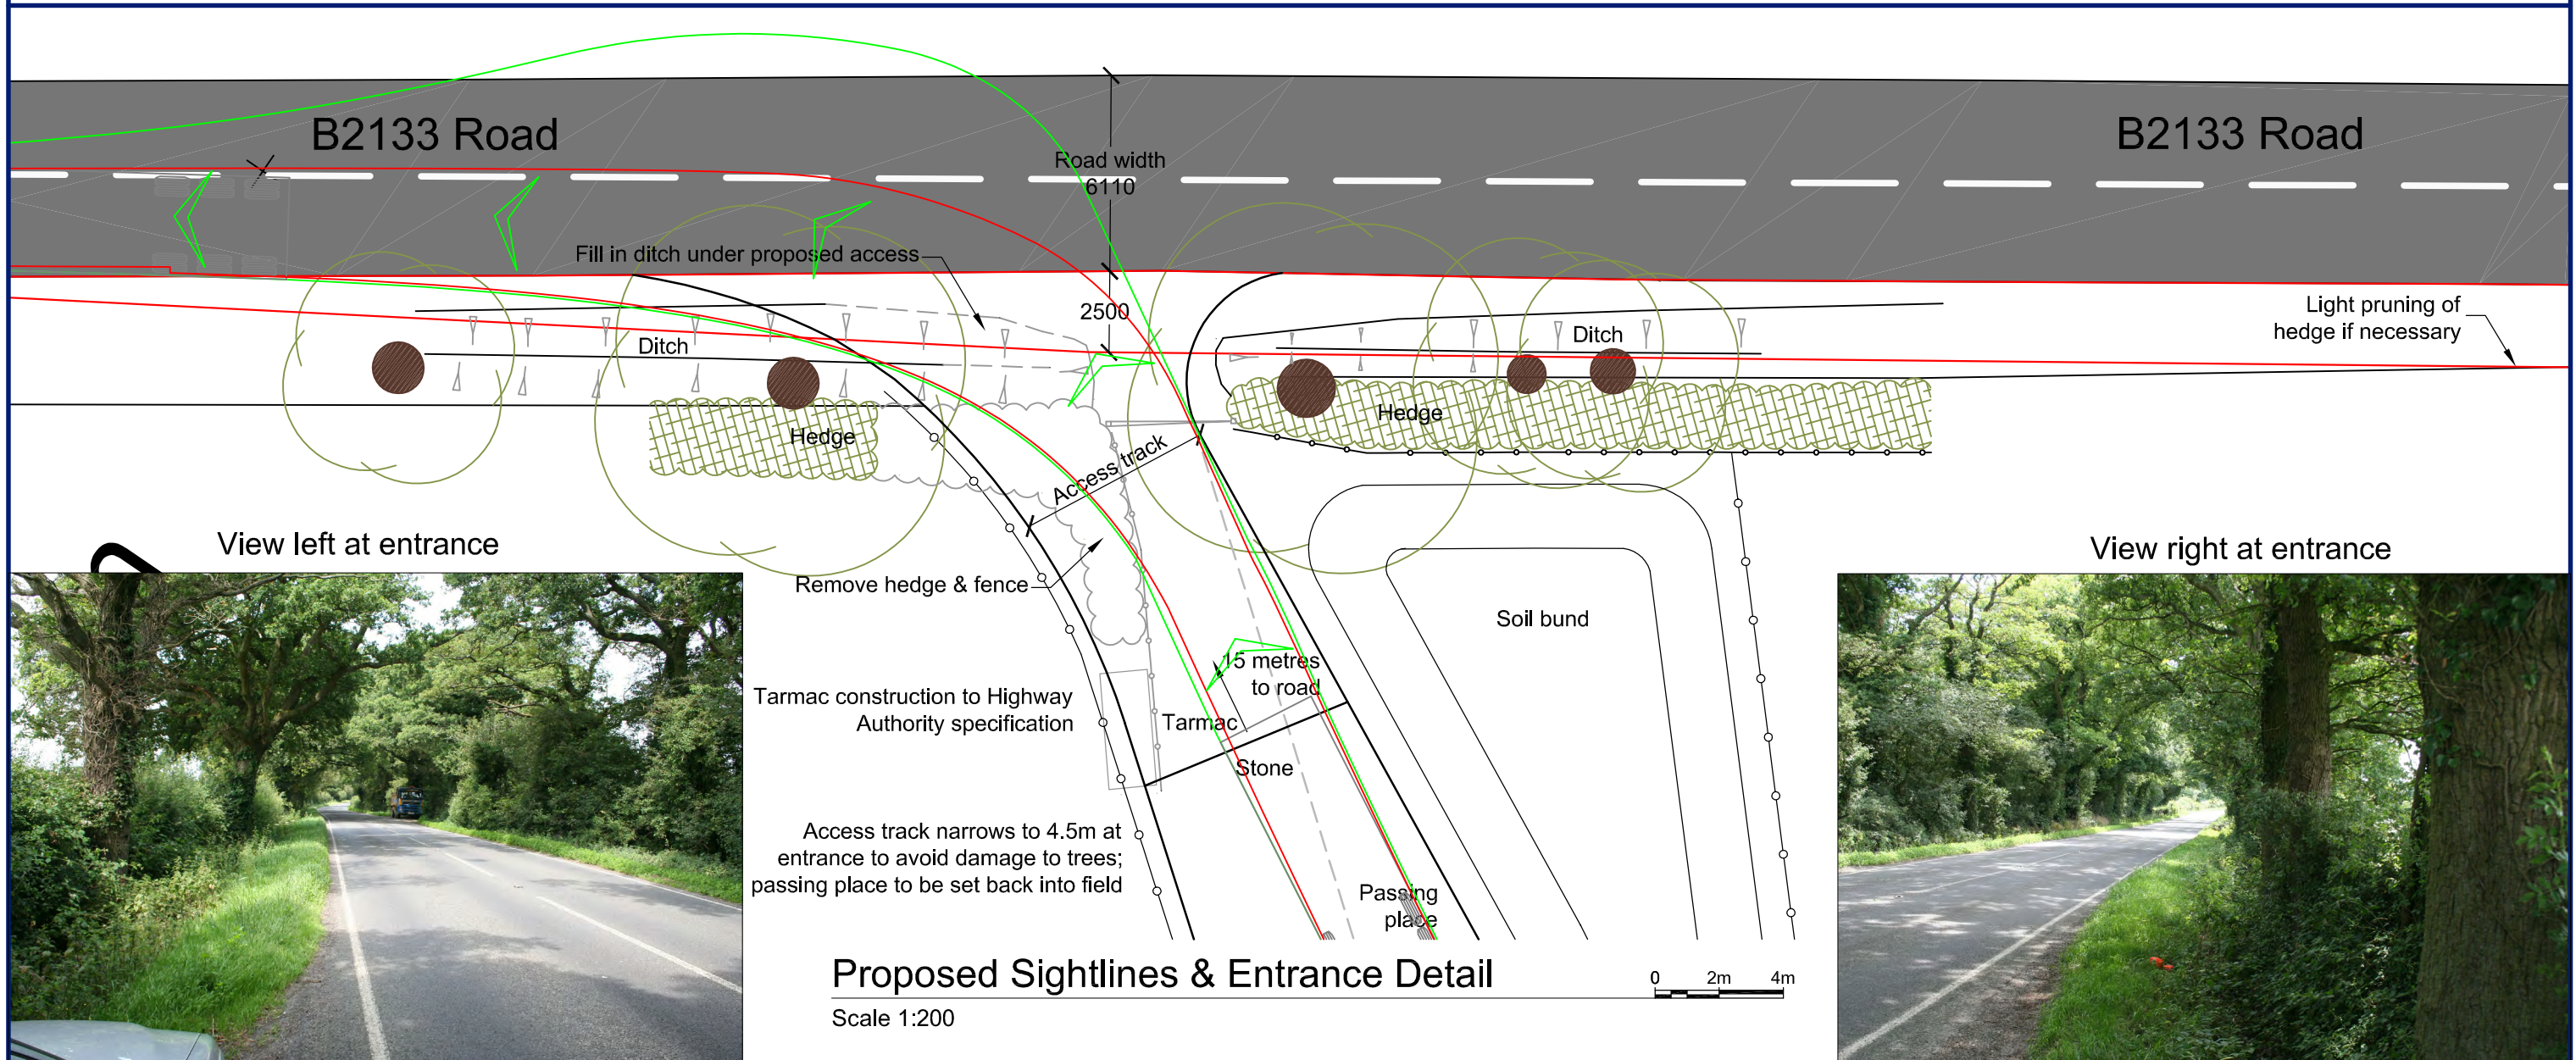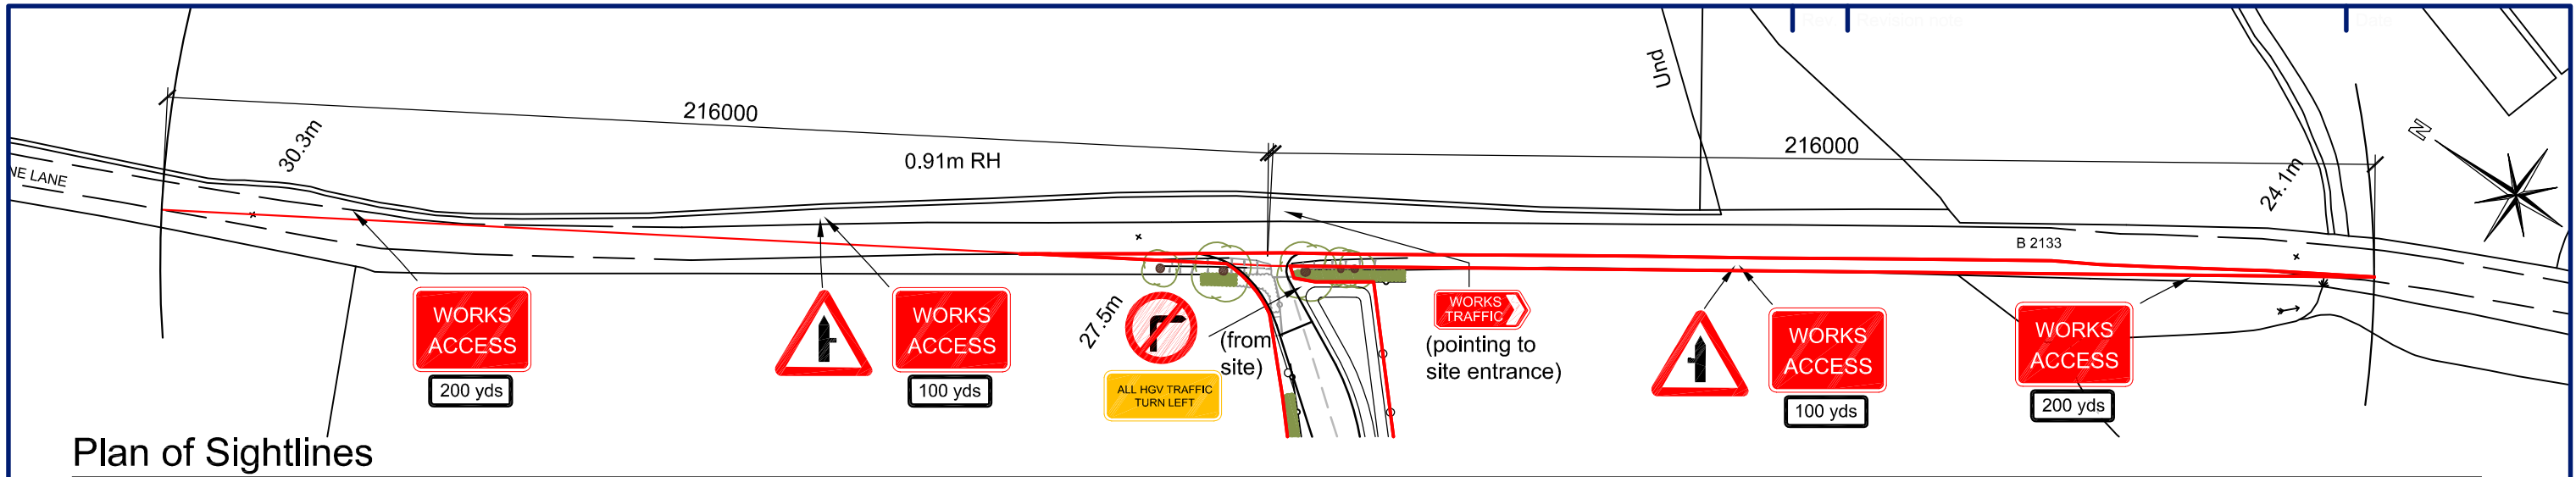

**R ELLIOTT ASSOCIATES LTD**  
CONSULTING STRUCTURAL & CIVIL ENGINEERS

t: (01590) 683176 f: (01590) 683533 info@rea-ltd.co.uk www.rea-ltd.co.uk

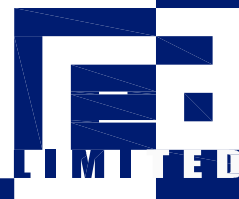

Dennett House  
Brighton Road  
Sway  
Lymington  
Hampshire  
SO41 6EB

Client: Celtique Energie Petroleum  
Broadford Bridge  
West Sussex



Job Title: Broadford Bridge Site

Drawn By	Date	Sheet Size
AJNE	July 2012	A3
Drawing Title: Proposed Site Entrance (1:500)		
Drawing Number	Revision	
3261/BB/15	A	




### Section A-A

 Scale 1:500

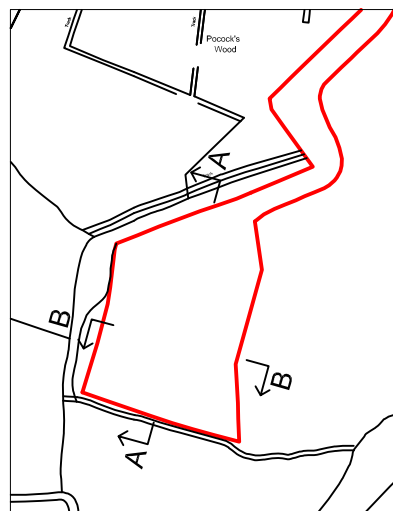

### Section B-B

 Scale 1:500



Tree positions and heights shown indicatively and do not represent specific trees

**R ELLIOTT ASSOCIATES LTD**  
 CONSULTING STRUCTURAL & CIVIL ENGINEERS

t: (01590) 683176    f: (01590) 683533    info@rea-ltd.co.uk    www.rea-ltd.co.uk





Dennett House  
 Brighton Road  
 Sway  
 Lymington  
 Hampshire  
 SO41 6EB

Client <b>Celtique Energie Petroleum Broadford Bridge West Sussex</b>	Drawn By <b>AJNE</b>	Date <b>March 2012</b>	Sheet Size <b>A3</b>
	Drawing Title <b>Site Sections - Existing (1:500)</b>		
Job Title <b>Broadford Bridge Site</b>	Drawing Number <b>3261/BB/16</b>	Revision	




**Section A-A**

Scale 1:500

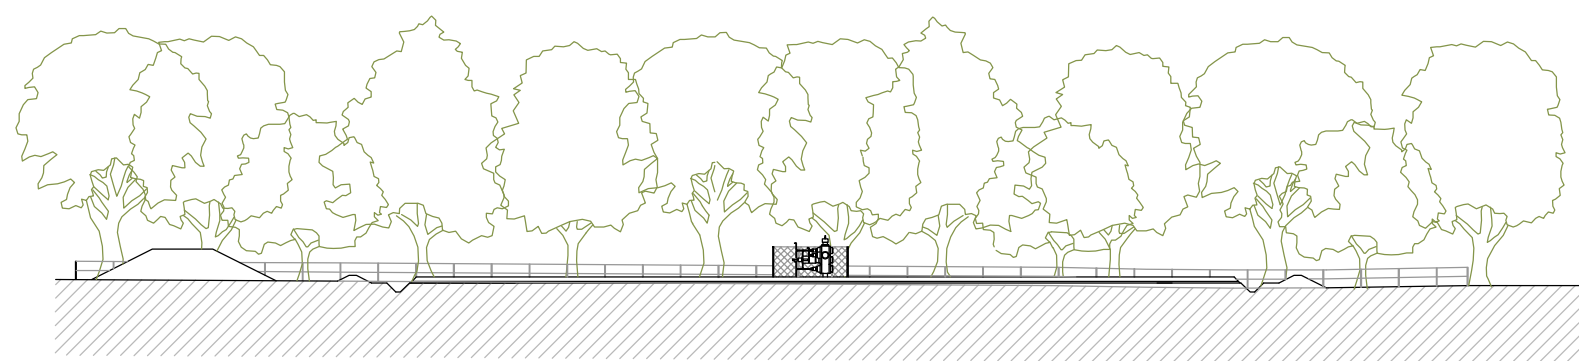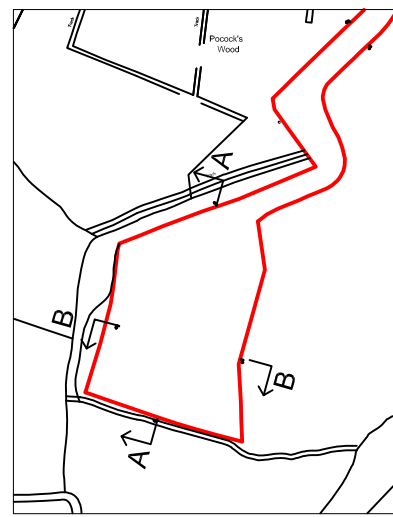

**Section B-B**

 Scale 1:500



Tree positions and heights shown indicatively and do not represent specific trees


**R ELLIOTT ASSOCIATES LTD**  
 CONSULTING STRUCTURAL & CIVIL ENGINEERS

t: (01590) 683176 f: (01590) 683533 info@rea-ltd.co.uk www.rea-ltd.co.uk



Dennett House  
 Brighton Road  
 Sway  
 Lymington  
 Hampshire  
 SO41 6EB

Client	Celtique Energie Petroleum Broadford Bridge West Sussex	Drawn By	AJNE	Date	March 2012	Sheet Size	A3
Job Title	Broadford Bridge Site	Drawing Title		Site Sections - Retention (1:500)		Revision	
		Drawing Number	3261/BB/17				

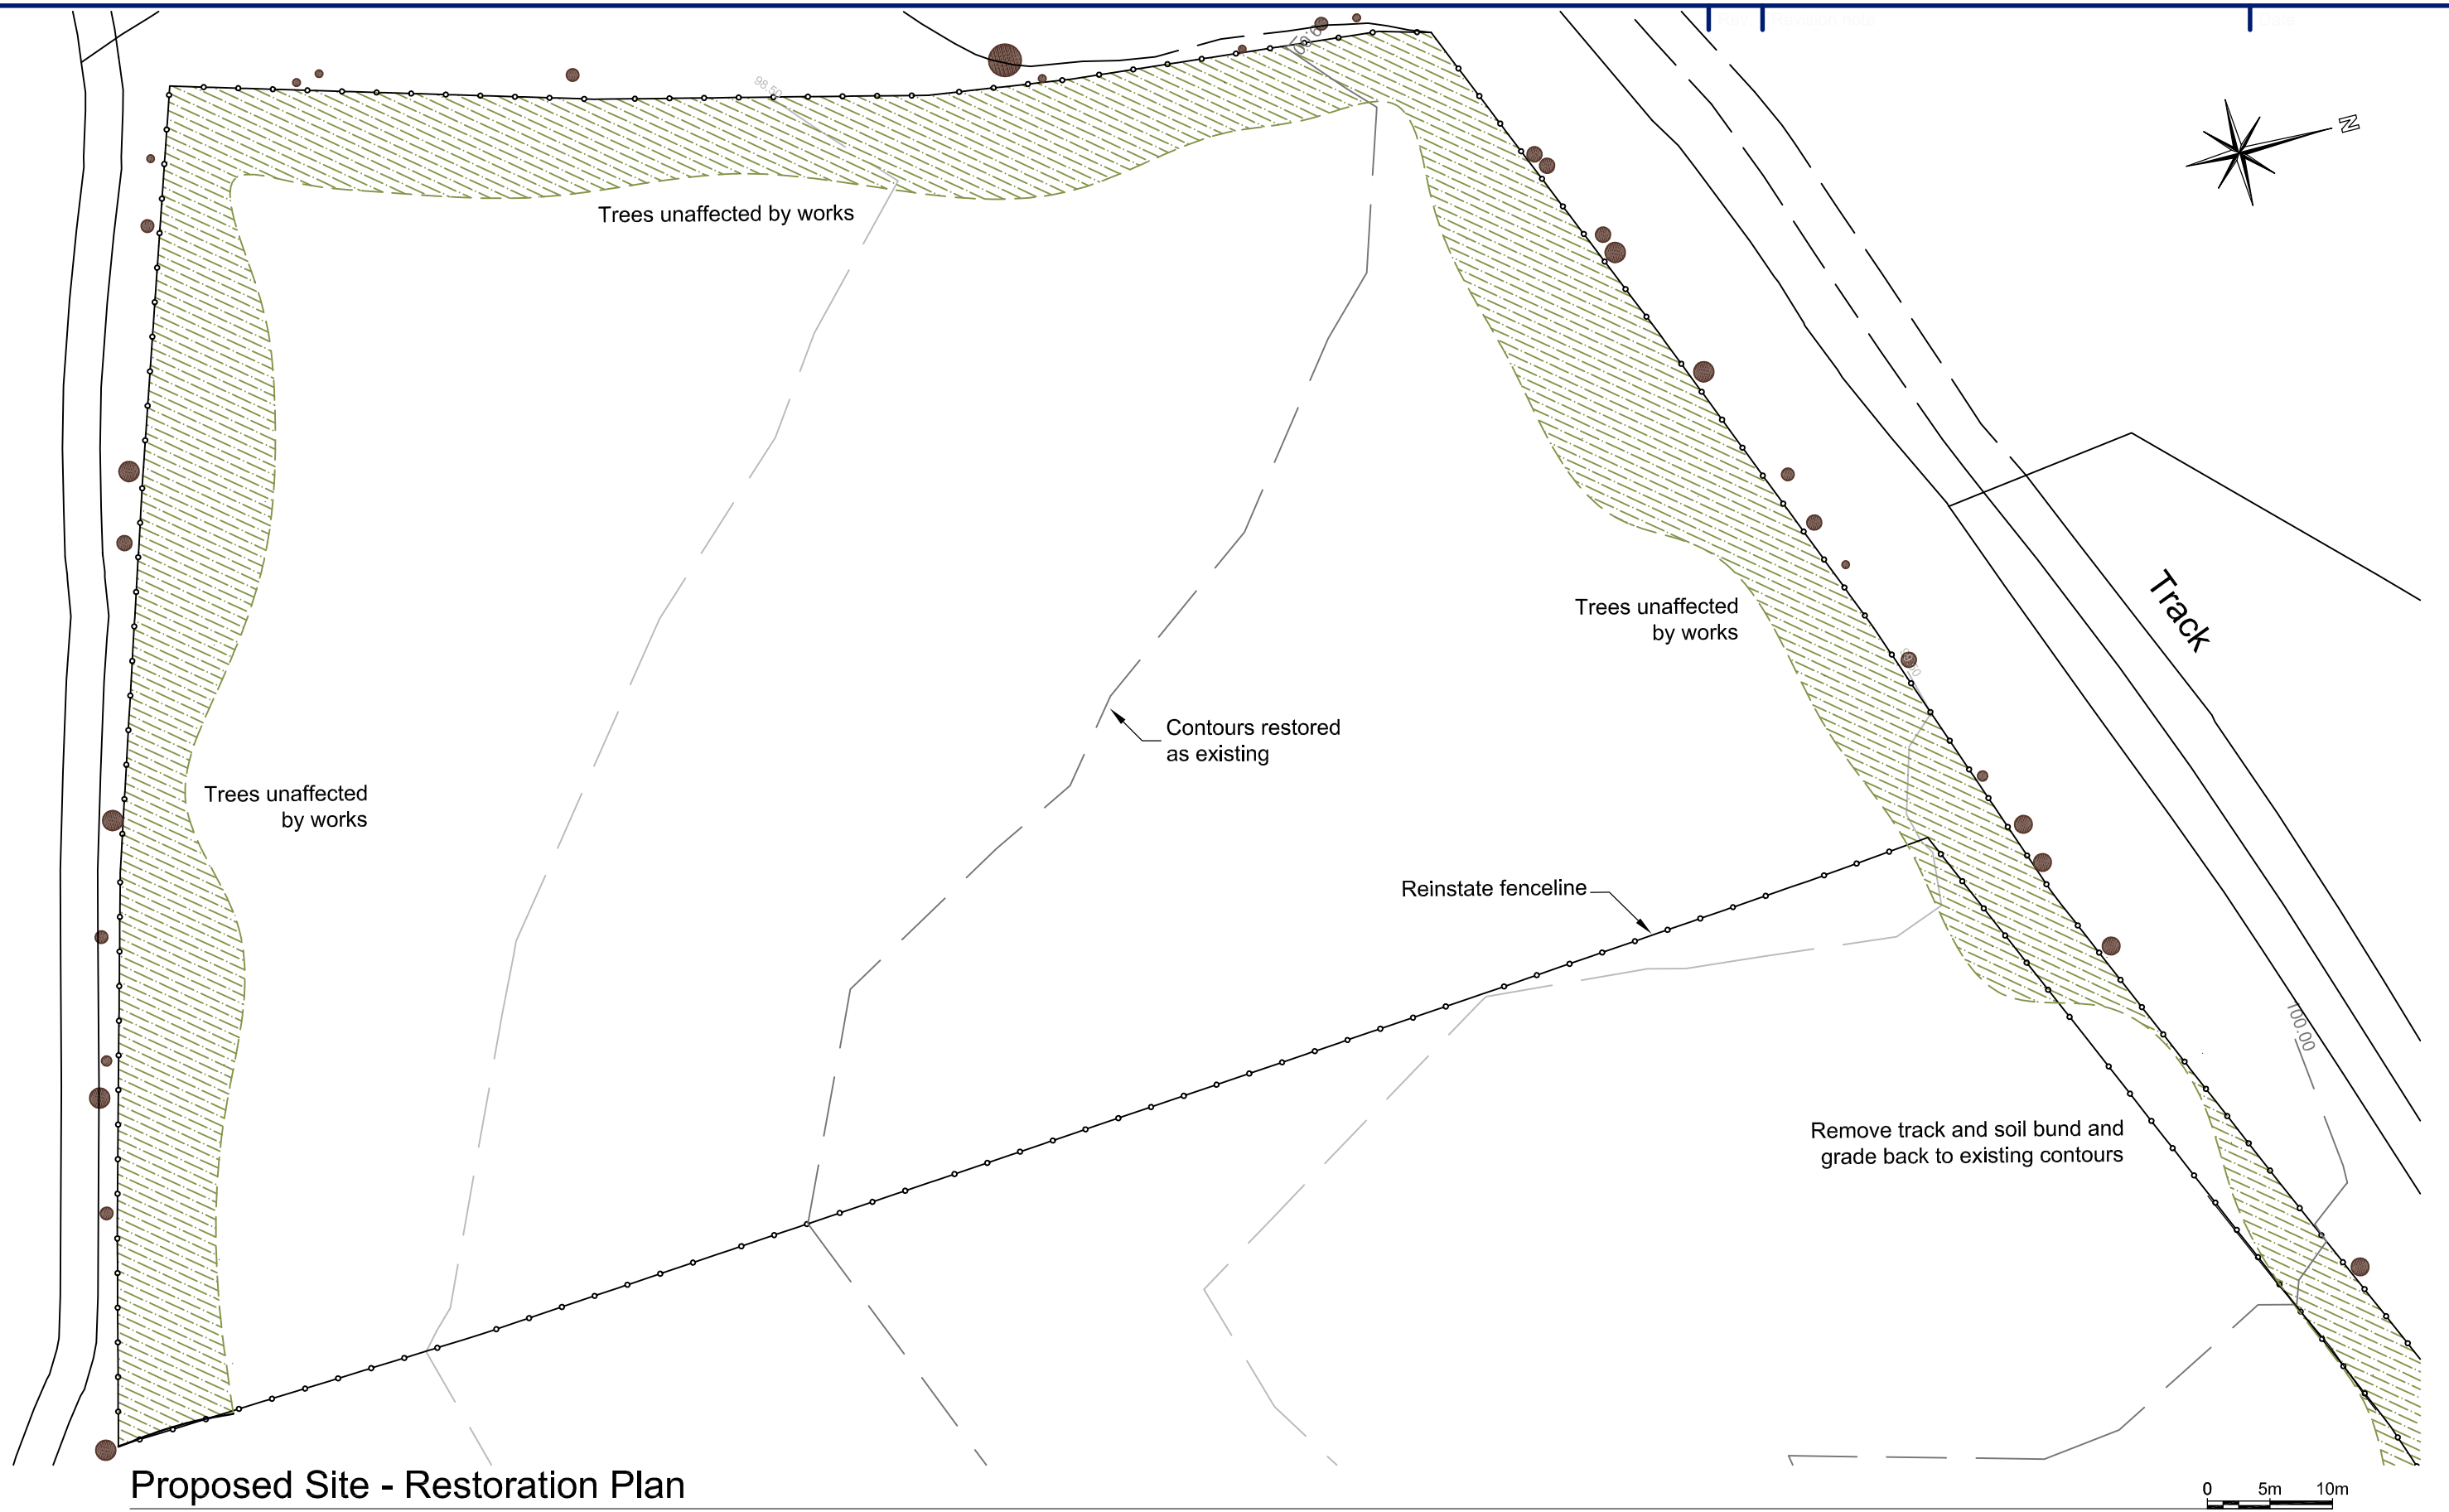

**Proposed Site - Restoration Plan**

Scale 1:500

**R ELLIOTT ASSOCIATES LTD**  
 CONSULTING STRUCTURAL & CIVIL ENGINEERS

t: (01590) 683176 f: (01590) 683533 info@rea-ltd.co.uk www.rea-ltd.co.uk



Dennett House  
 Brighton Road  
 Sway  
 Lymington  
 Hampshire  
 SO41 6EB

Client	Celtique Energie Petroleum Broadford Bridge West Sussex	Drawn By	AJNE	Date	July 2012	Sheet Size	A3	
Job Title	Broadford Bridge Site	Drawing Title	Proposed Site - Restoration Plan (1:500)				Revision	
		Drawing Number	3261/BB/18					