


Site Layout - Drilling Mode

Scale 1:500

R ELLIOTT ASSOCIATES LTD
 CONSULTING STRUCTURAL & CIVIL ENGINEERS

t: (01590) 683176 f: (01590) 683533 info@rea-ltd.co.uk www.rea-ltd.co.uk

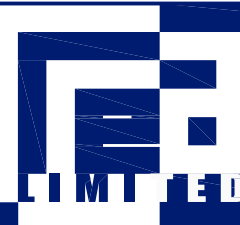


Dennett House
 Brighton Road
 Sway
 Lymington
 Hampshire
 SO41 6EB





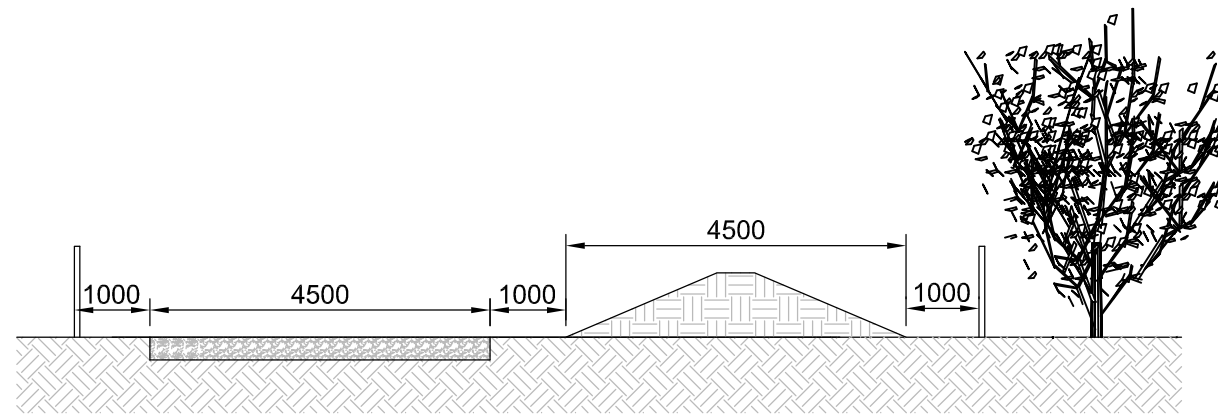

Client: Celtique Energie Petroleum
 Broadford Bridge
 West Sussex


Job Title: Broadford Bridge Site

Drawn By	Date	Sheet Size
AJNE	February 2012	A3
Drawing Title	Site Layout - Drilling Mode (1:500)	
Drawing Number	Figure 4.1	Revision




TYPICAL ACCESS TRACK CONSTRUCTION

-  Tree Canopy
-  Tree Positions
-  Tree Root Protection Area
-  Maximum Tree Protection Area
-  Area of crown excess over RPA
-  Proposed hedgerow

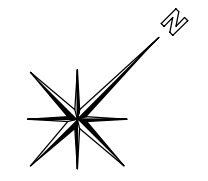


27.5m

For Entrance Details see drawing 3261/BB/15

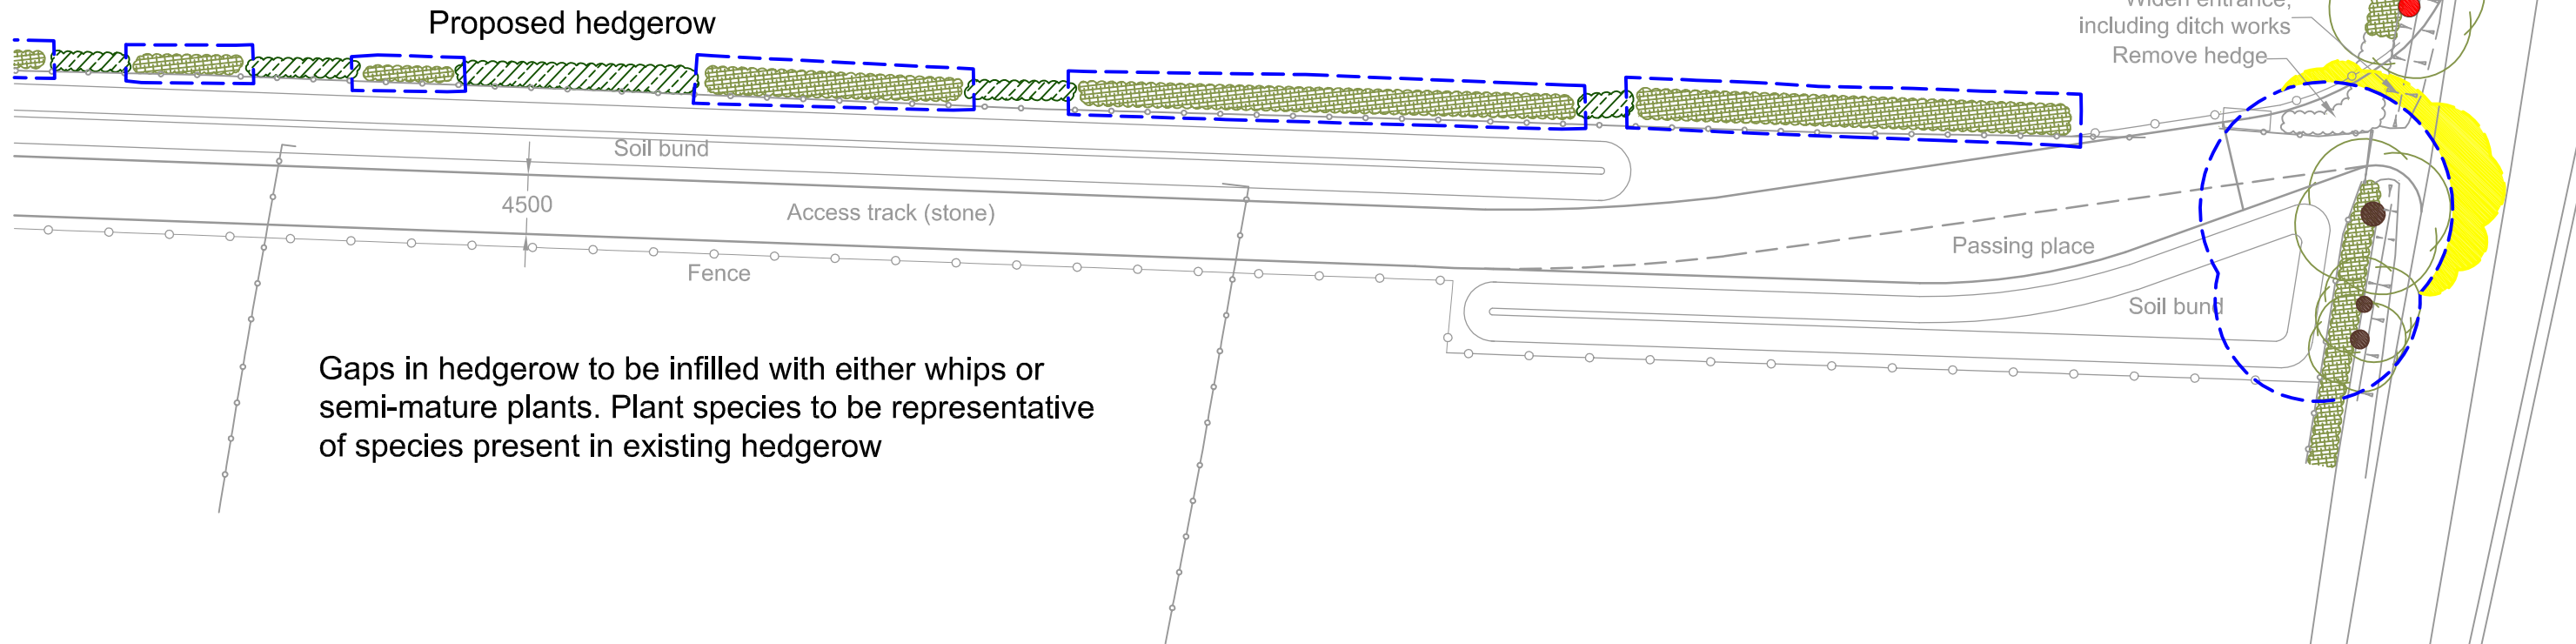

Tree Report - Access Track 1

 Scale 1:500





Tree protection zones and classifications taken from BS 5837:2005 'Trees in Relation to Construction - Recommendations'

R ELLIOTT ASSOCIATES LTD
CONSULTING STRUCTURAL & CIVIL ENGINEERS

t: (01590) 683176 f: (01590) 683533 info@rea-ltd.co.uk www.rea-ltd.co.uk

RELLIOTT ASSOCIATES LTD
Dennett House
Brighton Road
Sway
Lymington
Hampshire
SO41 6EB

Client	Celtique Energie Petroleum Broadford Bridge West Sussex	Drawn By	AJNE	Date	July 2012	Sheet Size	A3	
Job Title	Broadford Bridge Site	Drawing Title	Tree Report - Access Track 1 (1:500)				Revision	
		Drawing Number	Figure 4.2					

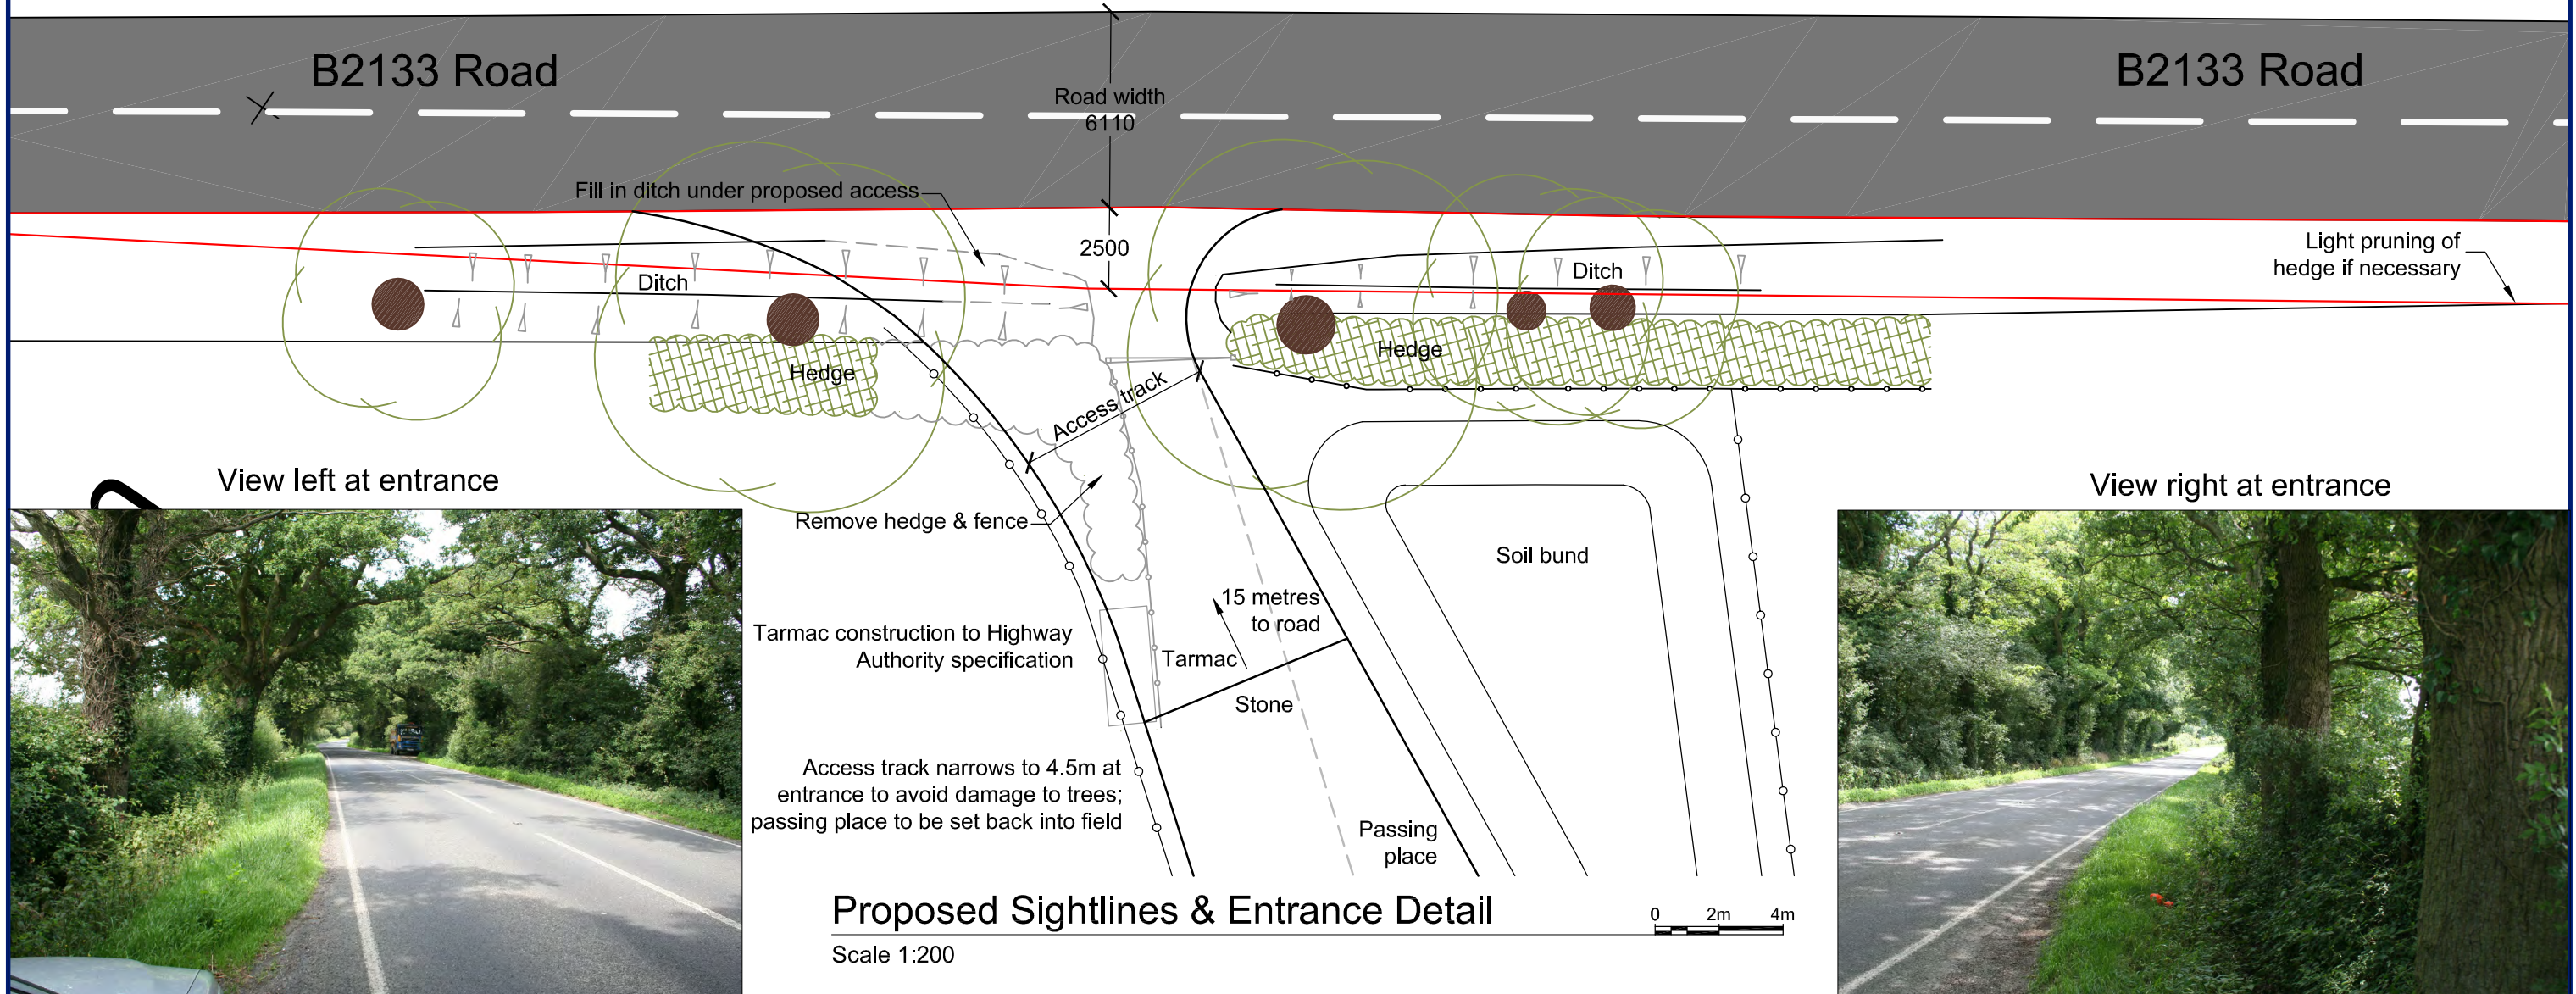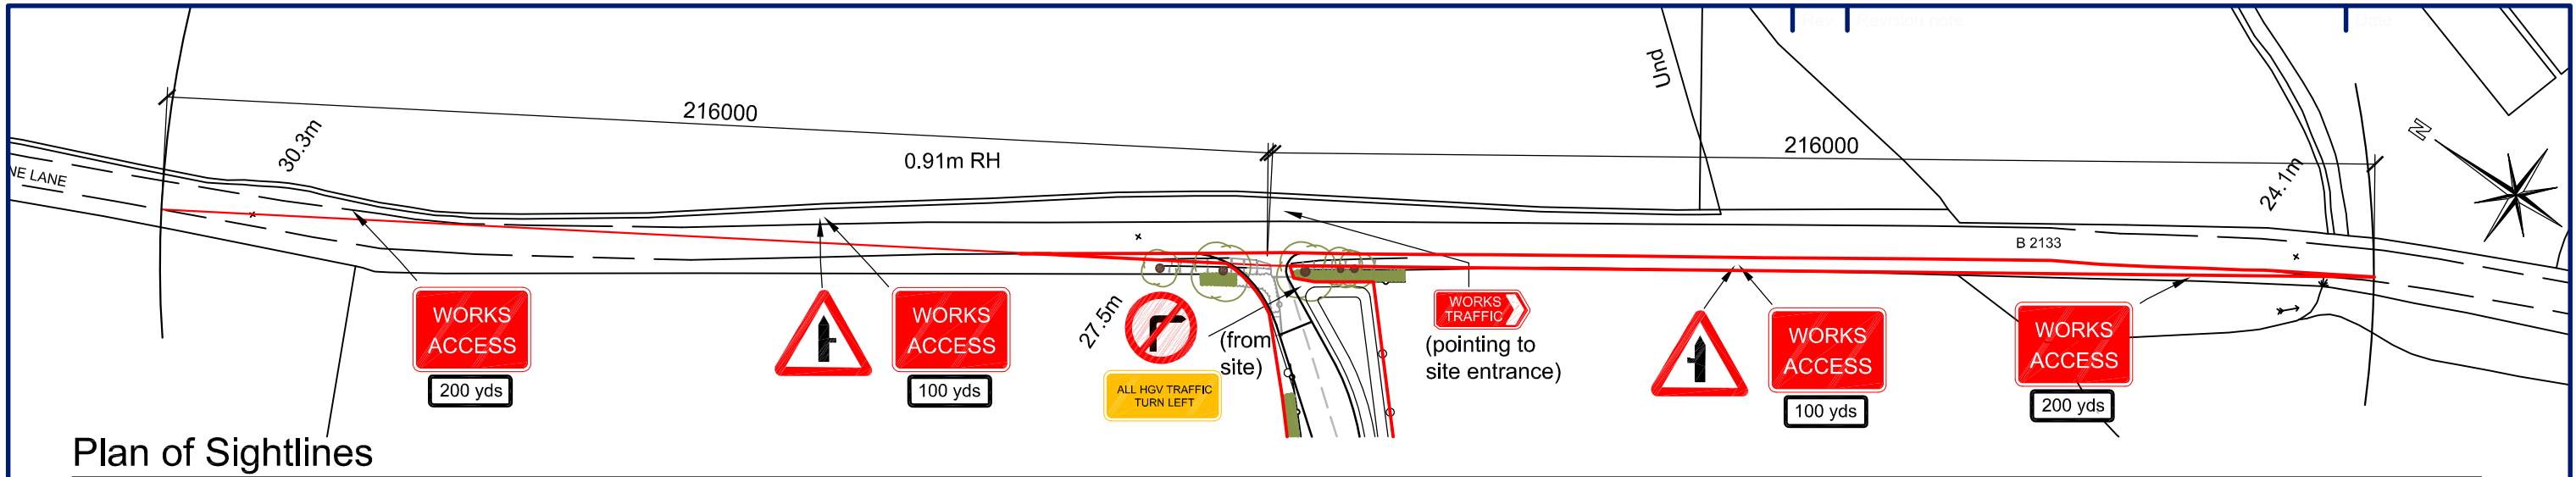

R ELLIOTT ASSOCIATES LTD
CONSULTING STRUCTURAL & CIVIL ENGINEERS

t: (01590) 683176 f: (01590) 683533 info@rea-ltd.co.uk www.rea-ltd.co.uk




Dennett House
Brighton Road
Sway
Lymington
Hampshire
SO41 6EB

Client: Celtique Energie Petroleum
Broadford Bridge
West Sussex

Job Title: Broadford Bridge Site

Drawn By	Date	Sheet Size
AJNE	February 2012	A3
Drawing Title	Proposed Site Entrance (1:500)	
Drawing Number	Figure 4.4	Revision

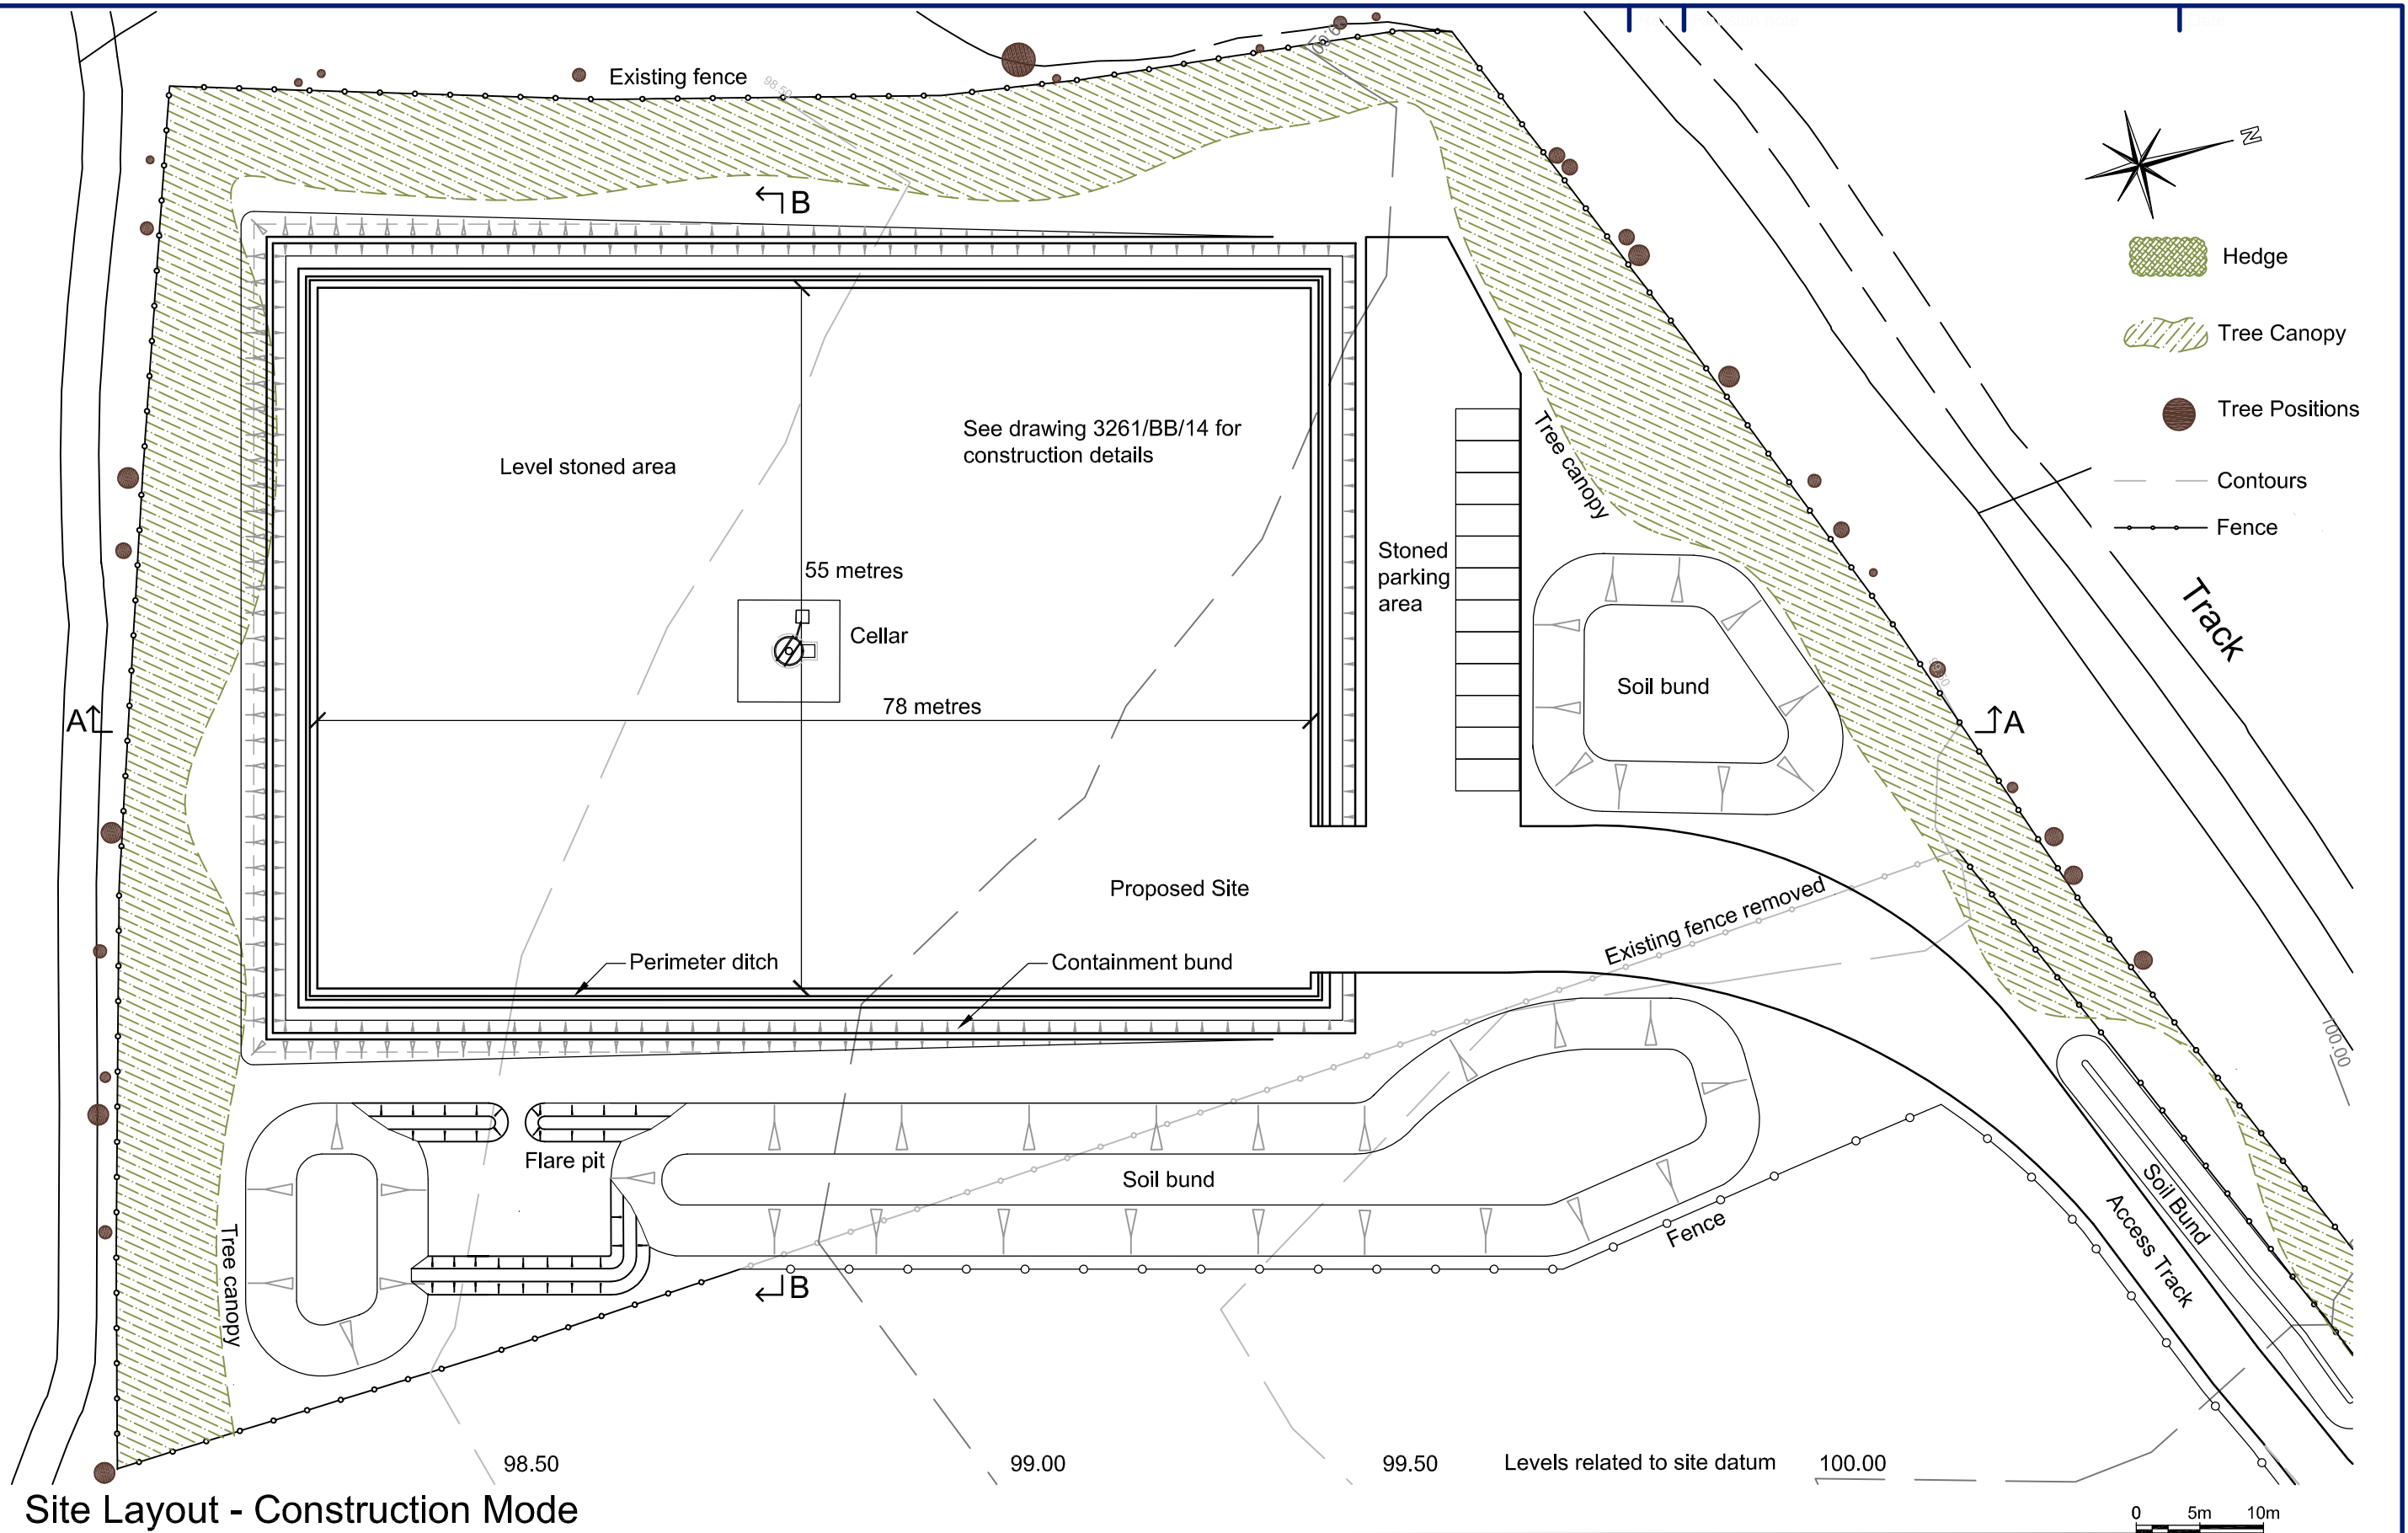

Site Layout - Construction Mode

Scale 1:500


R ELLIOTT ASSOCIATES LTD
 CONSULTING STRUCTURAL & CIVIL ENGINEERS

t: (01590) 683176 f: (01590) 683533 info@rea-ltd.co.uk www.rea-ltd.co.uk






Dennett House
 Brighton Road
 Sway
 Lymington
 Hampshire
 SO41 6EB

Client	Celtique Energie Petroleum Broadford Bridge West Sussex	Drawn By	AJNE	Date	August 2012	Sheet Size	A3
Job Title	Broadford Bridge Site	Drawing Title	Site Layout - Construction Mode (1:500)			Revision	
		Drawing Number	Figure 4.5				

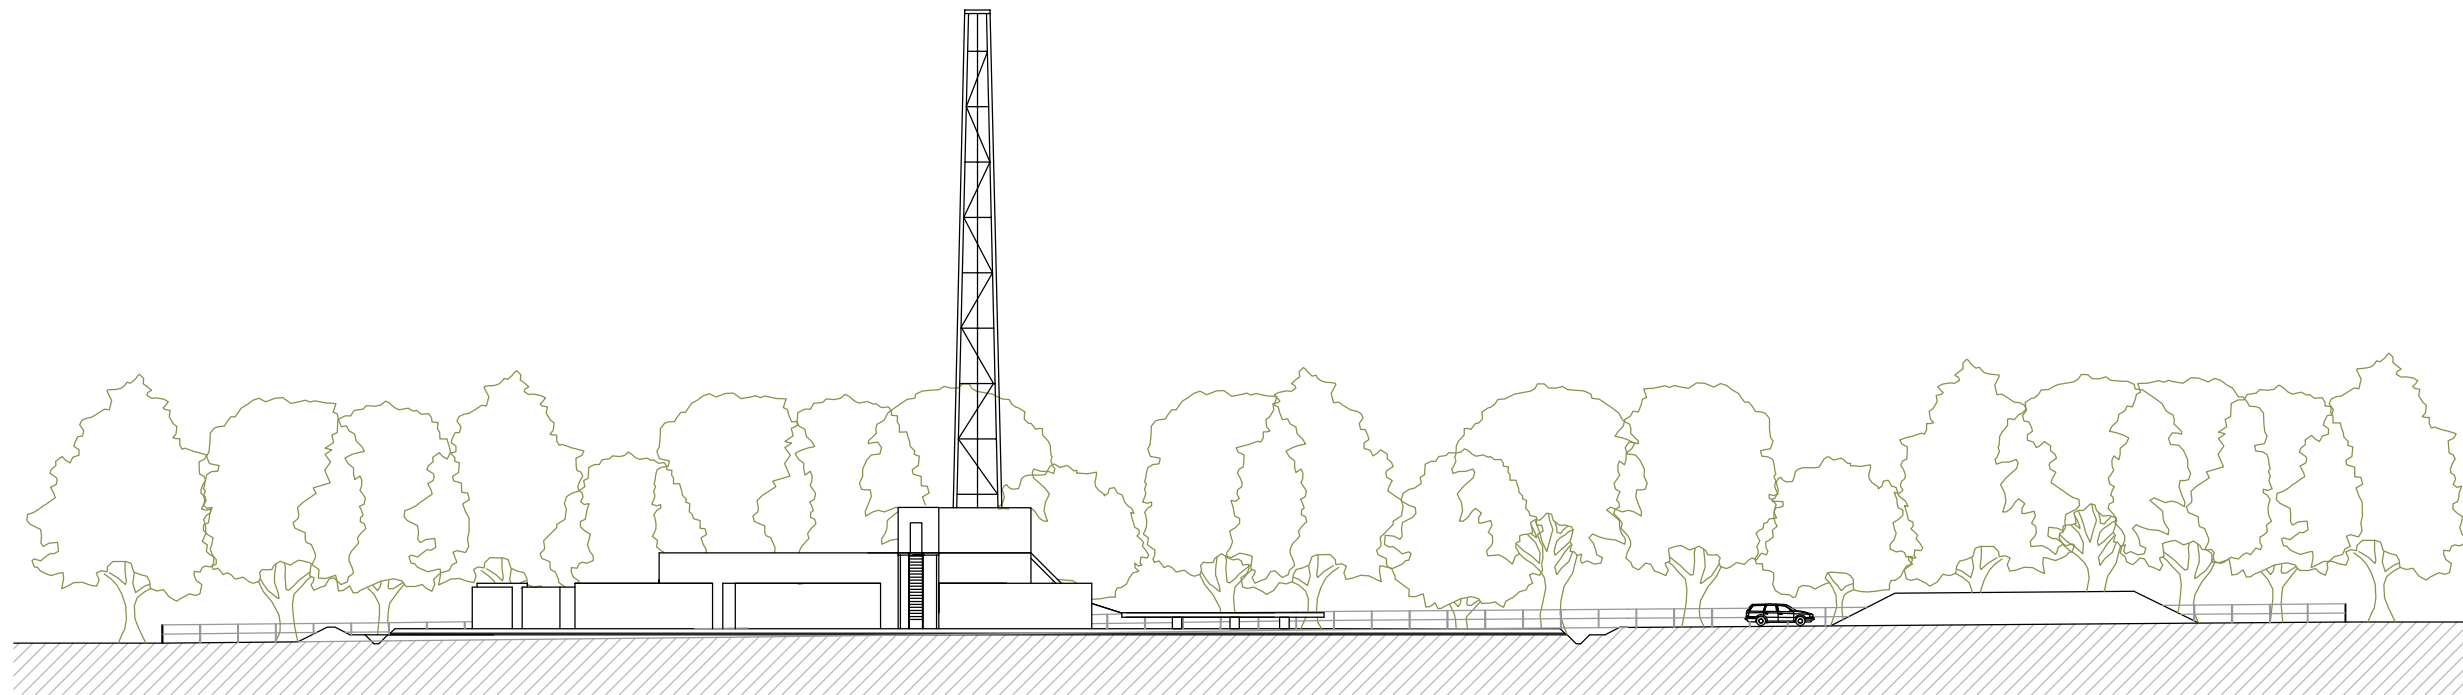


Section A-A

 Scale 1:500

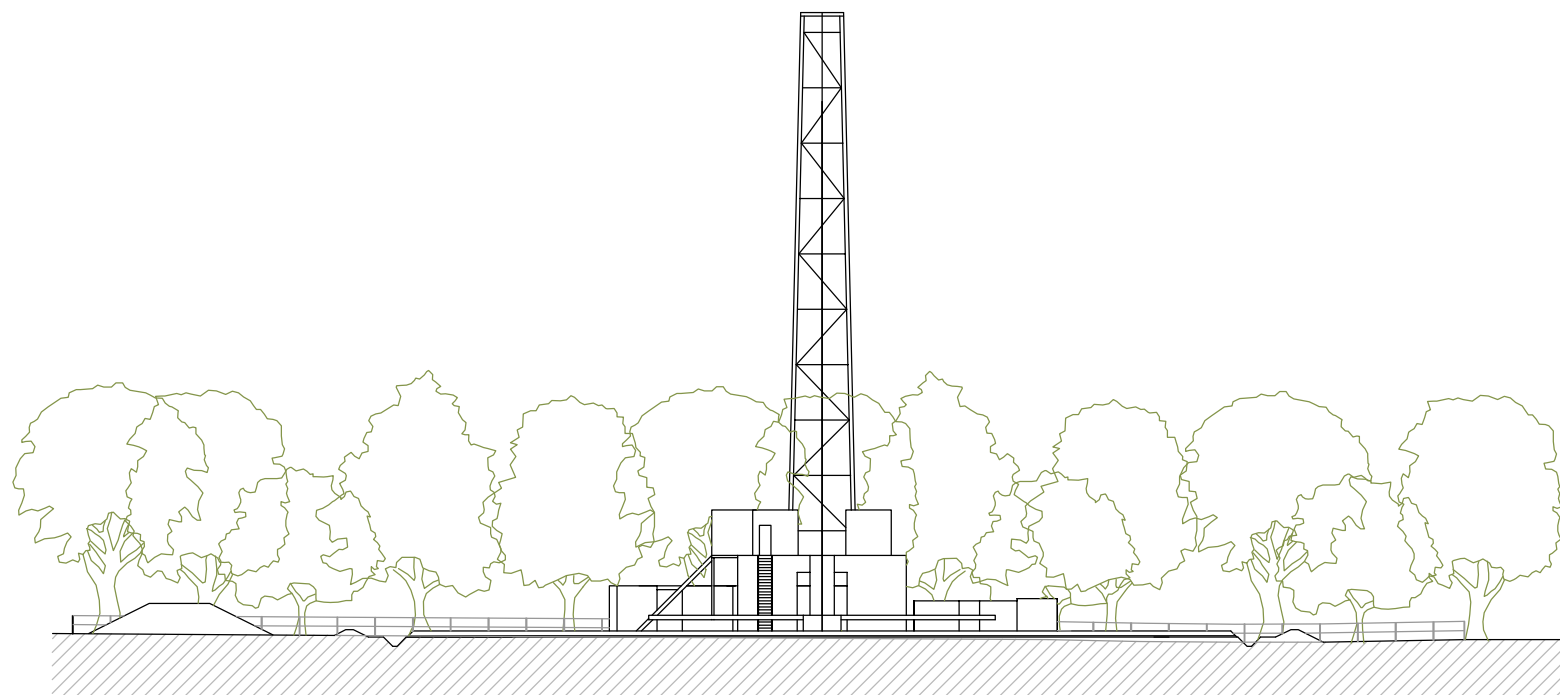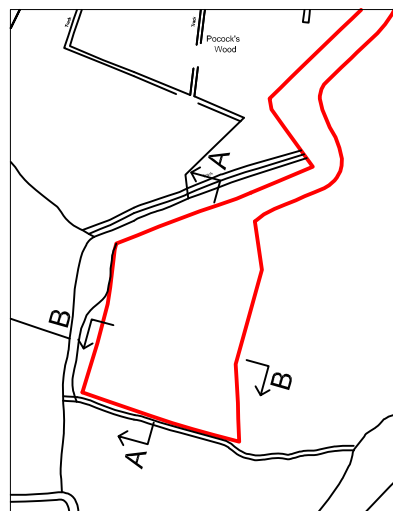

Section B-B

 Scale 1:500



Tree positions and heights shown indicatively and do not represent specific trees


R ELLIOTT ASSOCIATES LTD
 CONSULTING STRUCTURAL & CIVIL ENGINEERS

t: (01590) 683176 f: (01590) 683533 info@rea-ltd.co.uk www.rea-ltd.co.uk



Dennett House
 Brighton Road
 Sway
 Lymington
 Hampshire
 SO41 6EB

Client	Celtique Energie Petroleum Broadford Bridge West Sussex	Drawn By	AJNE	Date	March 2012	Sheet Size	A3
Job Title	Broadford Bridge Site	Drawing Title				Site Sections - Drilling Mode (1:500)	
		Drawing Number				Figure 4.6	
						Revision	

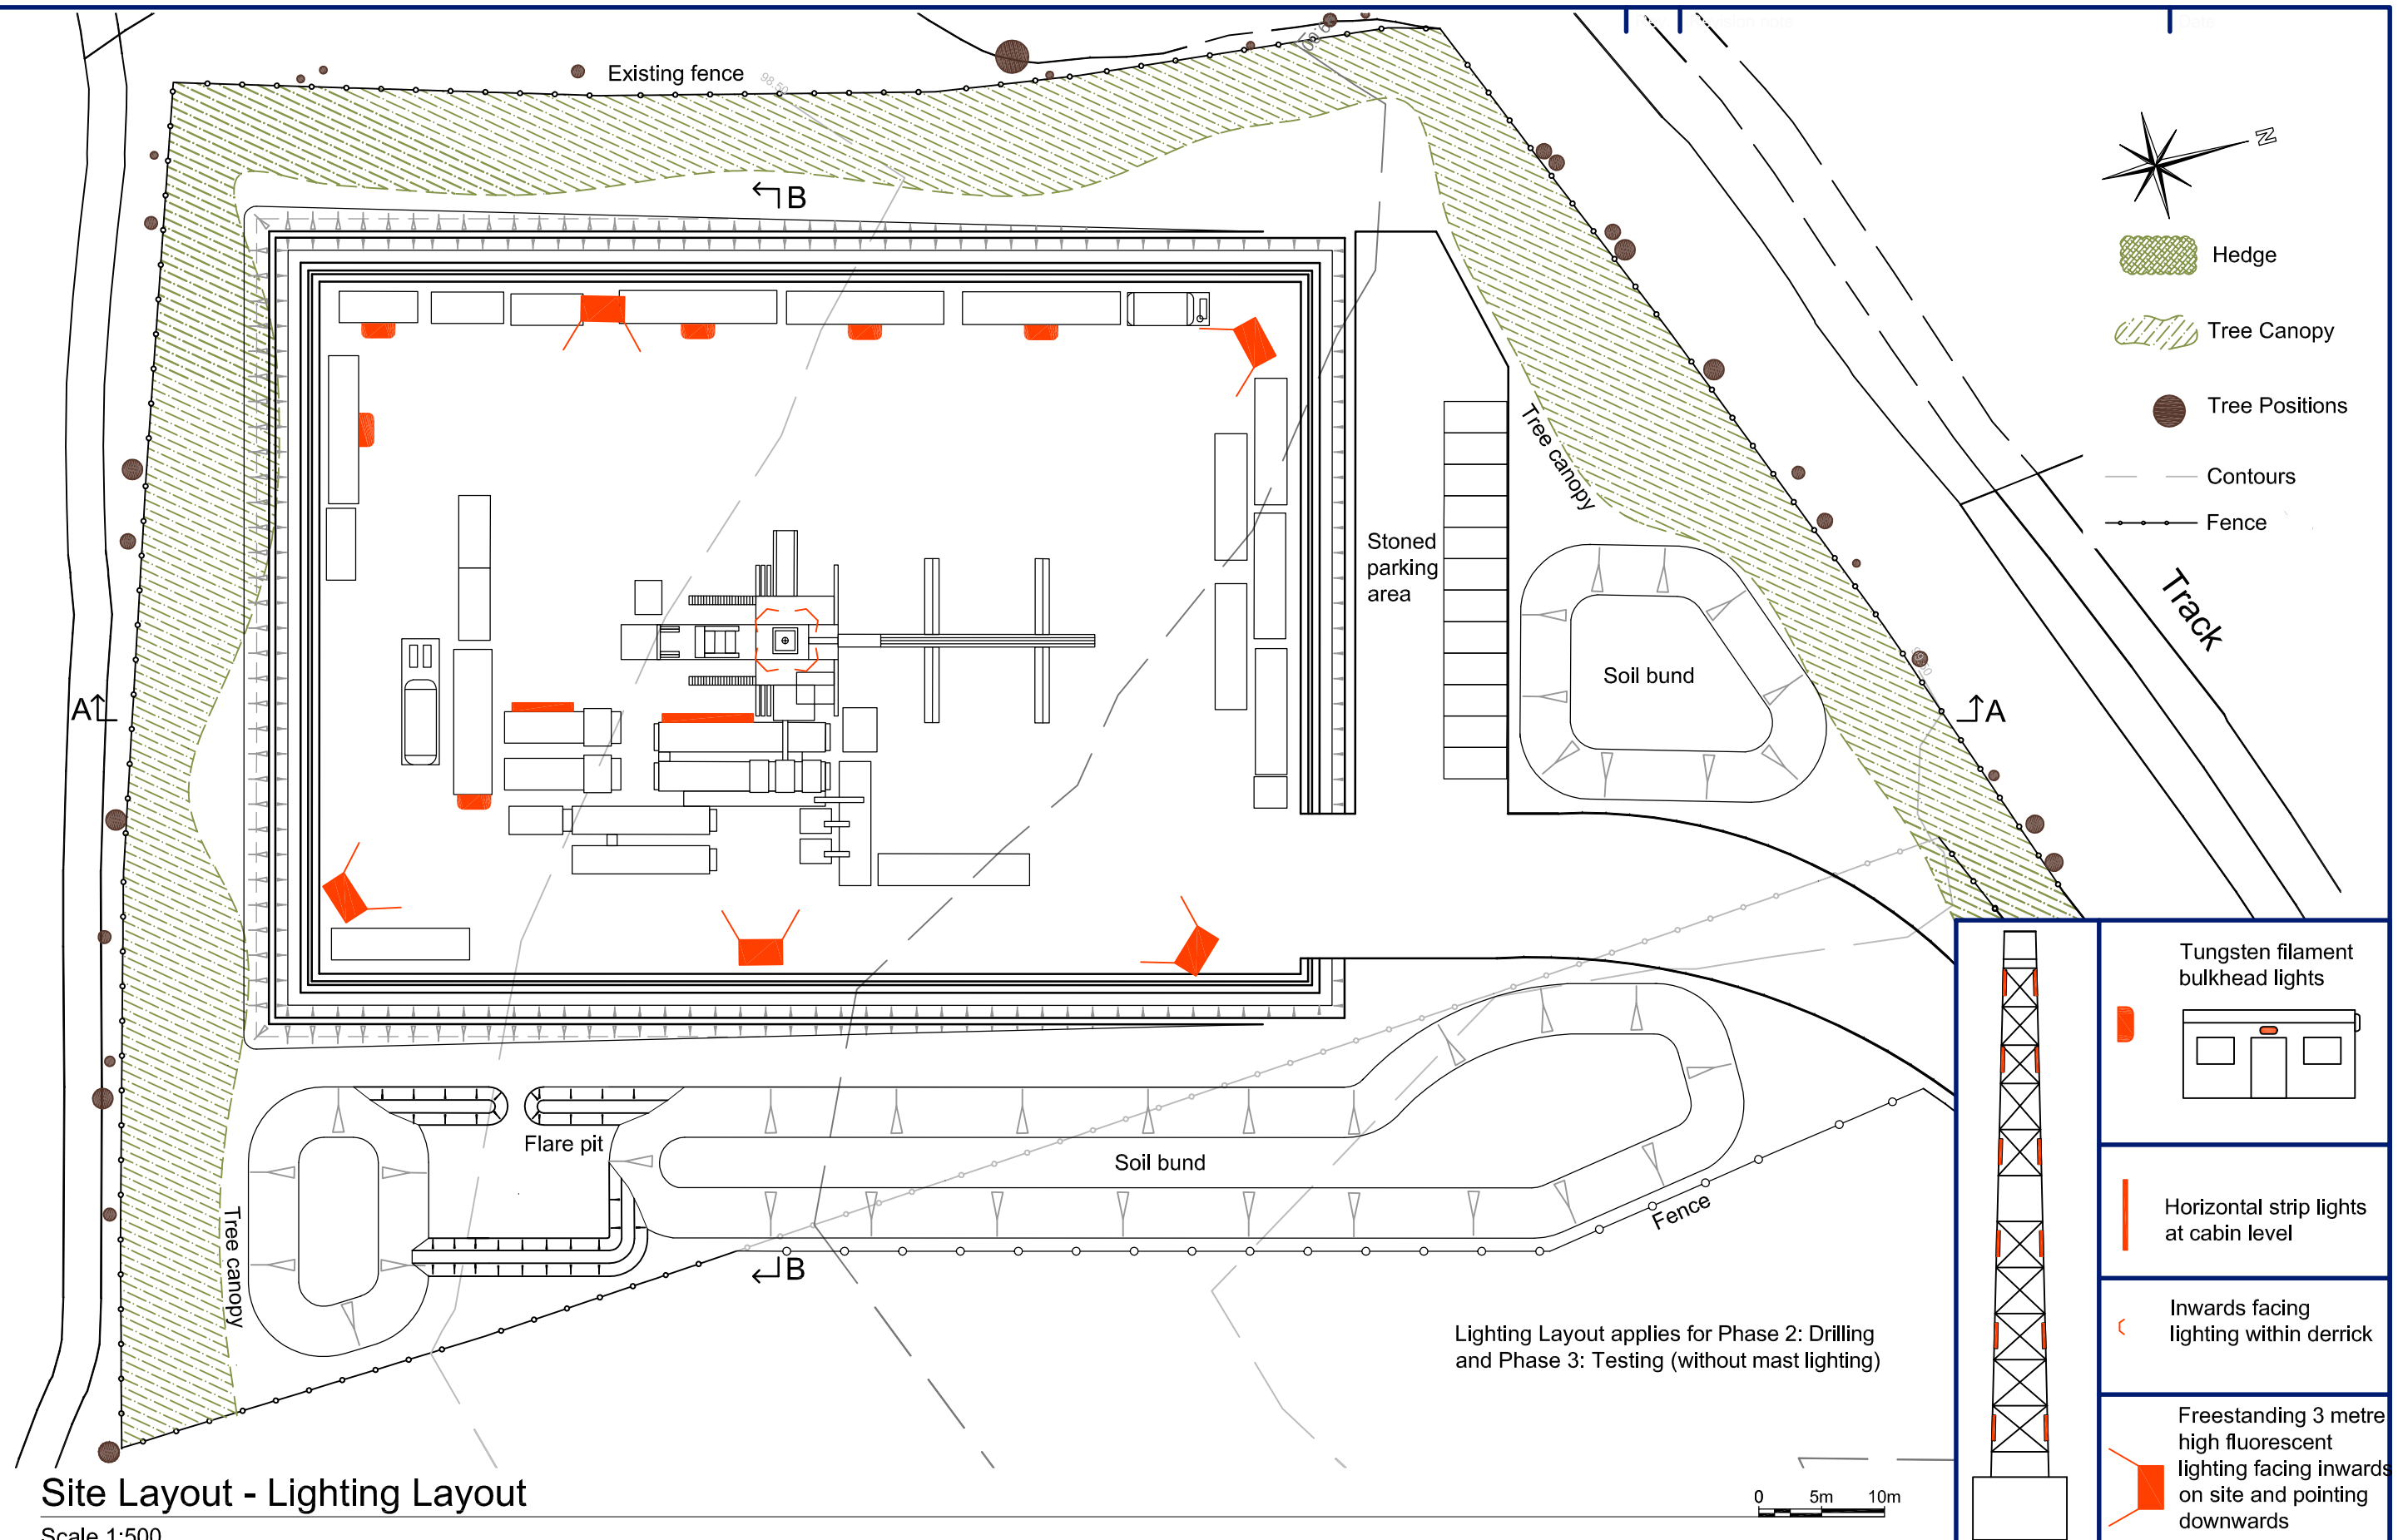

Site Layout - Lighting Layout

Scale 1:500

R ELLIOTT ASSOCIATES LTD
 CONSULTING STRUCTURAL & CIVIL ENGINEERS

t: (01590) 683176 f: (01590) 683533 info@rea-ltd.co.uk www.rea-ltd.co.uk



Dennett House
 Brighton Road
 Sway
 Lymington
 Hampshire
 SO41 6EB

Client: Celtique Energie Petroleum
 Broadford Bridge
 West Sussex

Job Title: Broadford Bridge Site

Drawn By: AJNE

Drawing Title: Site Layout - Lighting (1:500)


Drawing Number

Date: August 2012

Figure 4.7

Sheet Size: A3

Revision

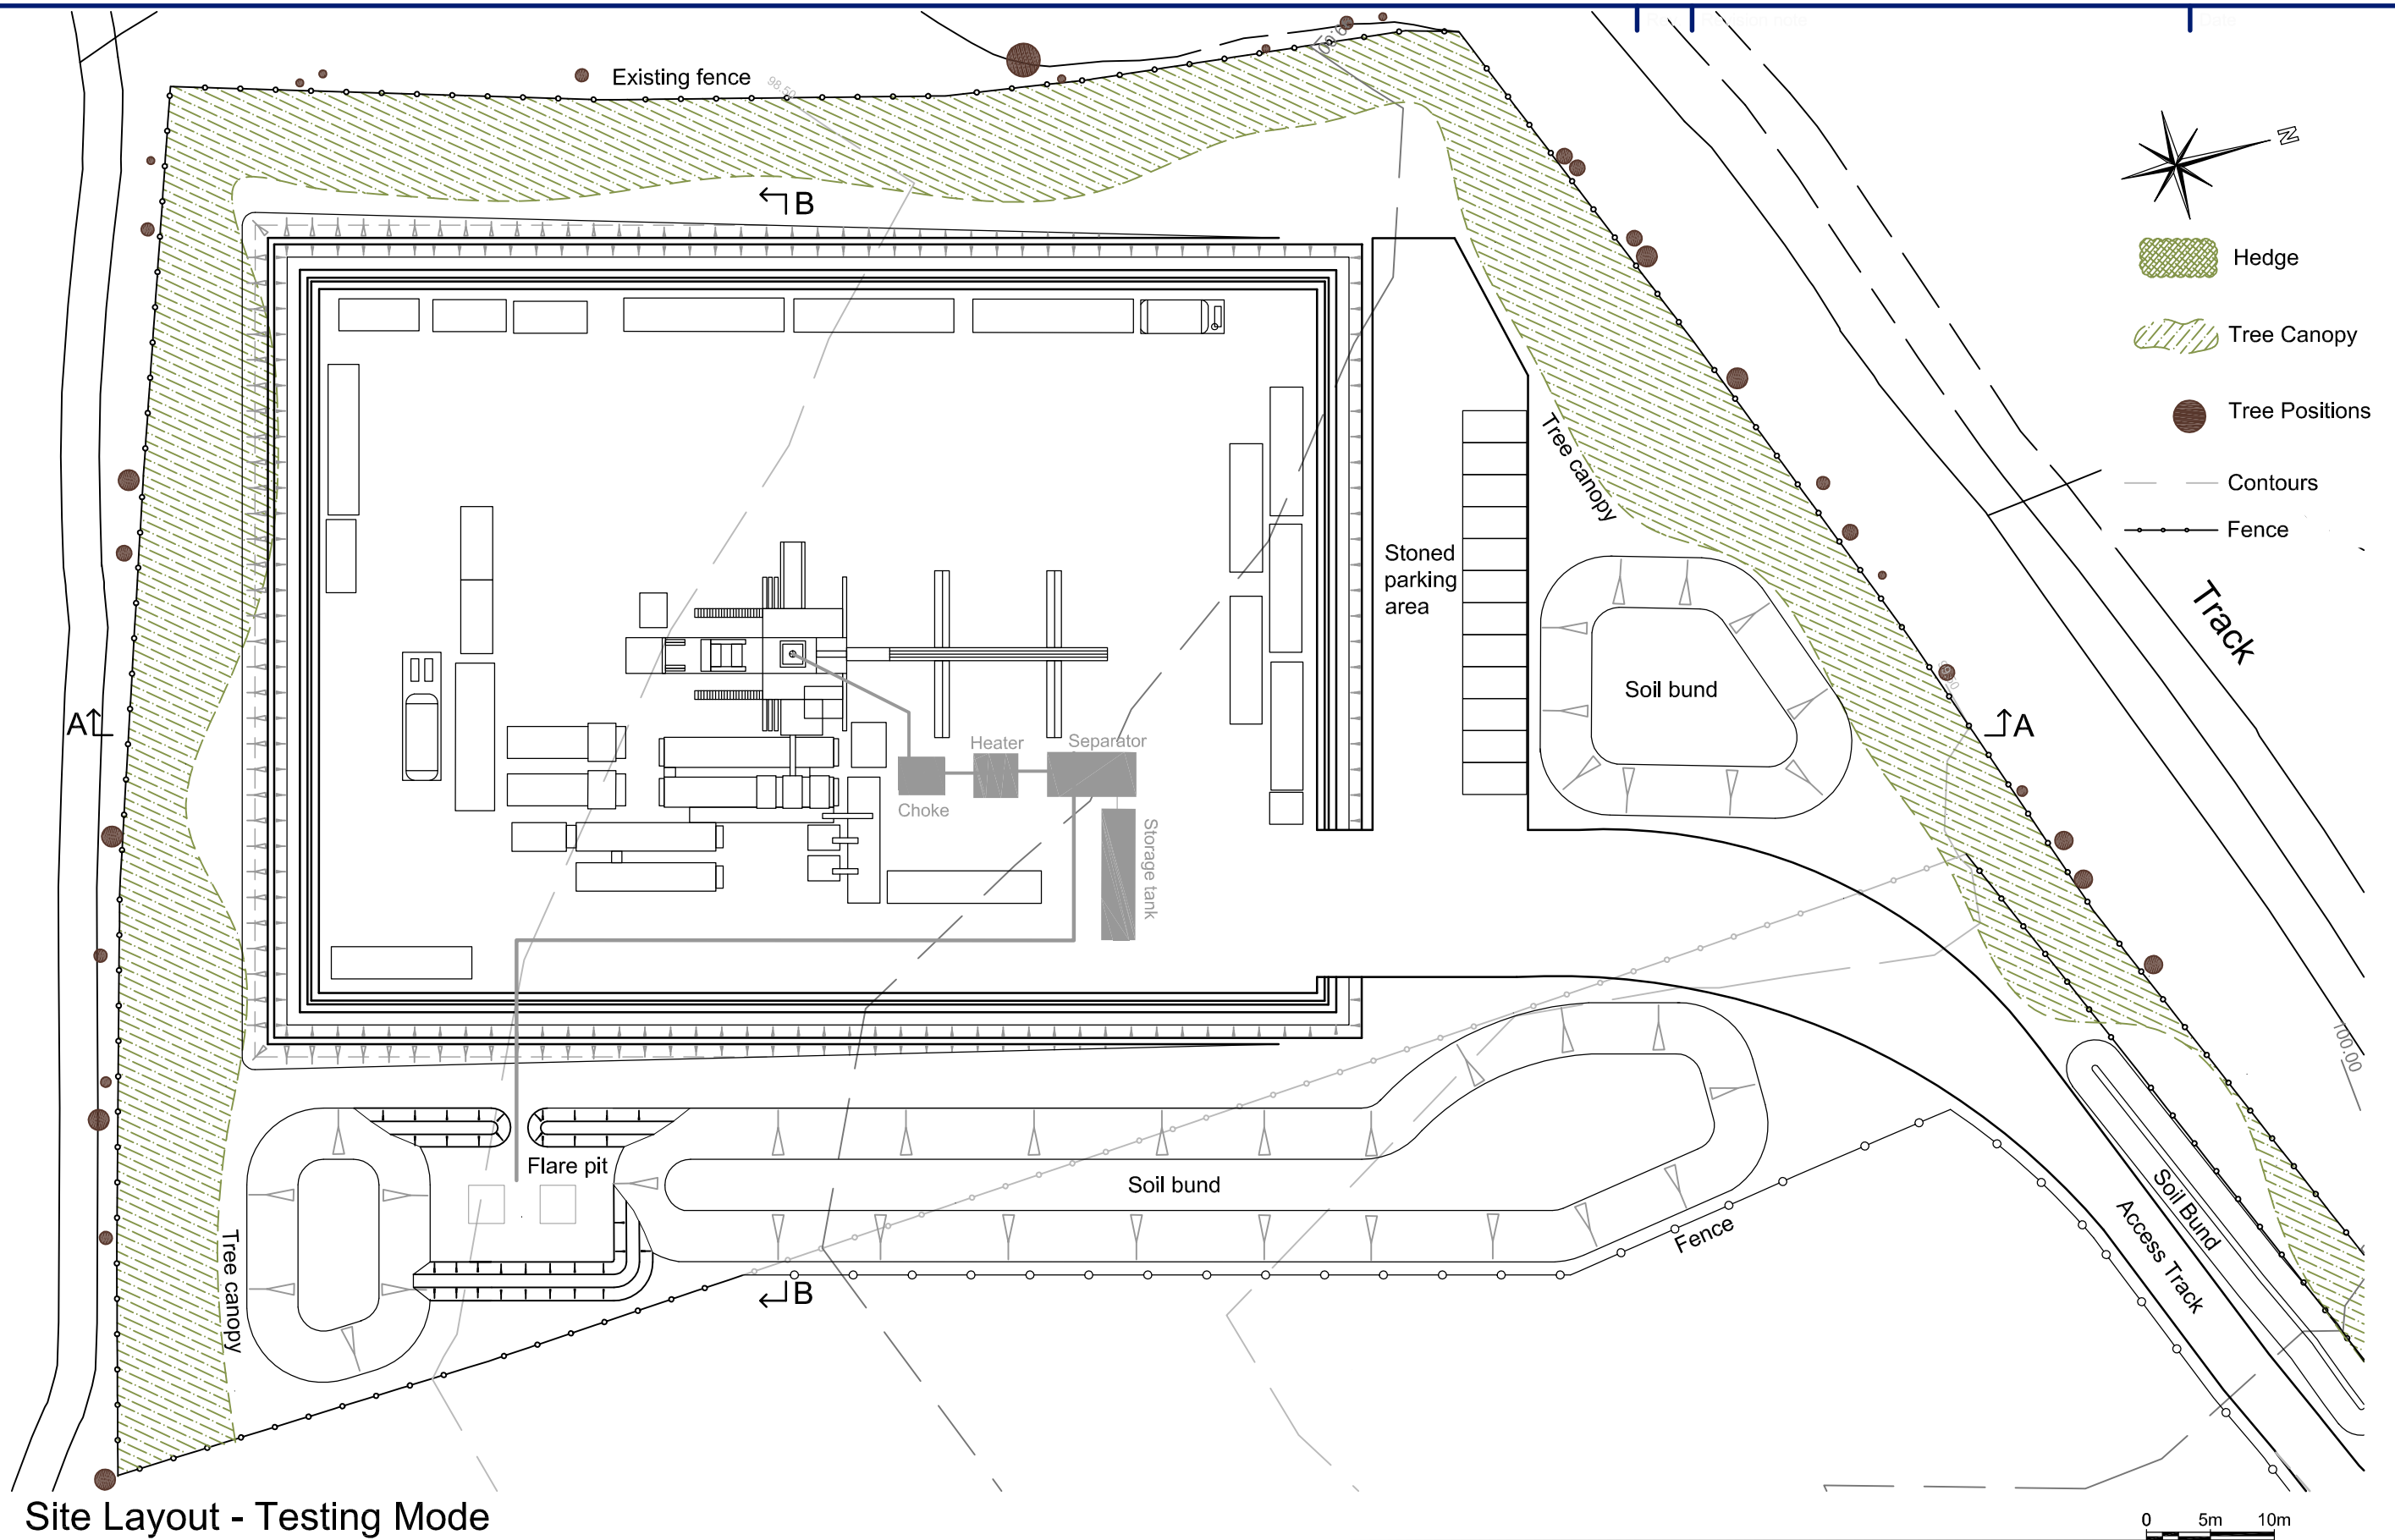

Site Layout - Testing Mode

Scale 1:500

0 5m 10m

R ELLIOTT ASSOCIATES LTD
 CONSULTING STRUCTURAL & CIVIL ENGINEERS

t: (01590) 683176 f: (01590) 683533 info@rea-ltd.co.uk www.rea-ltd.co.uk



Dennett House
 Brighton Road
 Sway
 Lymington
 Hampshire
 SO41 6EB

Client: Celtique Energie Petroleum
 Broadford Bridge
 West Sussex

Job Title: Broadford Bridge Site

Drawn By	Date	Sheet Size
AJNE	August 2012	A3
Drawing Title		
Site Layout - Testing Mode (1:500)		
Drawing Number		Revision
Figure 4.8		