
 


 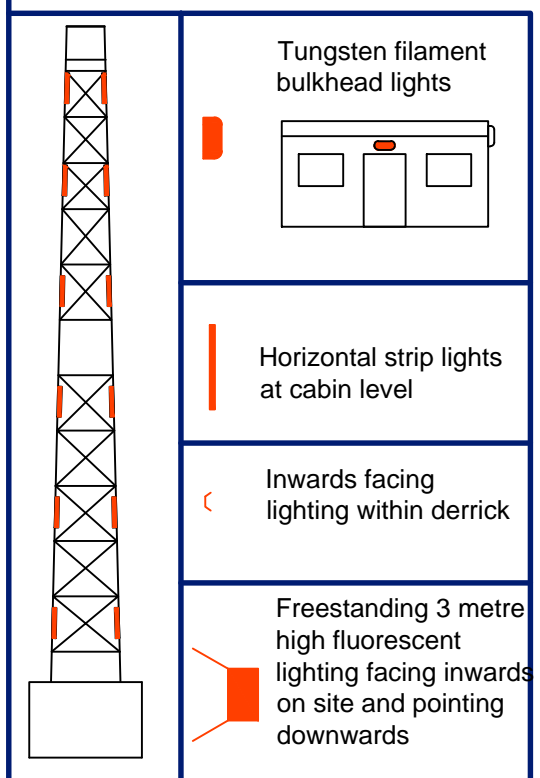



Proposed Site - Lighting Layout
Scale 1:500



-  Hedge
-  Tree Canopy
-  Tree Positions
-  Contours
-  Fence

R ELLIOTT ASSOCIATES LTD
CONSULTING STRUCTURAL & CIVIL ENGINEERS

t: (01590) 683176 f: (01590) 683533 info@rea-ltd.co.uk www.rea-ltd.co.uk

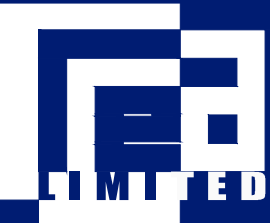

Dennett House
Brighton Road
Sway
Lymington
Hampshire
SO41 6EB

Client: Celtique Energie Petroleum
Boxal Bridge
Wisborough Green
West Sussex
Job Title: Wisborough Green-1

Drawn By: AJNE	Date: August 2013	Sheet Size: A2
Drawing Title: Proposed Site - Lighting Layout (1:500)		
Drawing Number: 3582 P 09	Revision: E	