








Figure 4.1: Timescales and Phasing of the Proposed Development

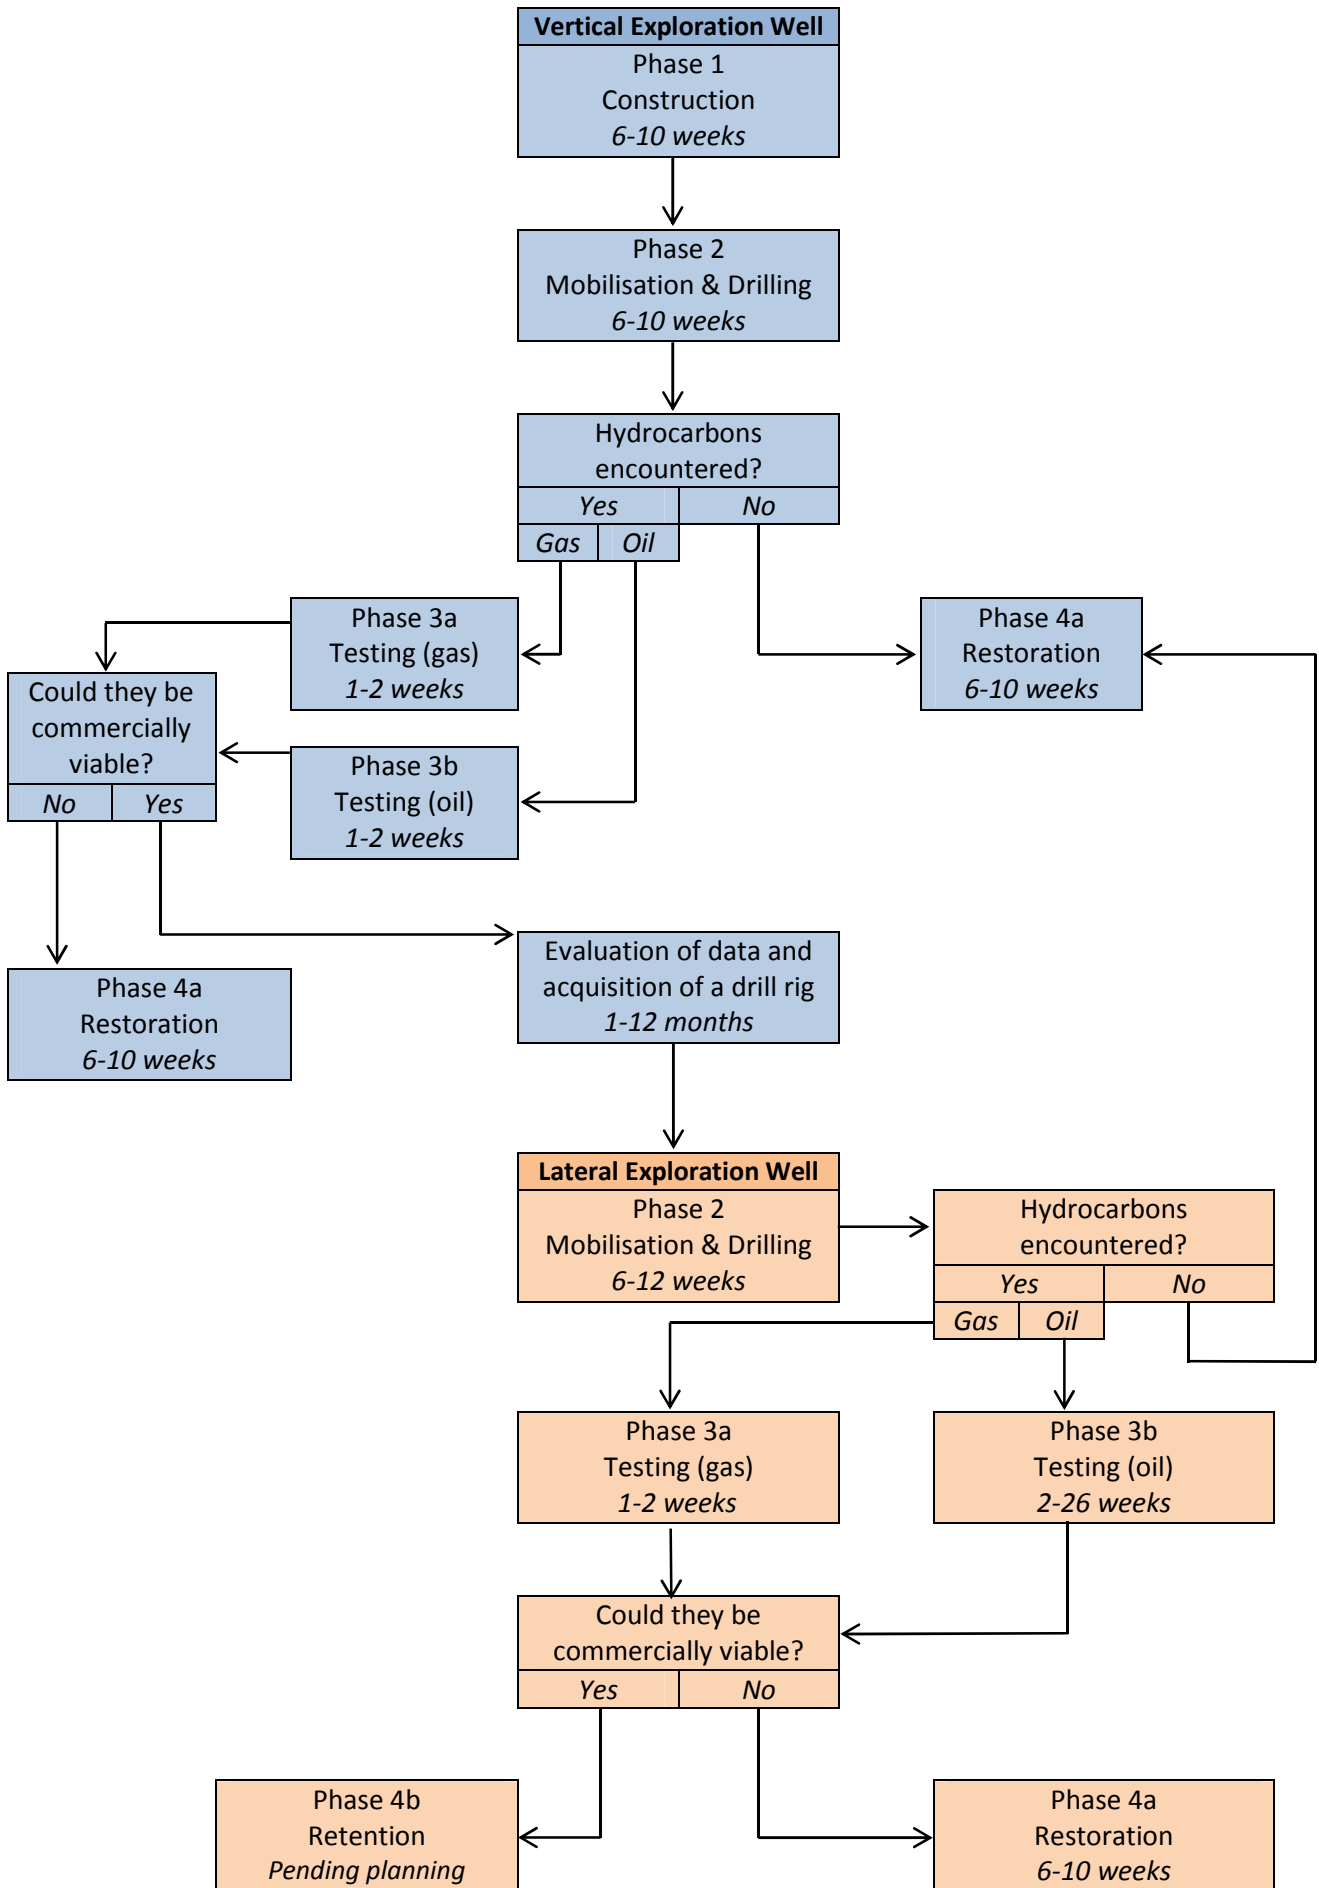

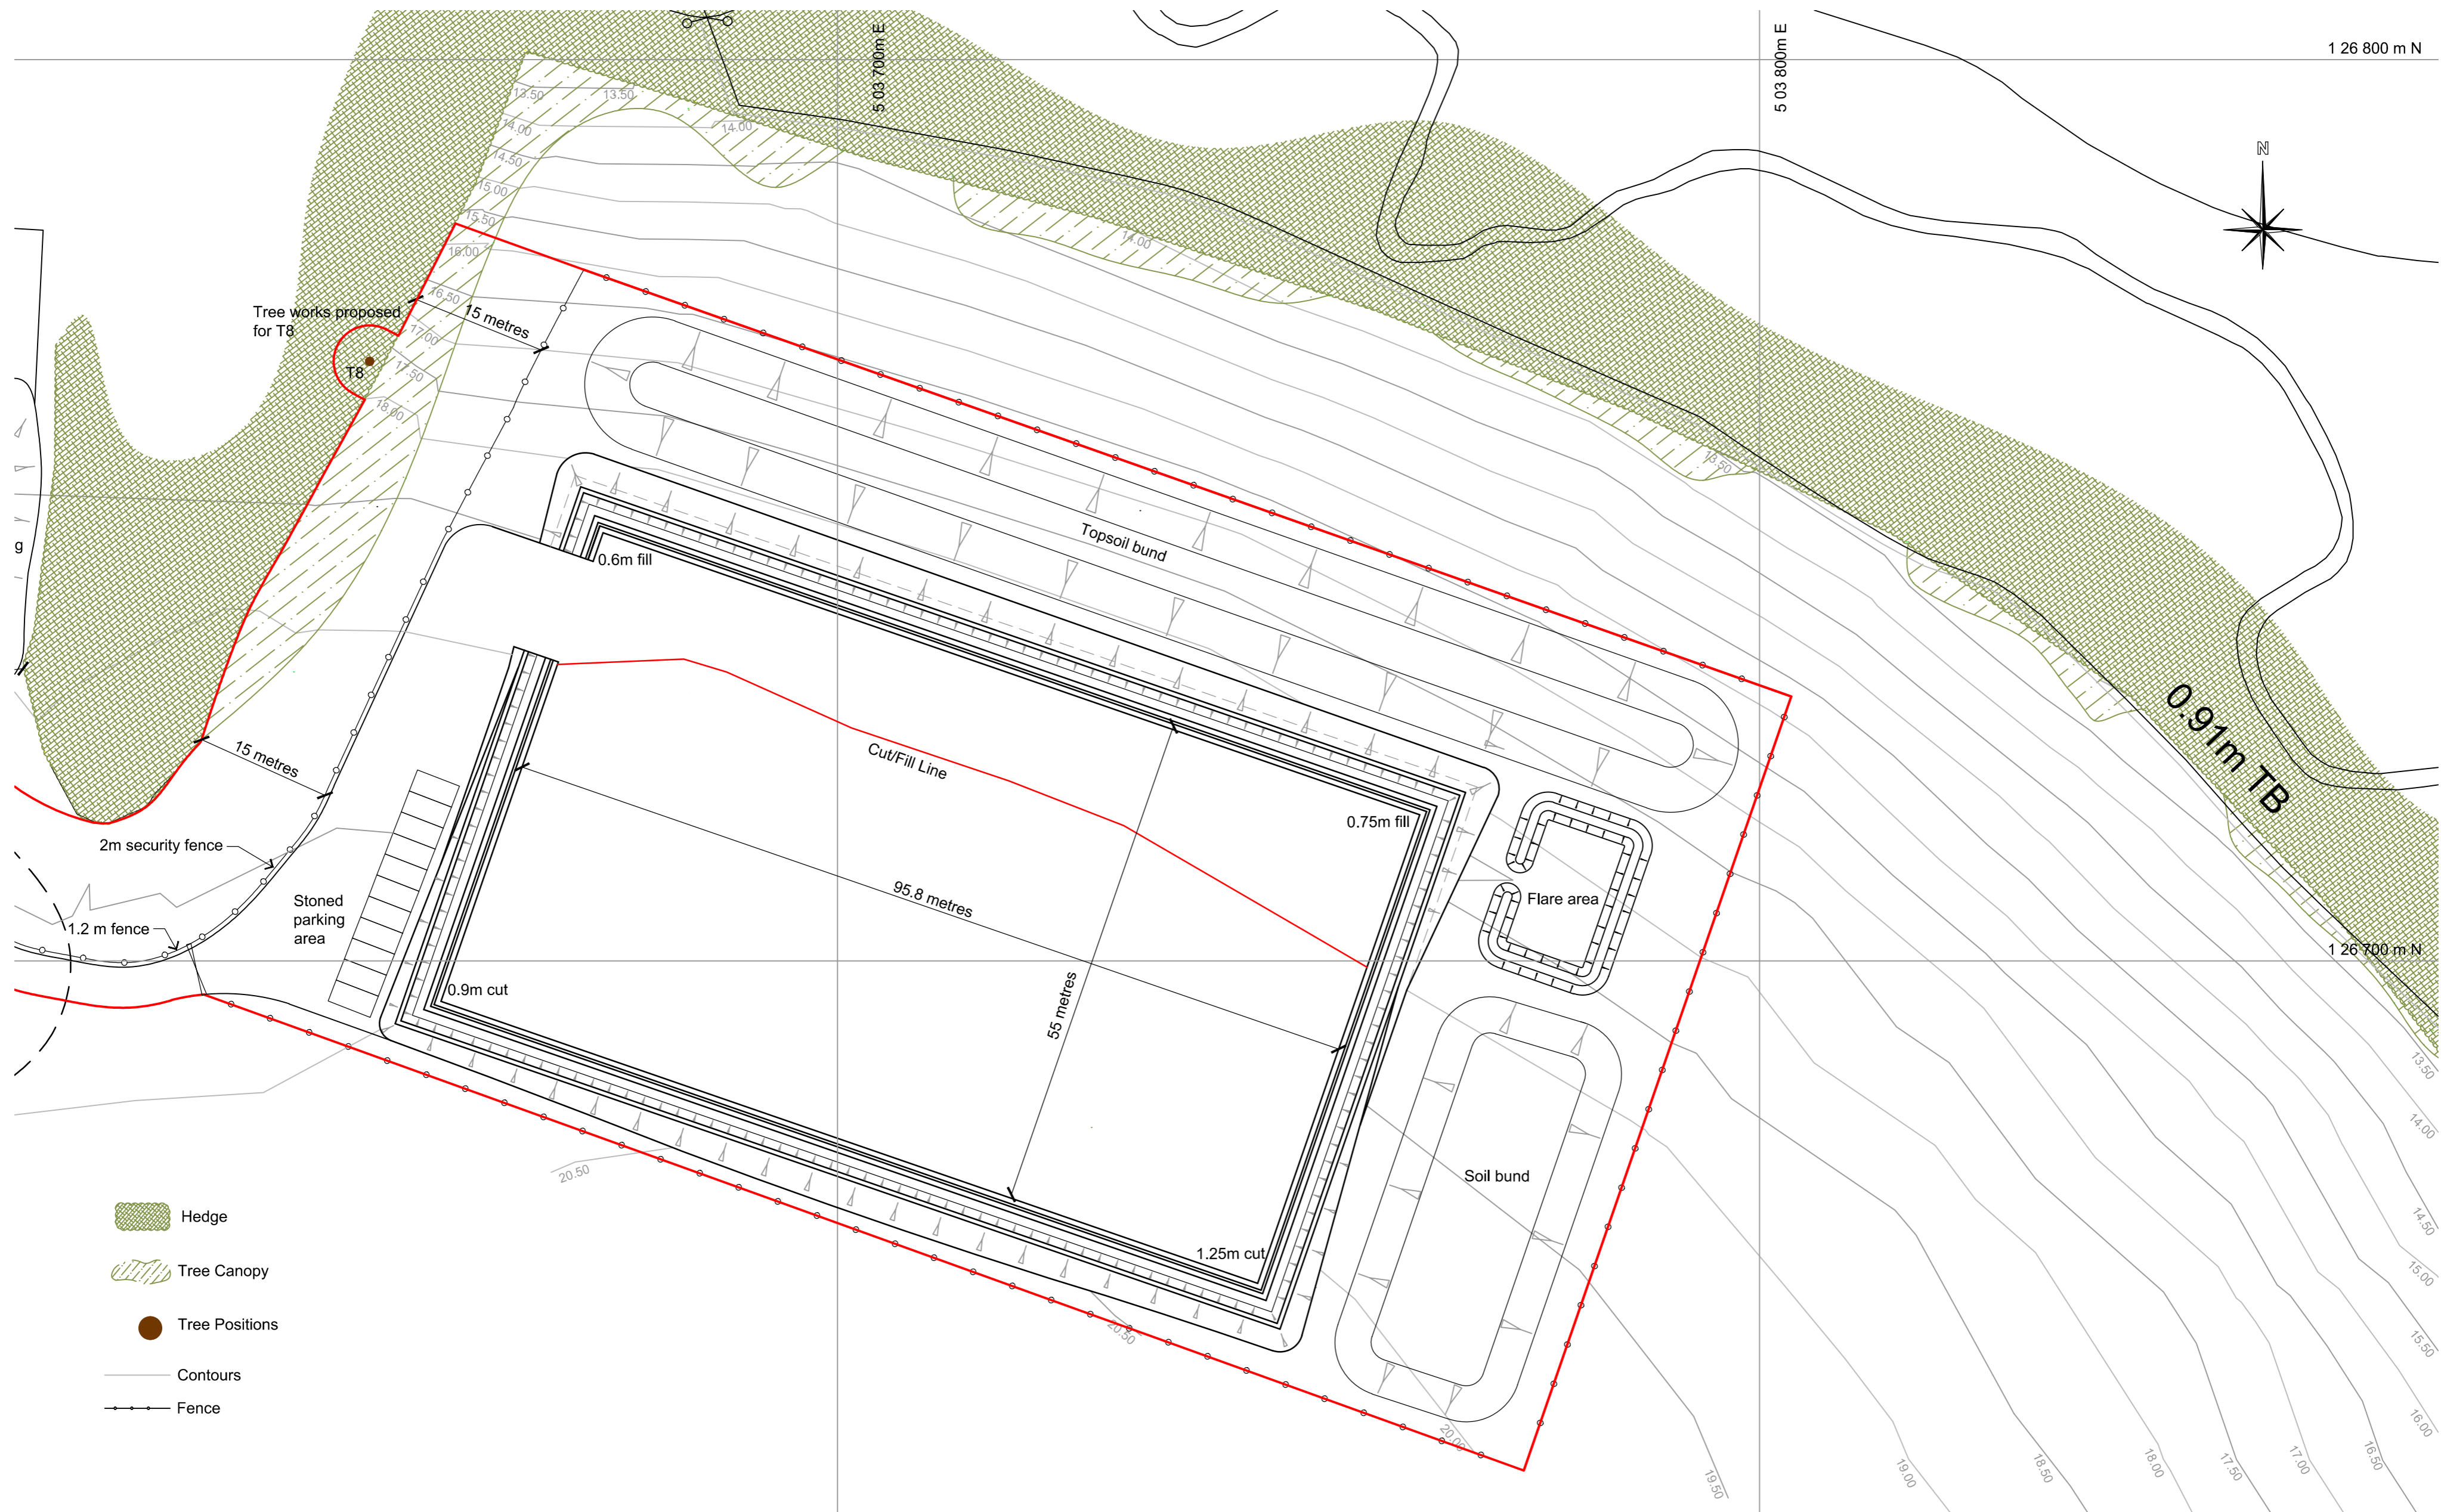

Proposed Site - Construction Mode

Scale 1:500

-  Hedge
-  Tree Canopy
-  Tree Positions
-  Contours
-  Fence

R ELLIOTT ASSOCIATES LTD
 CONSULTING STRUCTURAL & CIVIL ENGINEERS






t: (01590) 683176 f: (01590) 683533 info@rea-ltd.co.uk www.rea-ltd.co.uk



Dennett House
 Brighton Road
 Sway
 Lymington
 Hampshire
 SO41 6EB


Client Celtique Energie Petroleum Boxal Bridge Wisborough Green West Sussex	Drawn By AJNE	Date August 2013	Sheet Size A2
	Job Title Wisborough Green-1		
Drawing Number 3582 P 07		Revision D	

 

-  Hedge
-  Tree Canopy
-  Tree Positions
-  Contours
-  Fence

Access Track - Existing Ground Plan

 Scale 1:500



R ELLIOTT ASSOCIATES LTD
 CONSULTING STRUCTURAL & CIVIL ENGINEERS


t: (01590) 683176 f: (01590) 683533 info@rea-ltd.co.uk www.rea-ltd.co.uk



Dennett House
 Brighton Road
 Sway
 Lymington
 Hampshire
 SO41 6EB




Client **Celtique Energie Petroleum**
 Boxal Bridge
 Wisborough Green
 West Sussex
 Job Title **Wisborough Green-1**

Drawn By AJNE	Date August 2013	Sheet Size A3
Drawing Title Access Track - Existing Ground Plan (1:500)		
Drawing Number 3582 P 04	Revision D	

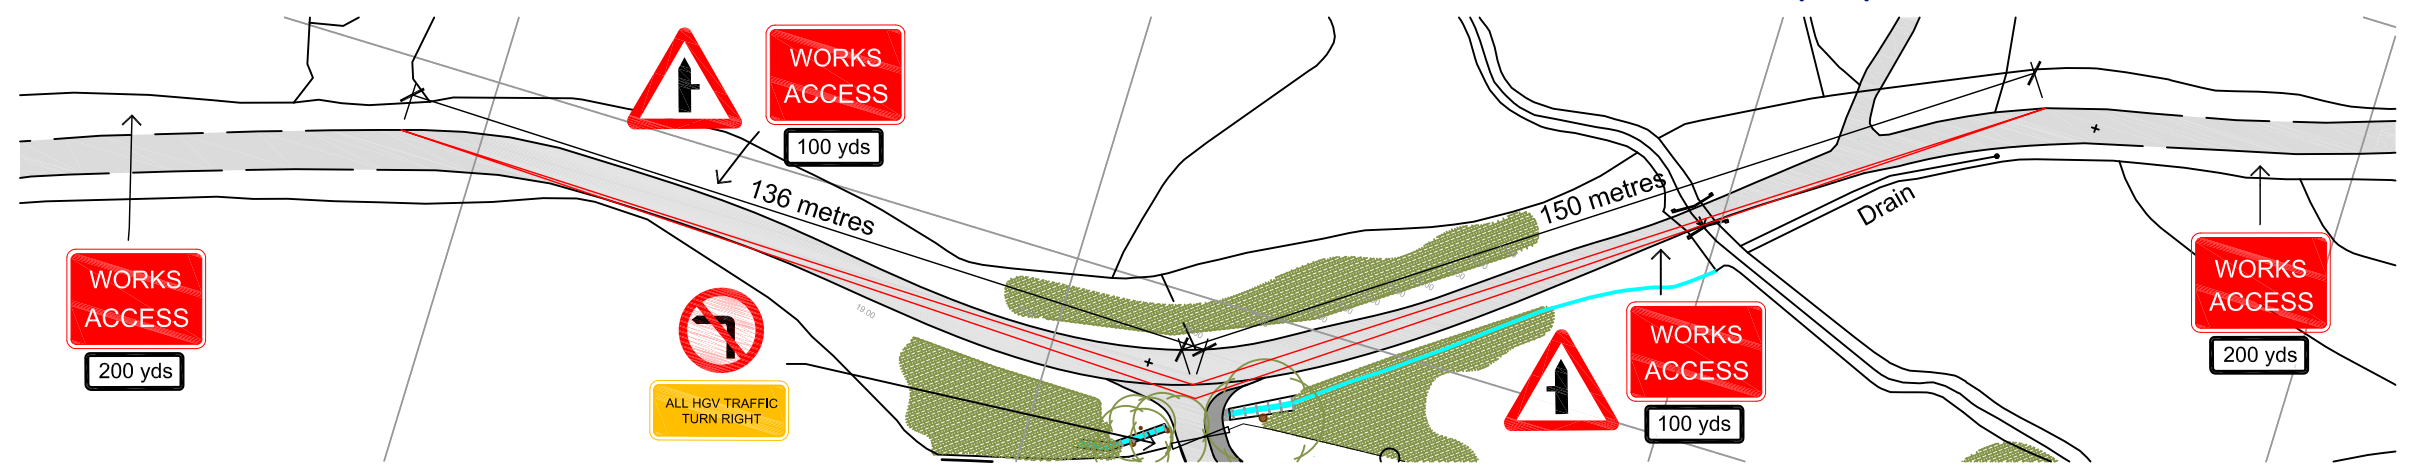



Sightlines

 Scale 1:1250

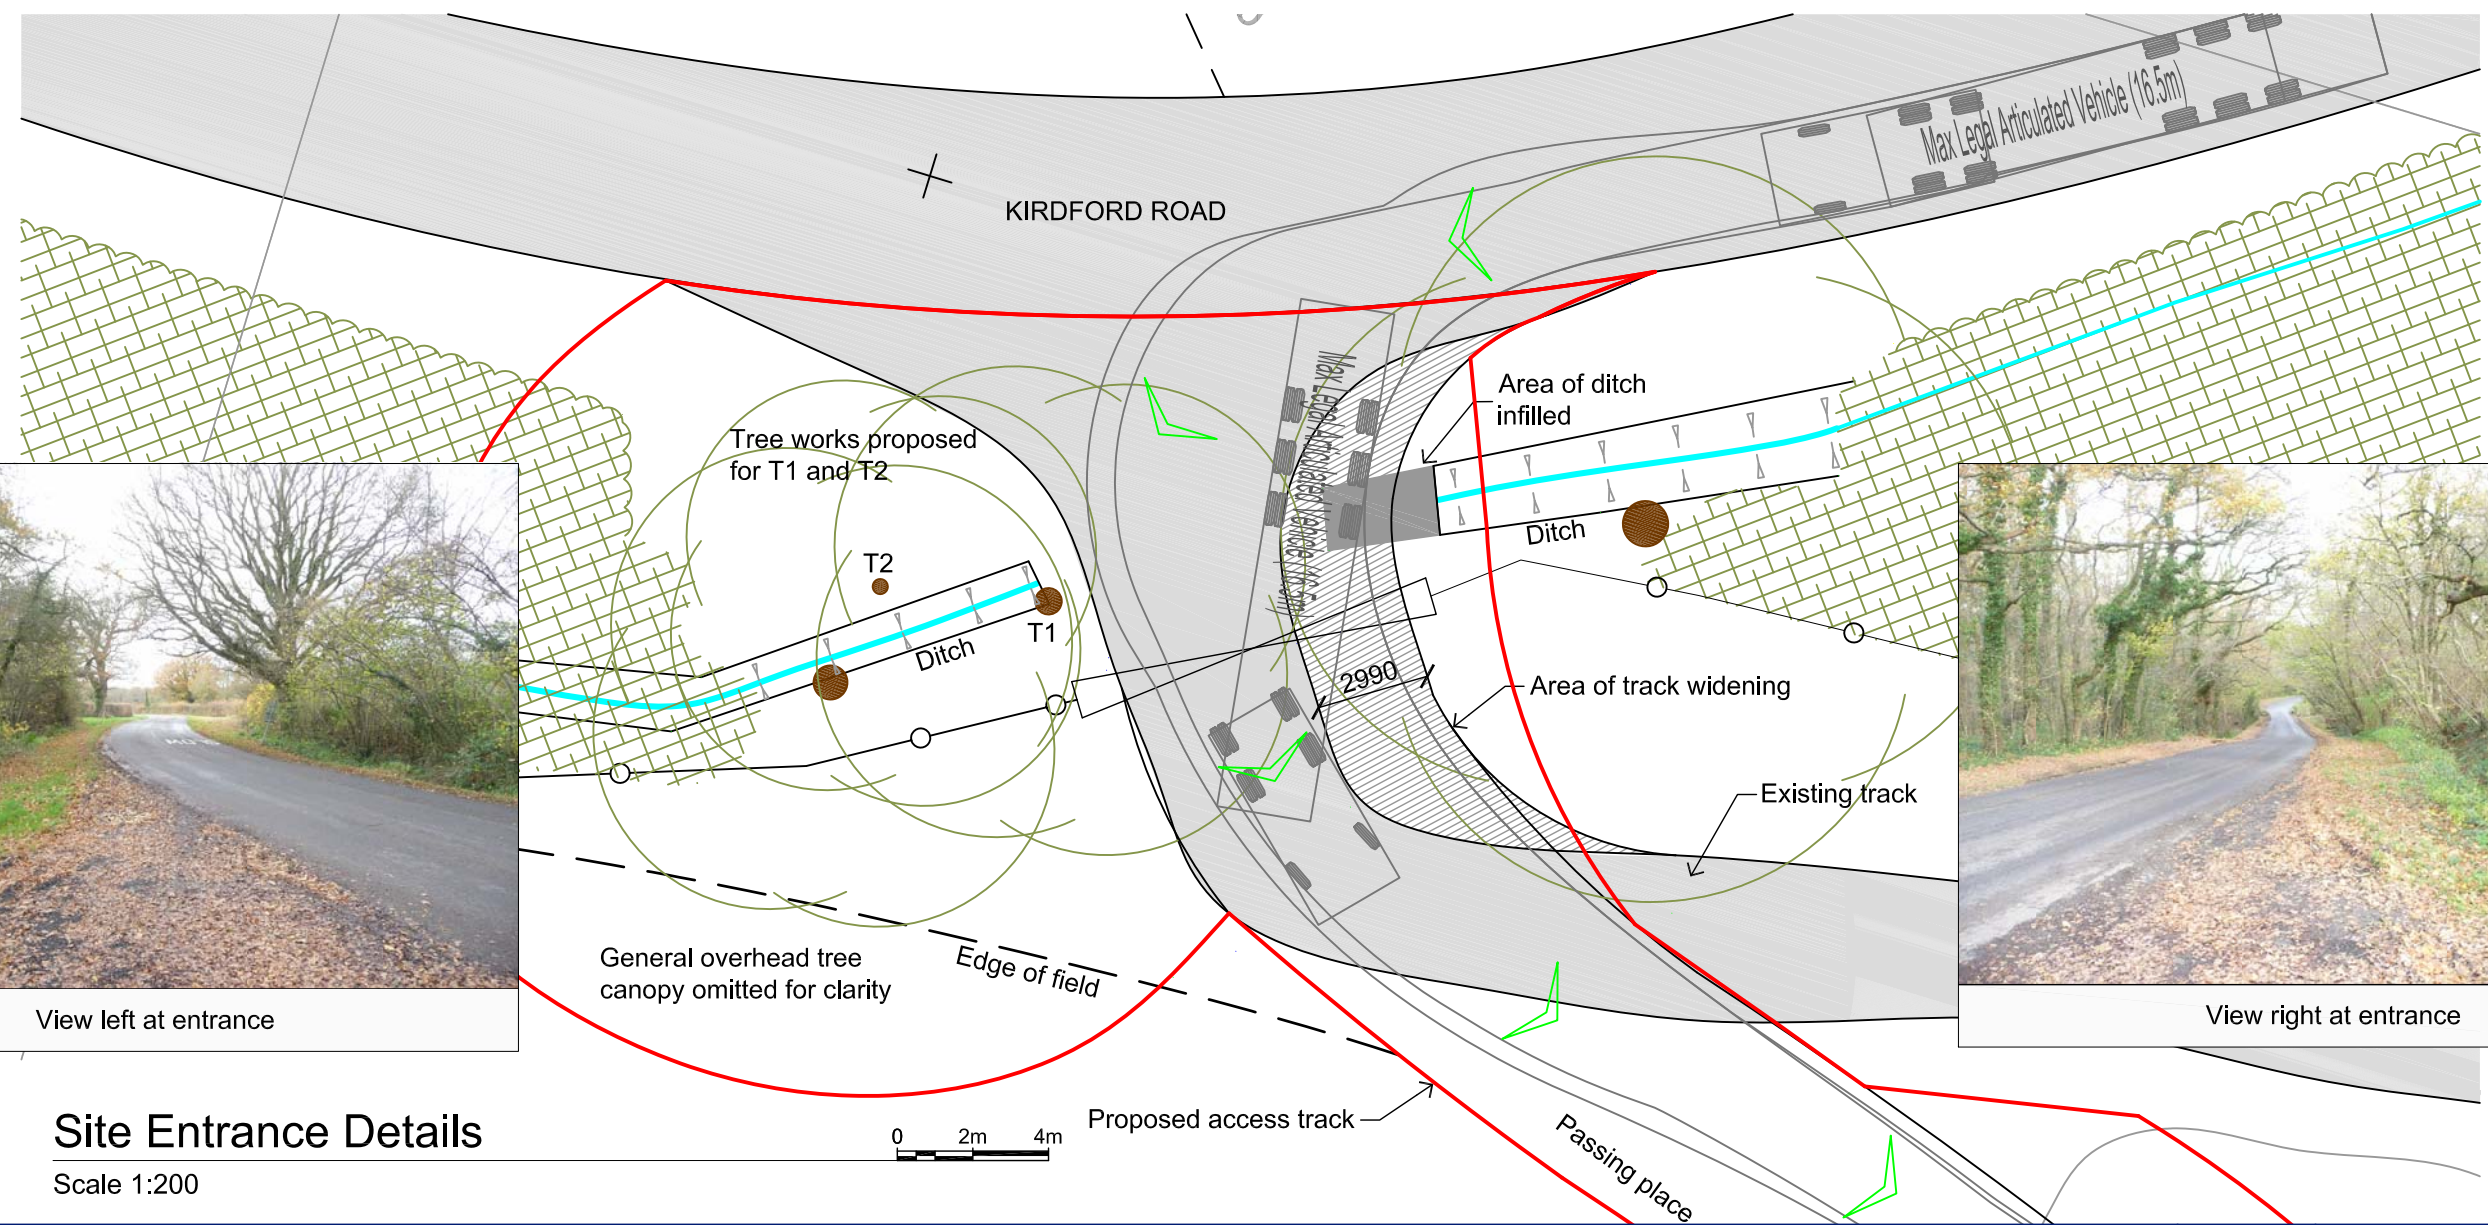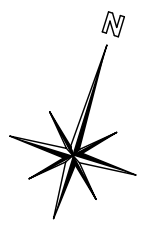

Site Entrance Details

 Scale 1:200

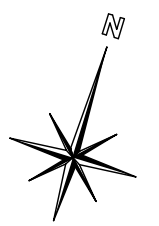

R ELLIOTT ASSOCIATES LTD
 CONSULTING STRUCTURAL & CIVIL ENGINEERS


t: (01590) 683176 f: (01590) 683533 info@rea-ltd.co.uk www.rea-ltd.co.uk



Dennett House
 Brighton Road
 Sway
 Lymington
 Hampshire
 SO41 6EB



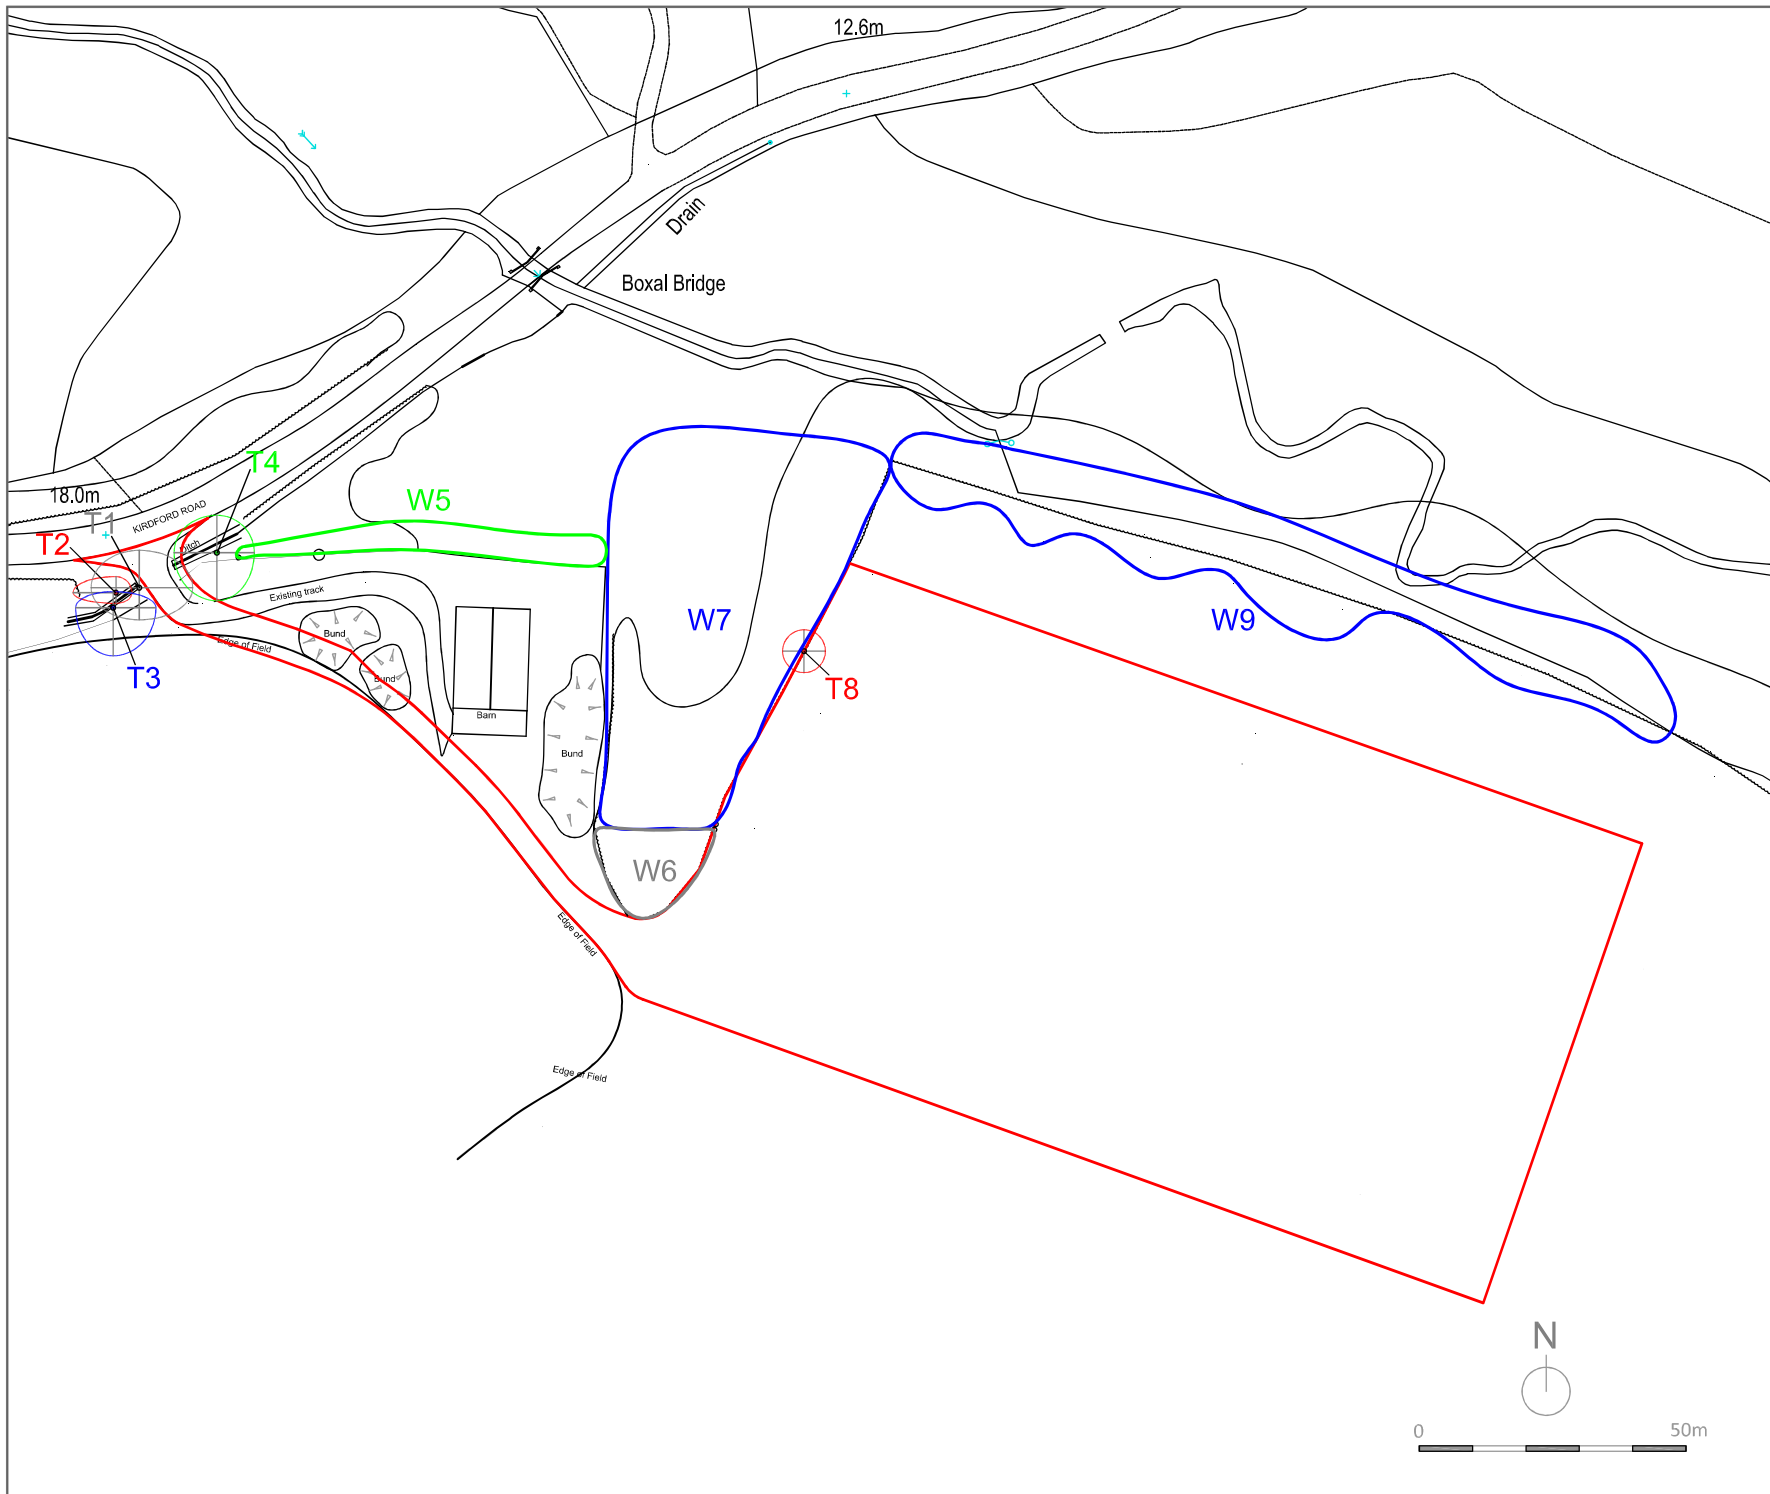

Client: Celtique Energie Petroleum
 Boxal Bridge
 Wisborough Green
 West Sussex
 Job Title: Wisborough Green-1

Drawn By	Date	Sheet Size
AJNE	August 2013	A3
Drawing Title		
Sightlines & Site Entrance Plan (1:1250, 1:200)		
Drawing Number	Revision	
3582 P 18	C	



 Site Boundary

TREE CATEGORIES:

-  **Category A**
Those of high quality and value: in such a condition as to be able to make a substantial contribution (a minimum of 40 years is suggested).
-  **Category B**
Those of moderate quality and value: those in such a condition as to make a significant contribution (a minimum of 20 years is suggested).
-  **Category C**
Those of low quality and value: currently in adequate condition to remain until new planting could be established (a minimum of 10 years is suggested), or young trees with a stem diameter below 150mm.
-  **Category U**
Those in such a condition that any existing value would be lost within 10 years and which should, in the current context, be removed for reasons of sound arboricultural management.



The Environmental Dimension Partnership
14 Inner Courtyard, Whiteway Farmhouse
The Whiteway, Cirencester GL7 7BA

t 01285 640640
f 01285 652545
e info@edp-uk.co.uk
w www.edp-uk.co.uk

client
Celtique Energie Weald Ltd.

project title
Wisborough Green, West Sussex - Exploratory Well Site

 
drawing title
Plan EDP 1: Tree Survey Plan



date **19 MARCH 2013**
drawing number **EDP1902/04**
scale **1:1000 @A3**
drawn by **DS**
checked **JM**



Access Track - Proposed Ground Plan

Scale 1:2,500



-  Hedge
-  Tree Canopy
-  Tree Positions
-  Contours
-  Fence


R ELLIOTT ASSOCIATES LTD
 CONSULTING STRUCTURAL & CIVIL ENGINEERS






t: (01590) 683176 f: (01590) 683533 info@rea-ltd.co.uk www.rea-ltd.co.uk

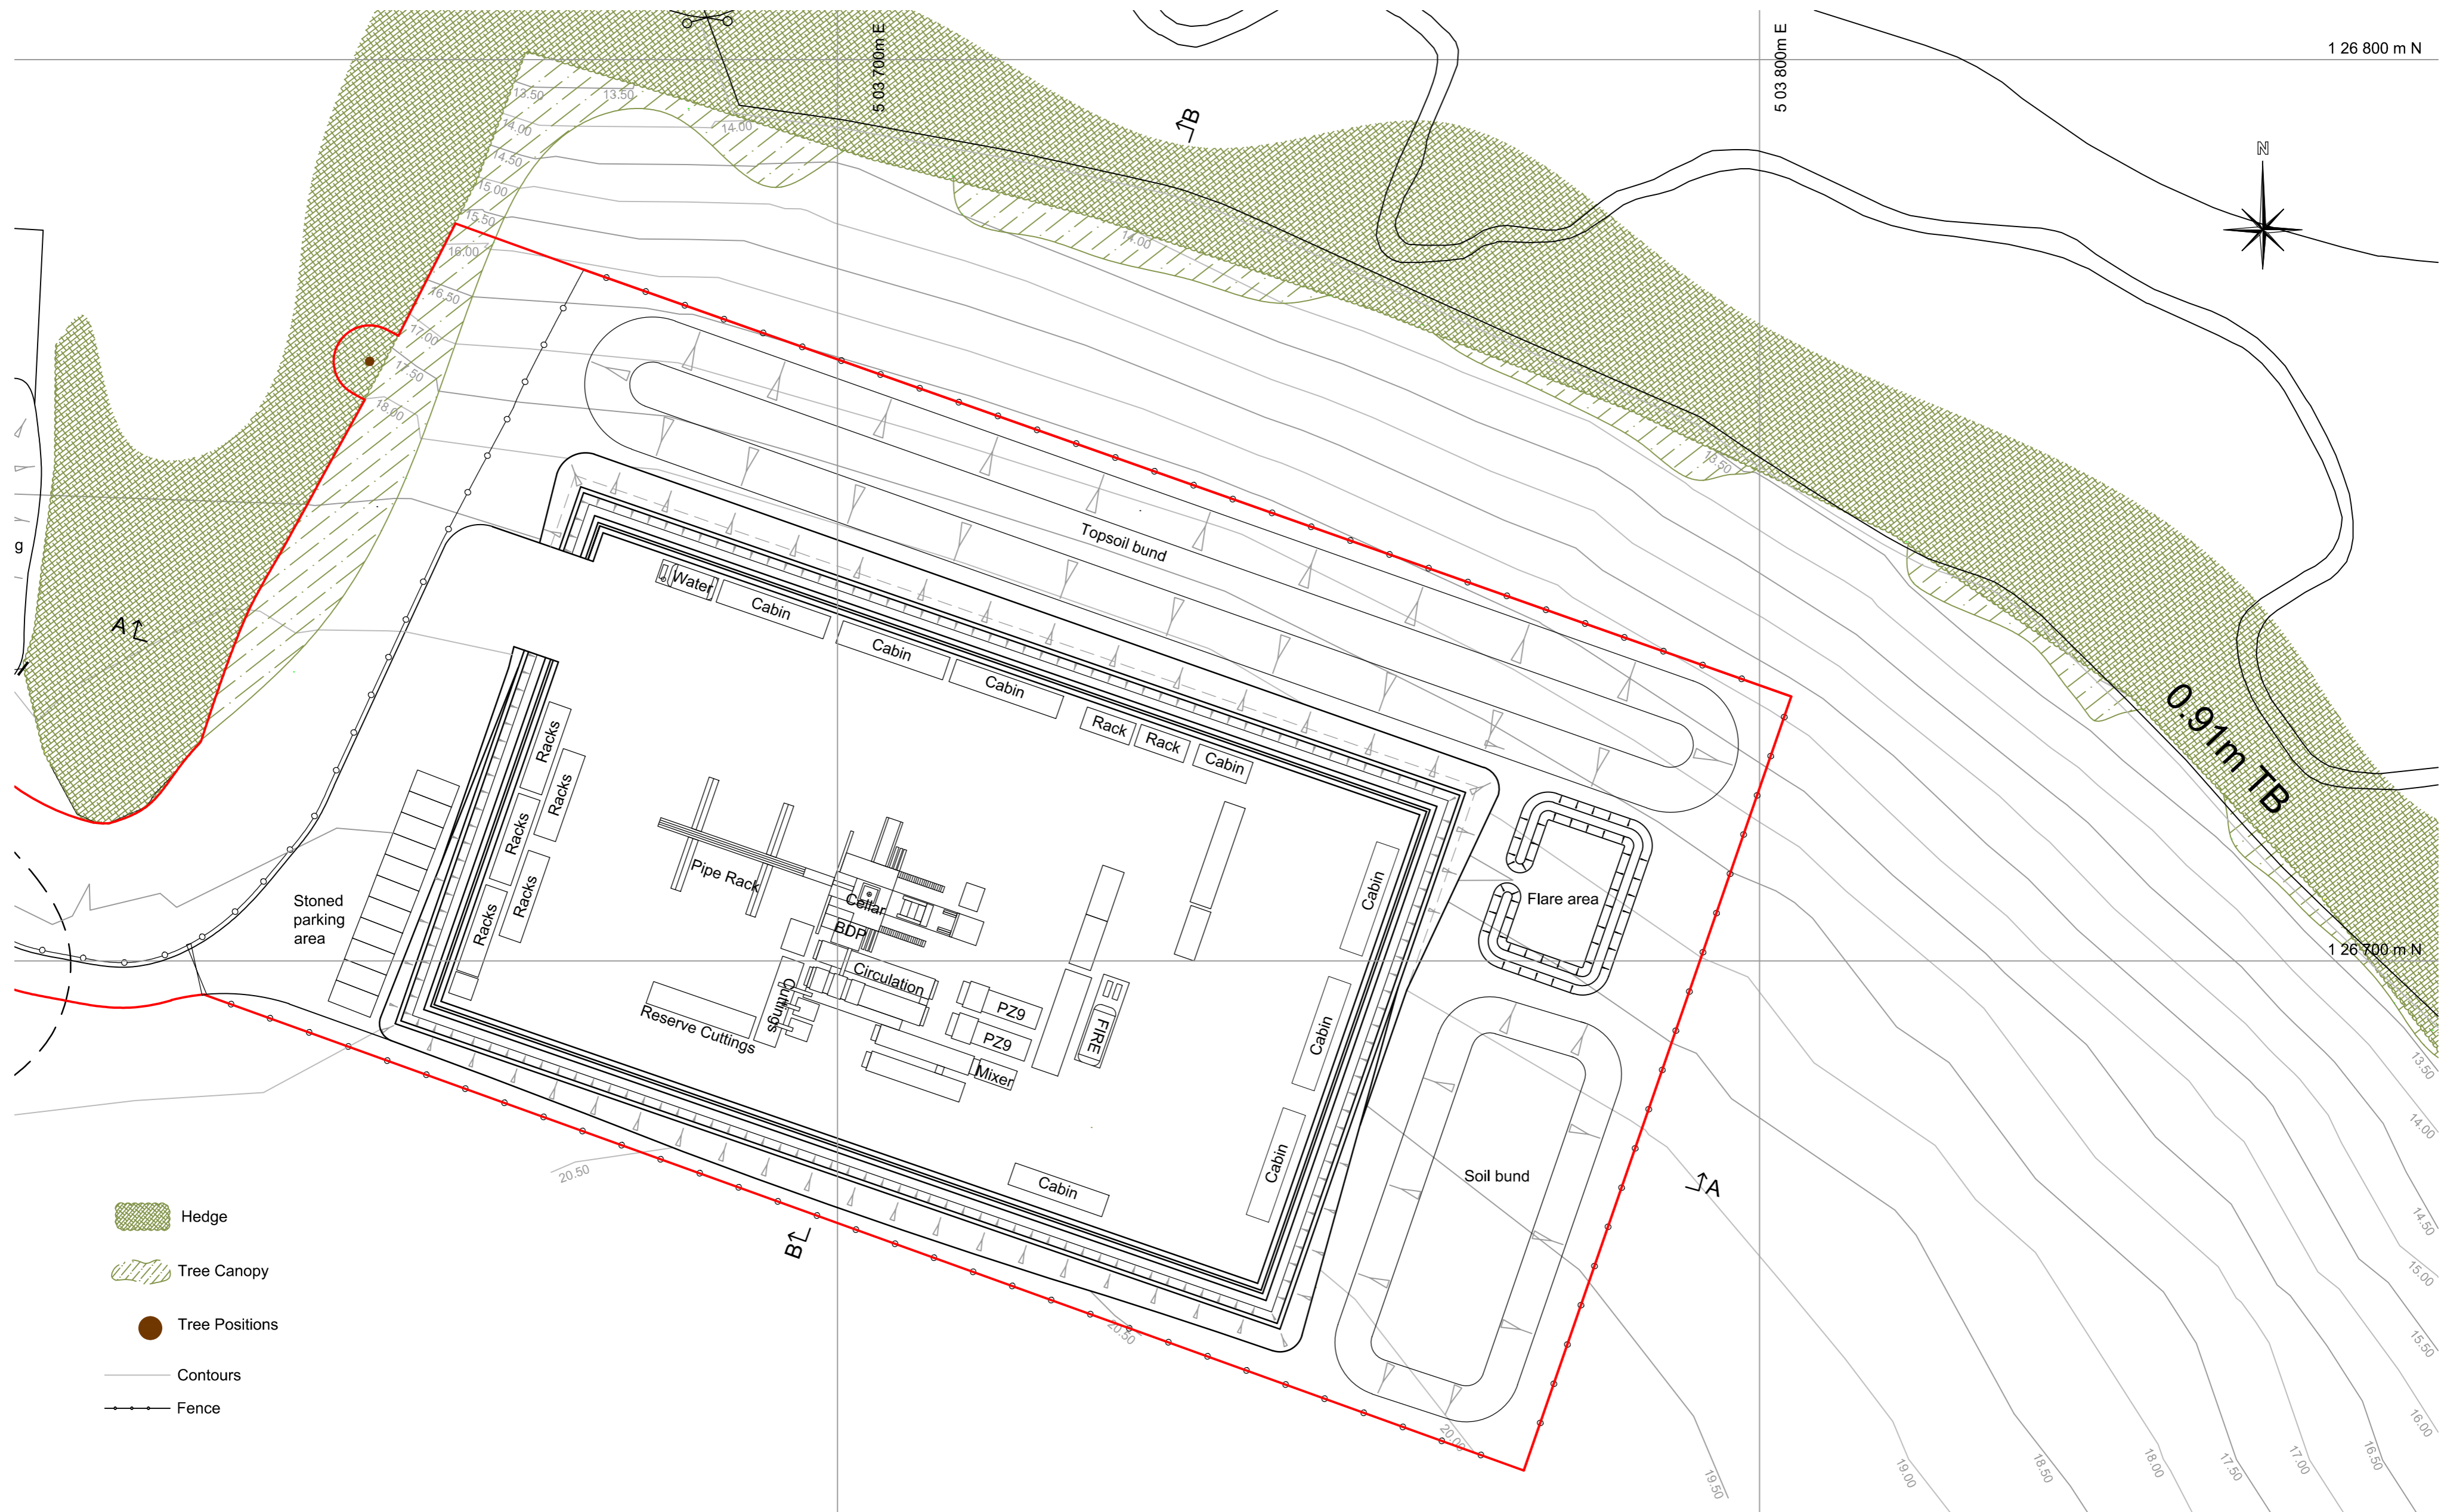

Dennett House
 Brighton Road
 Sway
 Lymington
 Hampshire
 SO41 6EB

Client	Celtique Energie Petroleum Boxal Bridge Wisborough Green West Sussex	Drawn By	AJNE	Date	August 2013	Sheet Size	A3
Job Title	Wisborough Green-1	Drawing Title		Access Track - Proposed Ground Plan (1:500)		Revision	
		Drawing Number	3582 P 06		C		



-  Hedge
-  Tree Canopy
-  Tree Positions
-  Contours
-  Fence

Proposed Site - Drilling Mode
Scale 1:500

0 5m 10m

R ELLIOTT ASSOCIATES LTD


CONSULTING STRUCTURAL & CIVIL ENGINEERS

t: (01590) 683176 f: (01590) 683533 info@rea-ltd.co.uk www.rea-ltd.co.uk




Dennett House
Brighton Road
Sway
Lymington
Hampshire
SO41 6EB

Client Celtique Energie Petroleum Boxal Bridge Wisborough Green West Sussex	Drawn By AJNE	Date August 2013	Sheet Size A2
	Job Title Wisborough Green-1		
Drawing Number 3582 P 08		Revision E	

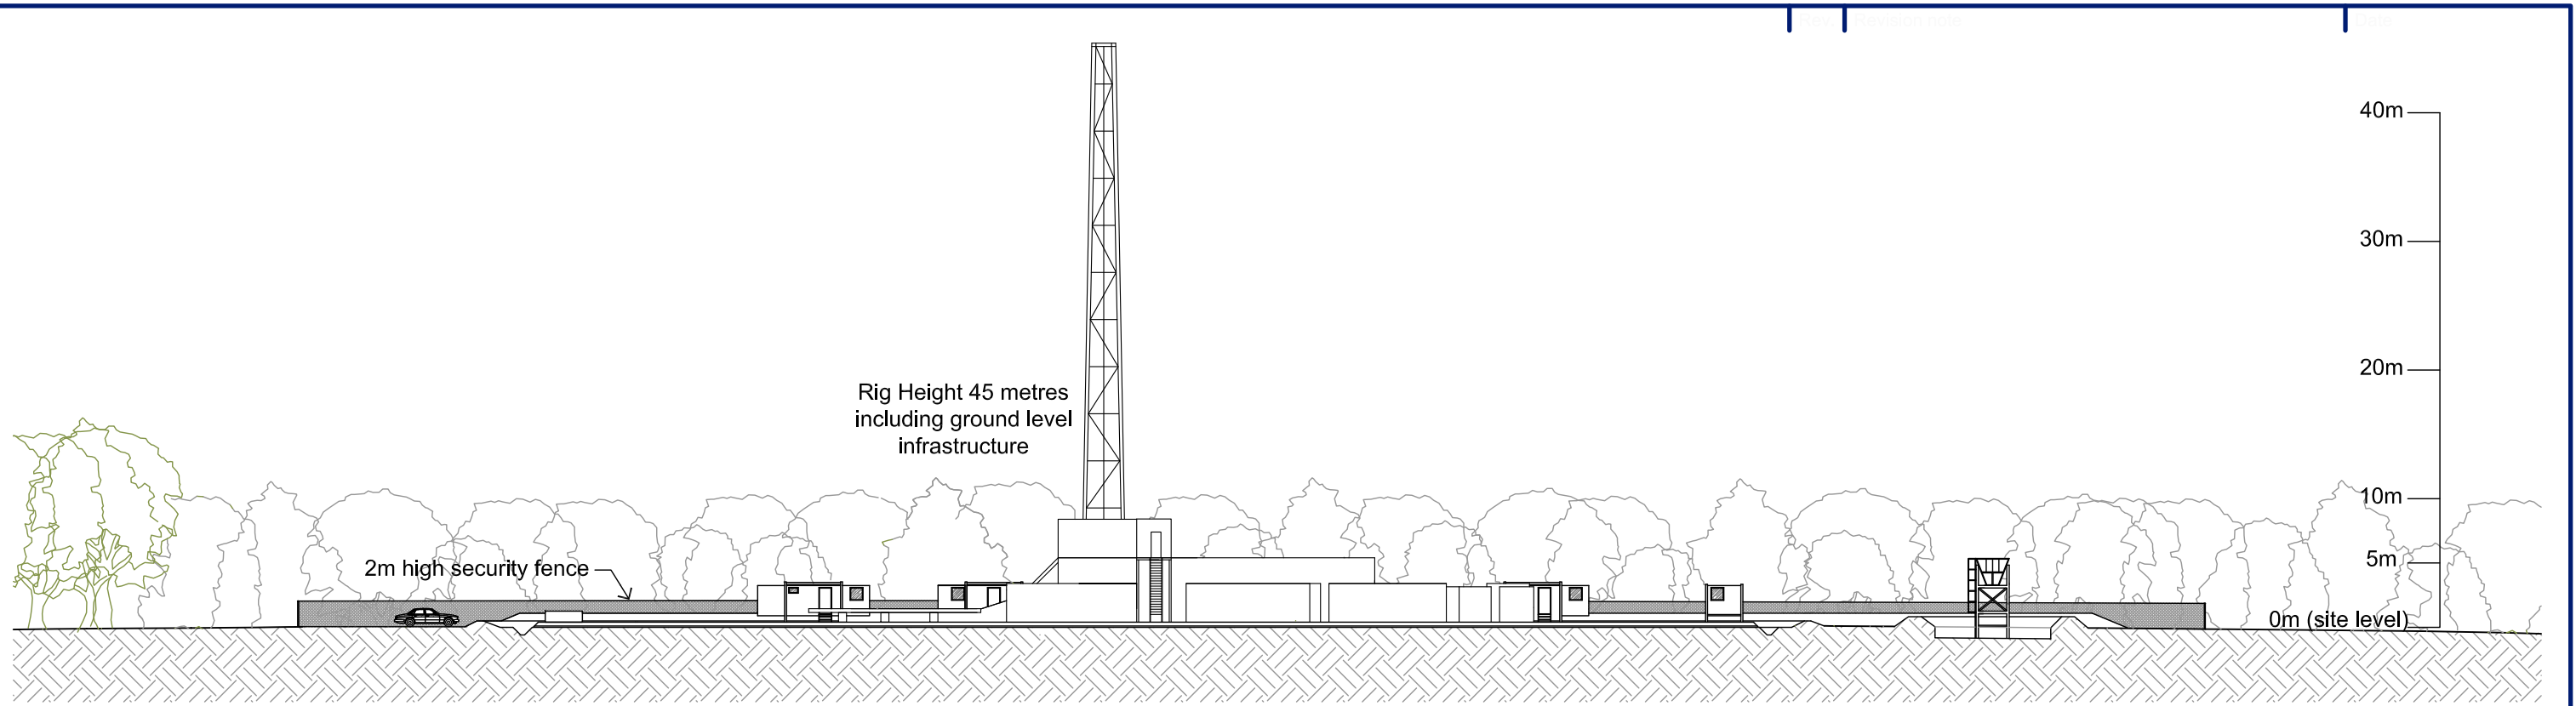


Proposed Site - Section A-A

Scale 1:500

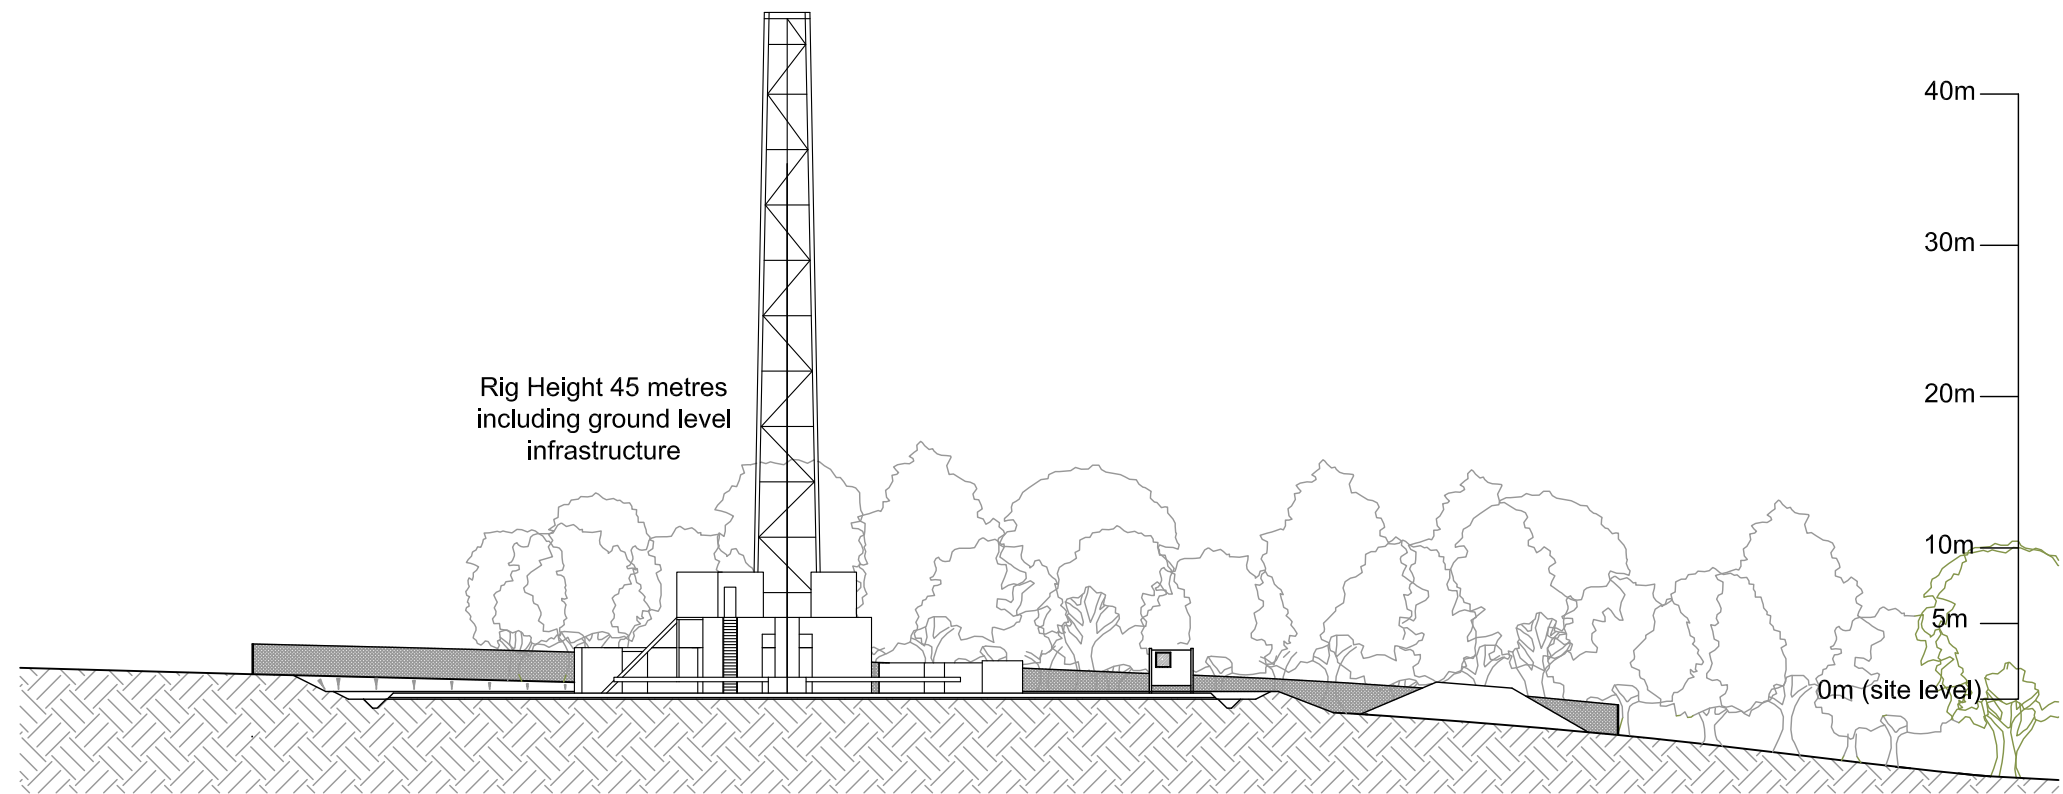

Proposed Site - Section B-B

 Scale 1:500




R ELLIOTT ASSOCIATES LTD
 CONSULTING STRUCTURAL & CIVIL ENGINEERS

t: (01590) 683176 f: (01590) 683533 info@rea-ltd.co.uk www.rea-ltd.co.uk




Dennett House
 Brighton Road
 Sway
 Lymington
 Hampshire
 SO41 6EB


Client	Celtique Energie Petroleum Boxal Bridge Wisborough Green West Sussex	Drawn By	AJNE	Date	August 2013	Sheet Size	A3	
Job Title	Wisborough Green-1	Drawing Title	Proposed Site Sections Drilling Mode (1:500)				Revision	D
		Drawing Number	3582 P 14					

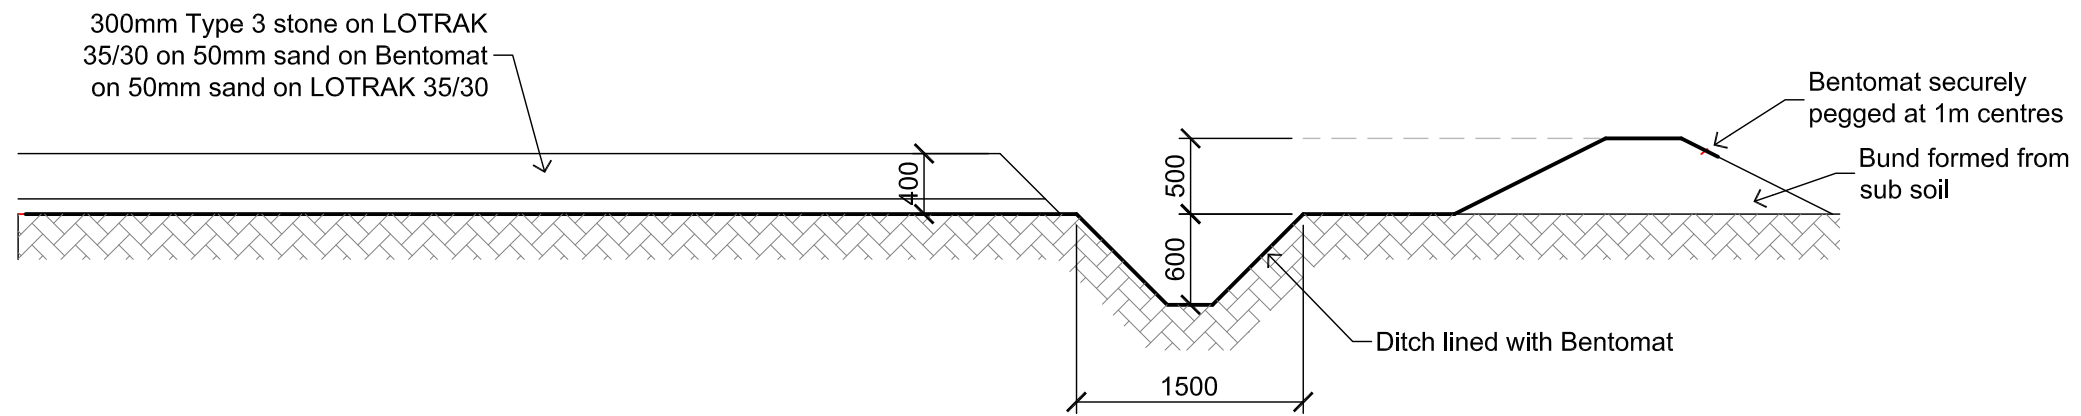

TYPICAL DITCH CONSTRUCTION IN FILL

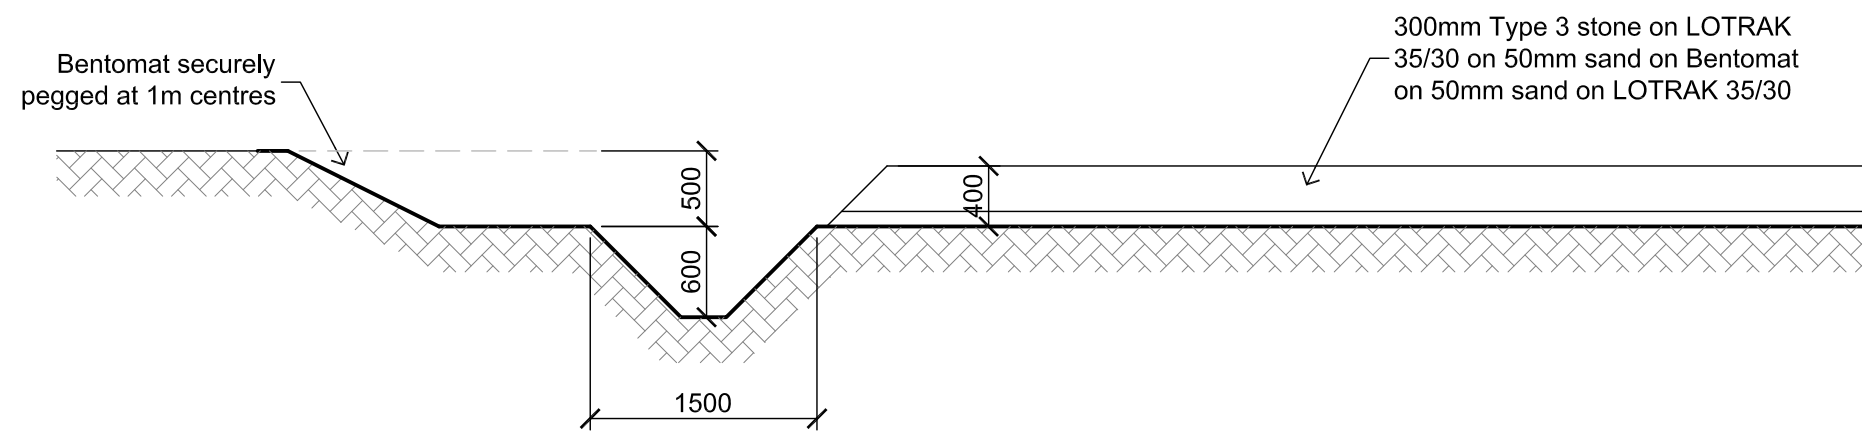

TYPICAL DITCH CONSTRUCTION IN CUT

 

R ELLIOTT ASSOCIATES LTD
CONSULTING STRUCTURAL & CIVIL ENGINEERS

t: (01590) 683176 f: (01590) 683533 info@rea-ltd.co.uk www.rea-ltd.co.uk



Dennett House
Brighton Road
Sway
Lymington
Hampshire
SO41 6EB

Client: Celtique Energie Petroleum
Boxal Bridge
Wisborough Green
West Sussex
Job Title: Wisborough Green-1

Drawn By	Date	Sheet Size
AJNE	April 2013	A3
Drawing Title		
Site Construction Sections (1:50)		
Drawing Number	Revision	
3582 P 17	B	

Site Photos – An example of the layout and equipment used for an Extended Well Test (EWT)





◀ Temporary Produced Oil and Water Storage tanks in a bunded area for an EWT with scaffolding access to permit tank sampling and measurements








◀ General layout on the wellsite for EWT showing base of pumping unit on the right, pump control unit on the left and tanks in the background

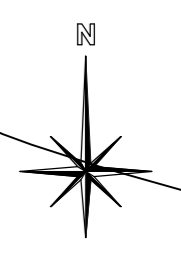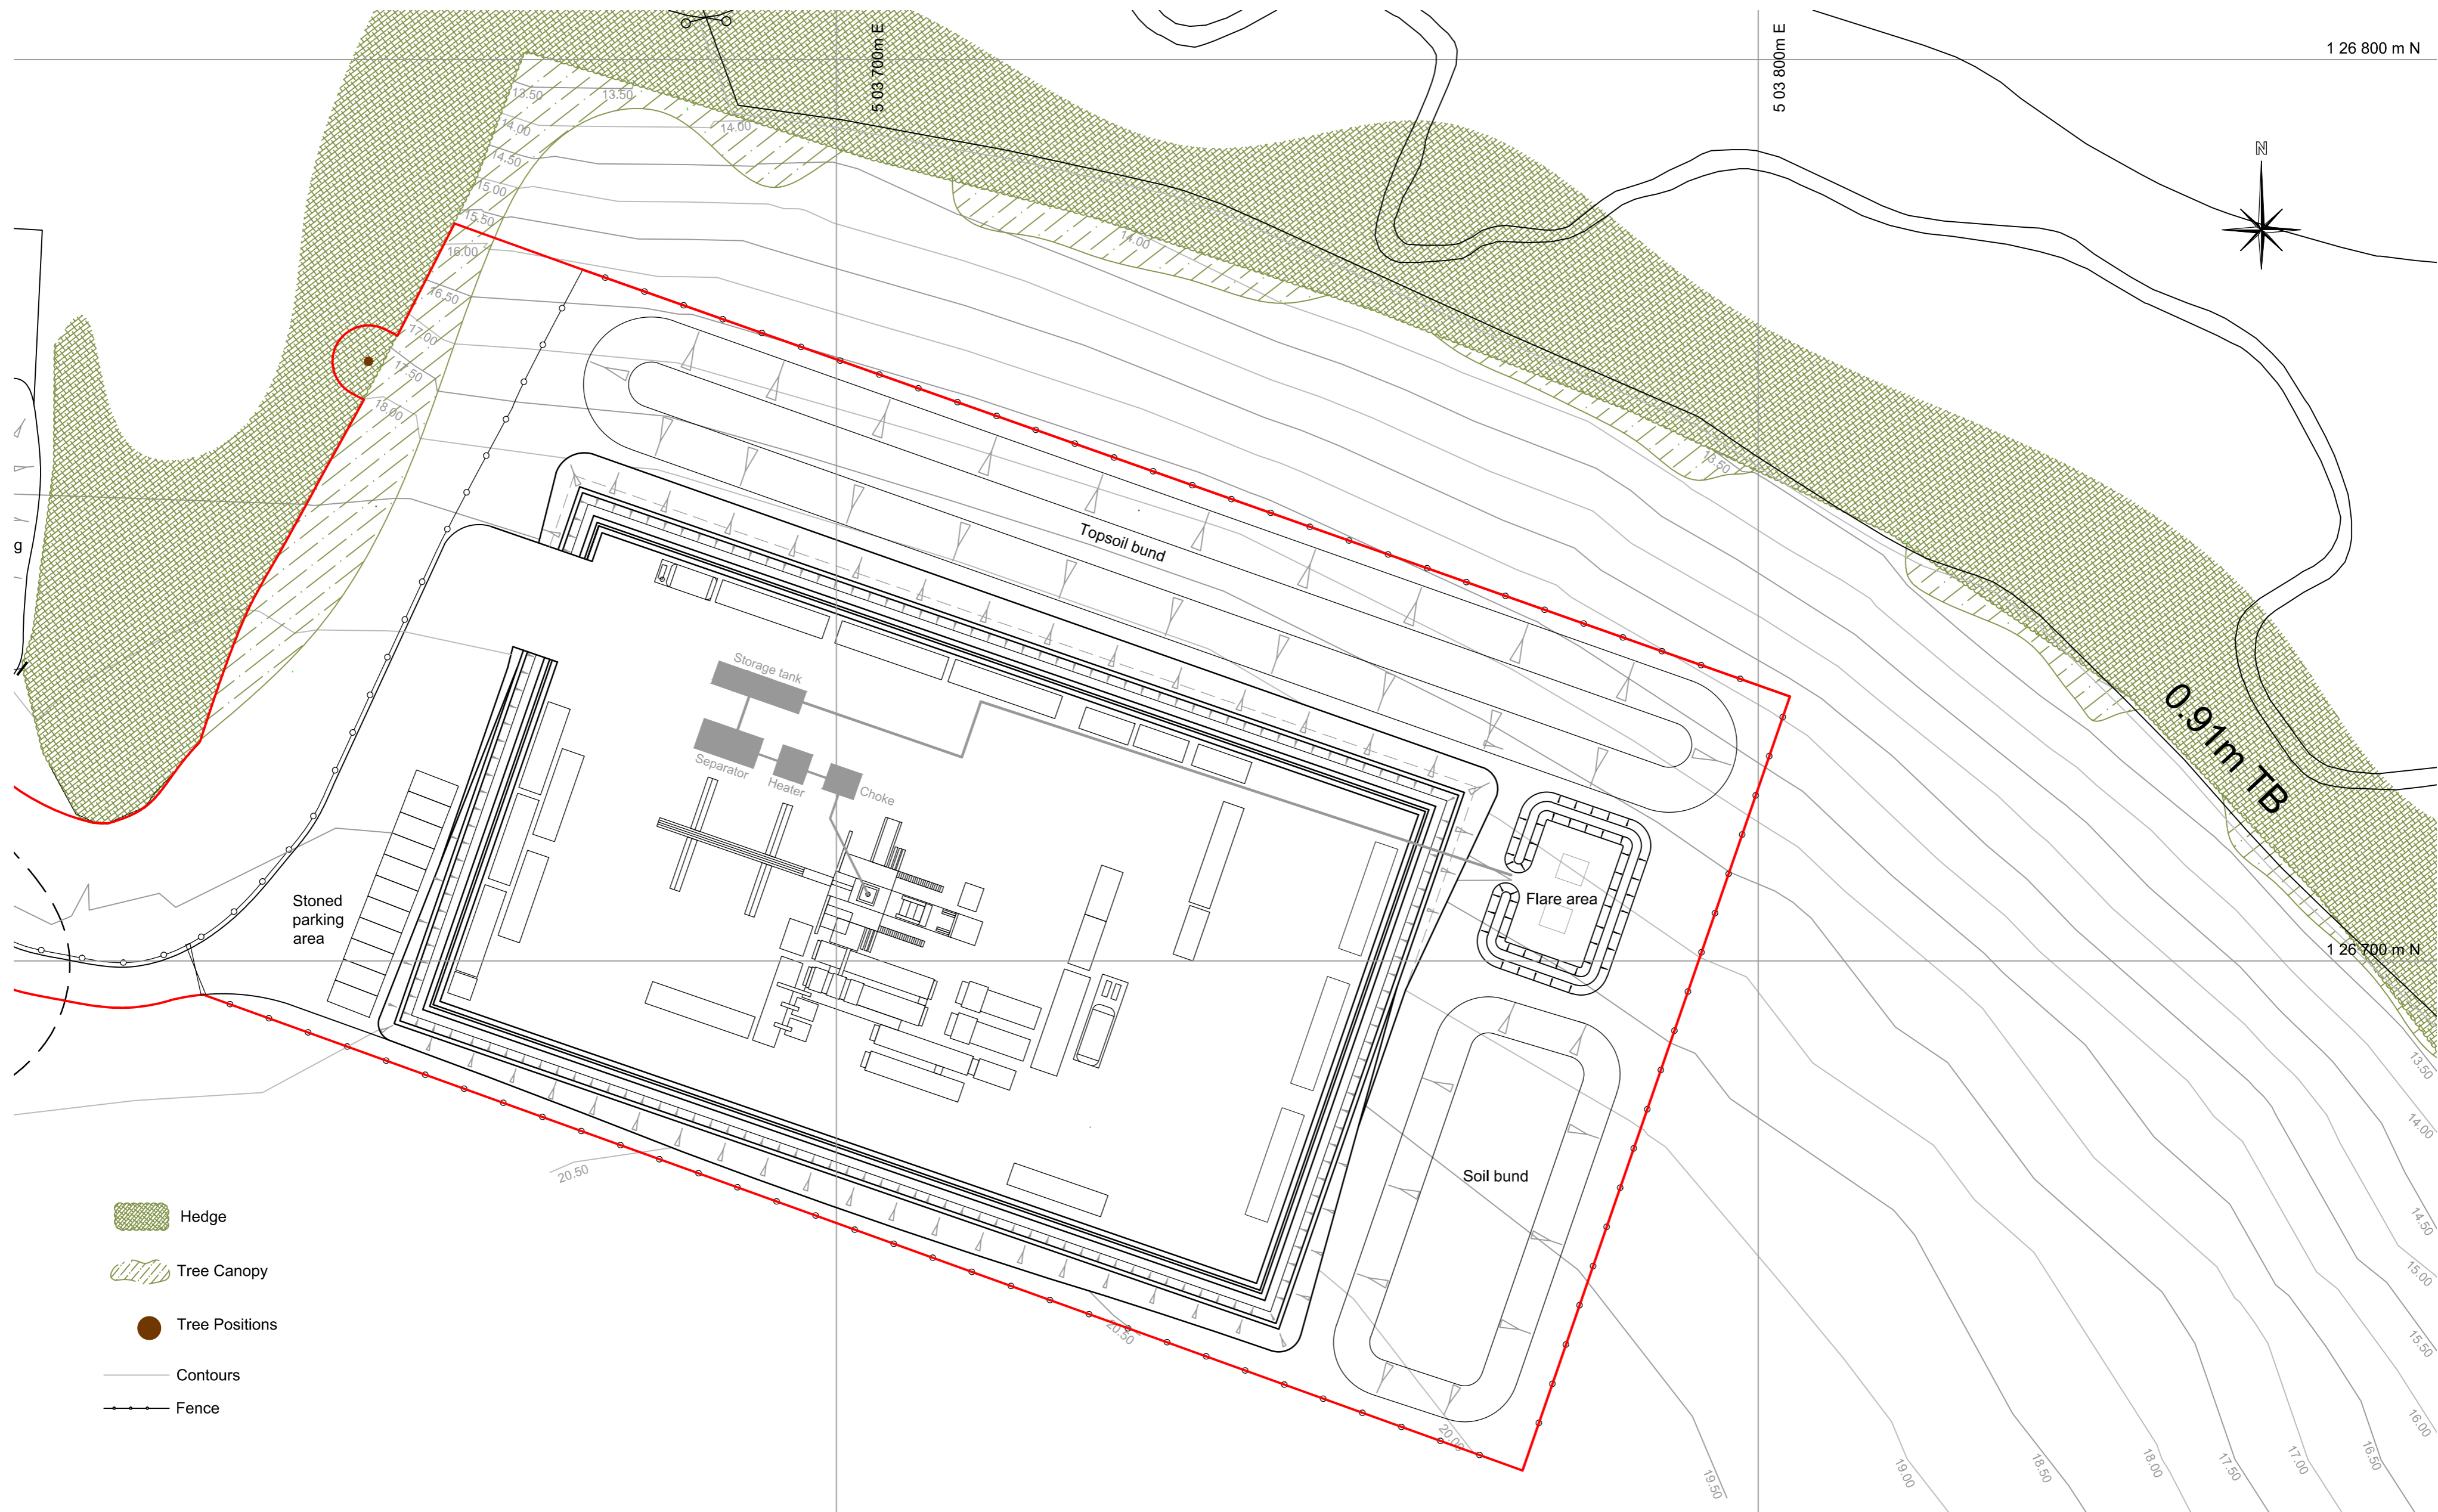


 ▲ Pumping unit installed on well for EWT with office and storage container in the background



-  Hedge
-  Tree Canopy
-  Tree Positions
-  Contours
-  Fence

 Proposed Site - Drill Stem Testing Mode
Scale 1:500



R ELLIOTT ASSOCIATES LTD
CONSULTING STRUCTURAL & CIVIL ENGINEERS


t: (01590) 683176 f: (01590) 683533 info@rea-ltd.co.uk www.rea-ltd.co.uk




Dennett House
Brighton Road
Sway
Lymington
Hampshire
SO41 6EB

Client: Celtique Energie Petroleum
Boxal Bridge
Wisborough Green
West Sussex
Job Title: Wisborough Green-1

Drawn By: AJNE	Date: August 2013	Sheet Size: A2
Drawing Title: Proposed Site - Drill Stem Testing Mode (1:500)		
Drawing Number: 3582 P 10	Revision: E	

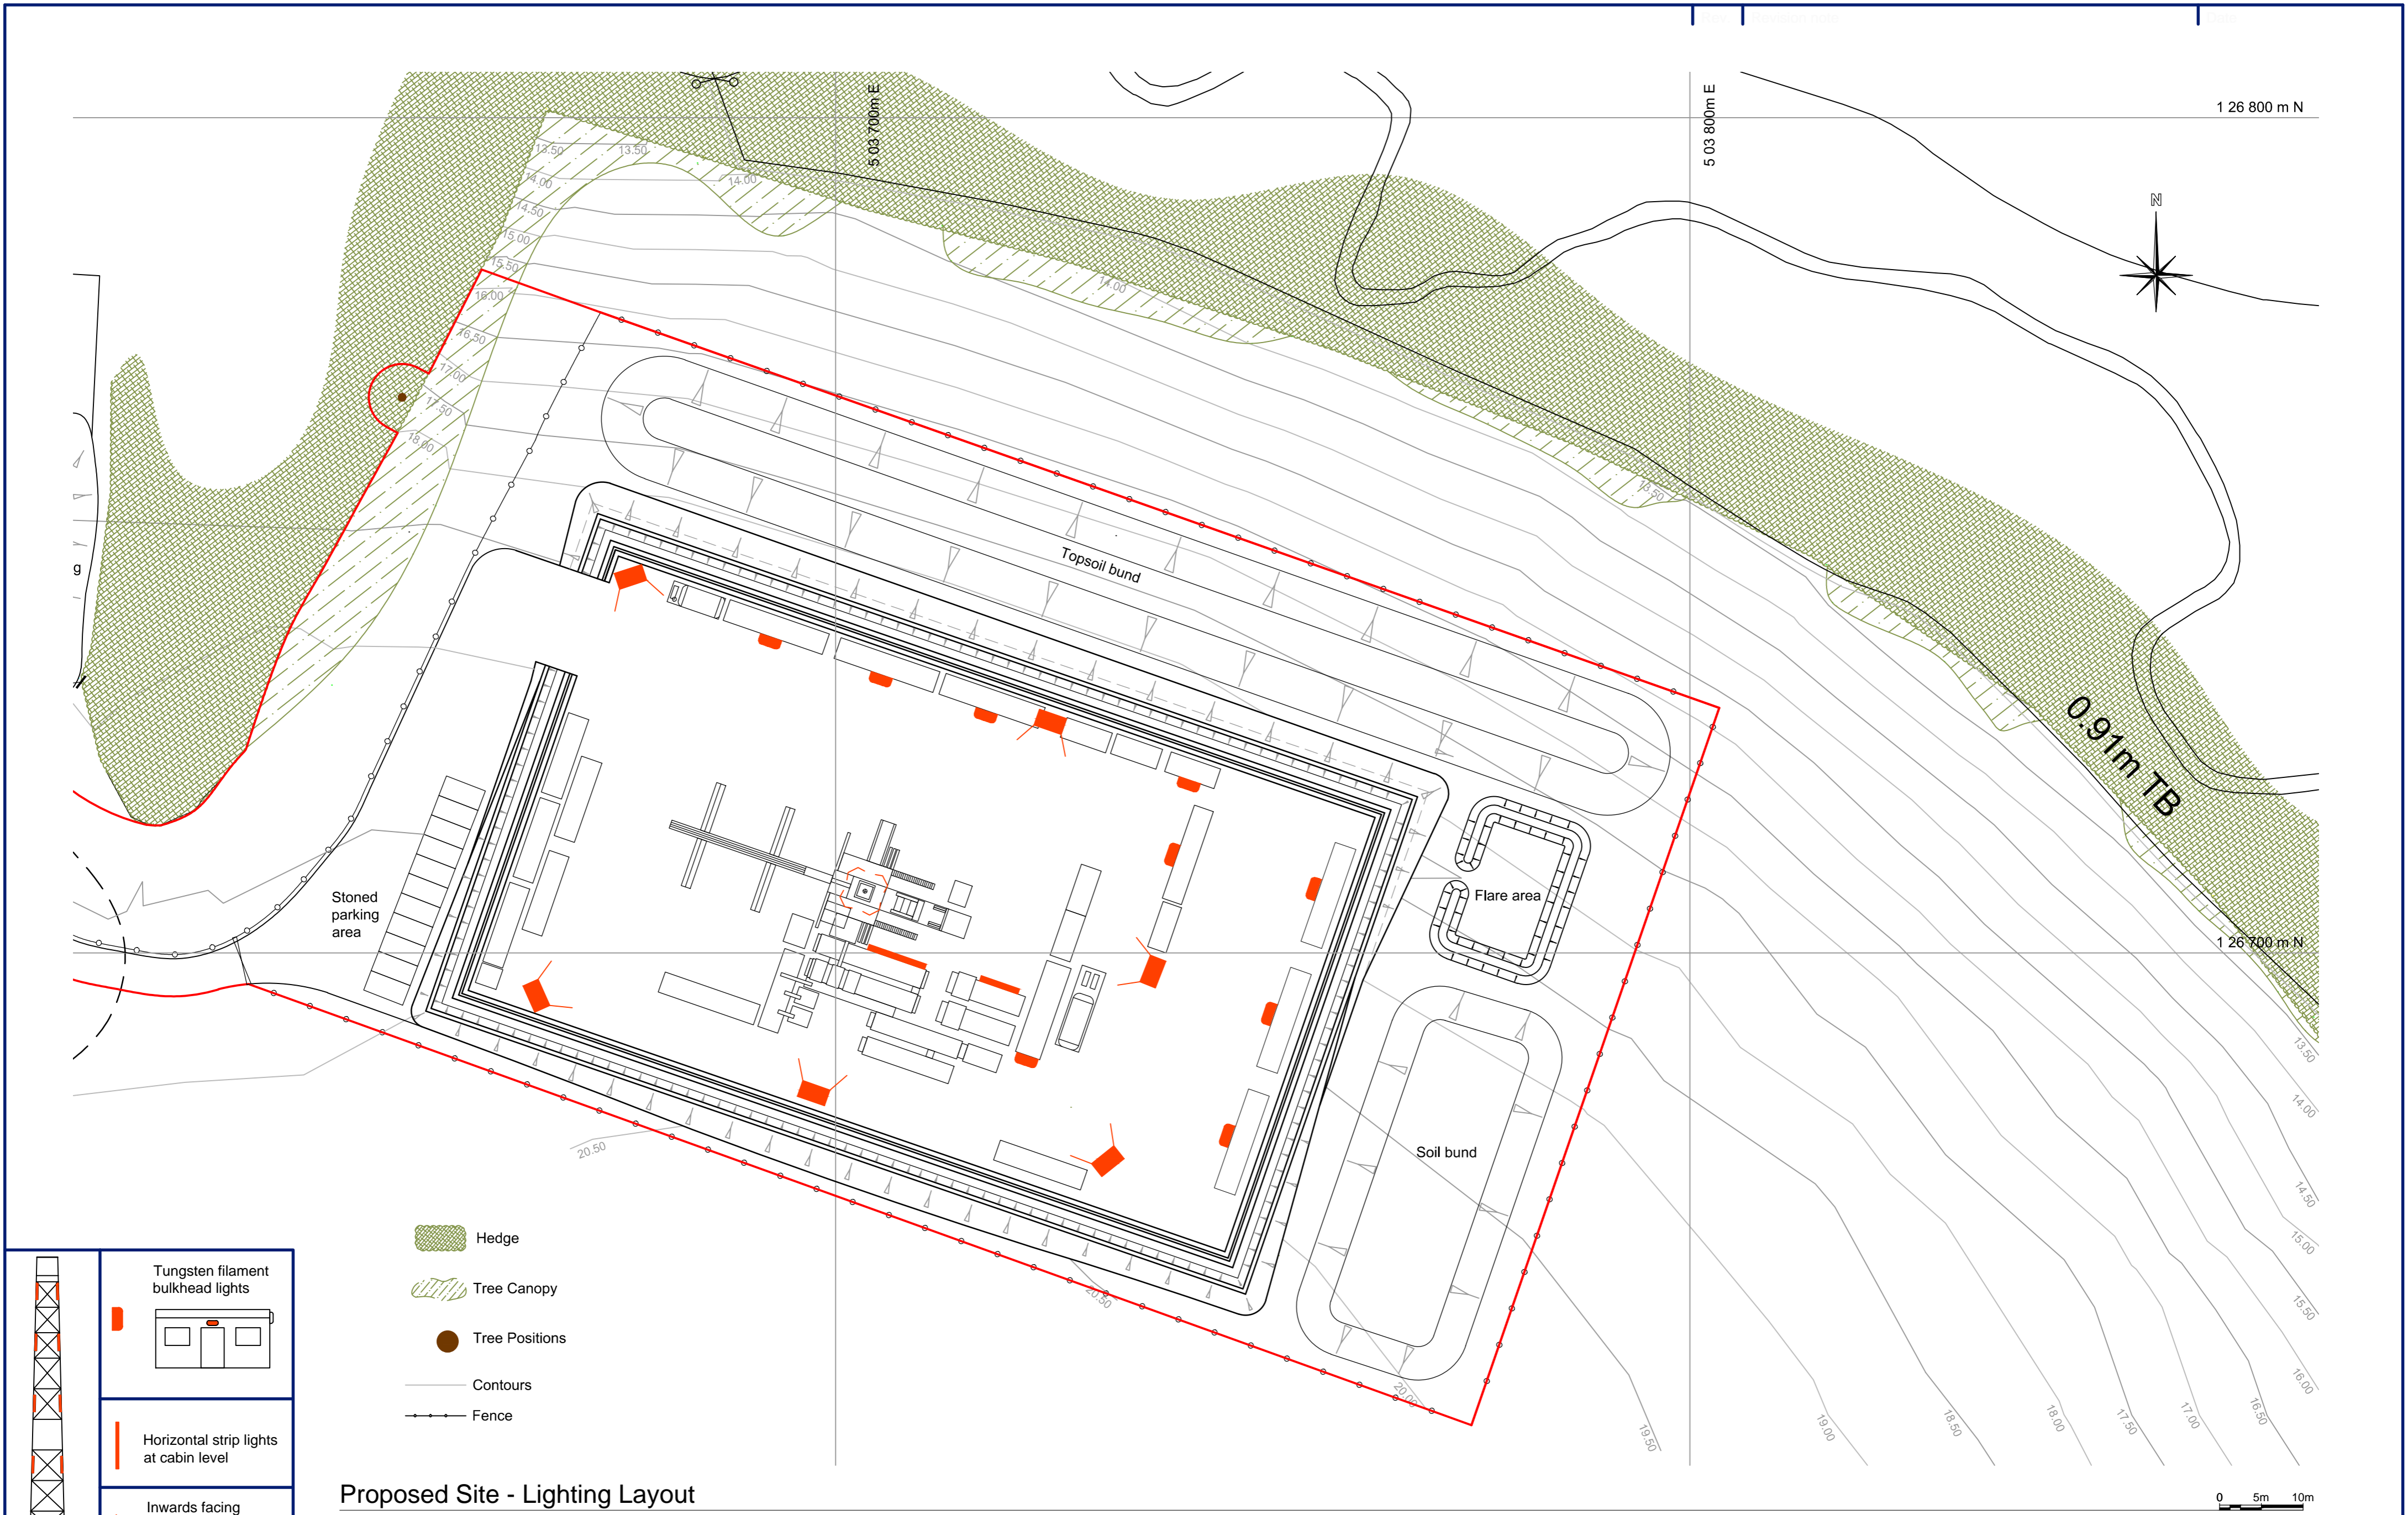


 
 


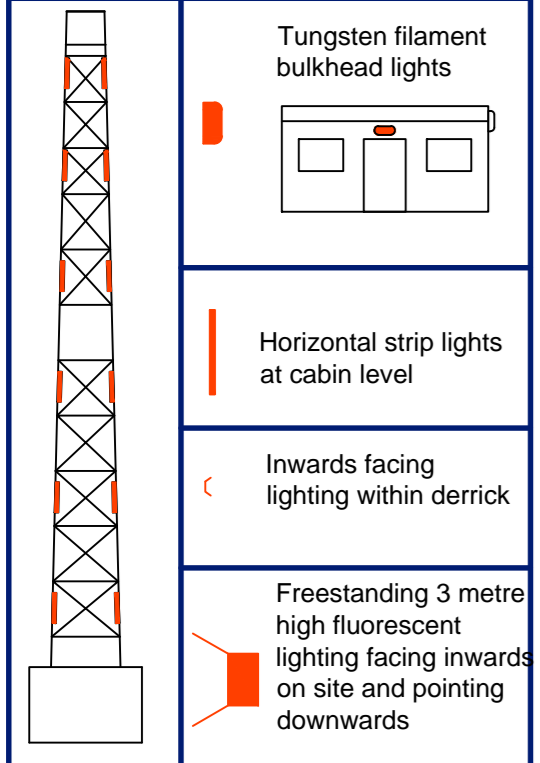Proposed Site - Lighting Layout
Scale 1:500



- Hedge
- Tree Canopy
- Tree Positions
- Contours
- Fence



-  Hedge
-  Tree Canopy
-  Tree Positions
-  Contours
-  Fence

Proposed Site - Reinstatement Plan
Scale 1:500

R ELLIOTT ASSOCIATES LTD
CONSULTING STRUCTURAL & CIVIL ENGINEERS

t: (01590) 683176 f: (01590) 683533 info@rea-ltd.co.uk www.rea-ltd.co.uk



Dennett House
Brighton Road
Sway
Lymington
Hampshire
SO41 6EB

Client	Celtique Energie Petroleum Boxal Bridge Wisborough Green West Sussex	Drawn By	AJNE	Date	August 2013	Sheet Size	A2
Job Title	Wisborough Green-1	Drawing Title				Proposed Site - Reinstatement Plan (1:500)	
		Drawing Number	3582 P 20			Revision	D